


Order Plans @ www.LDILine.com

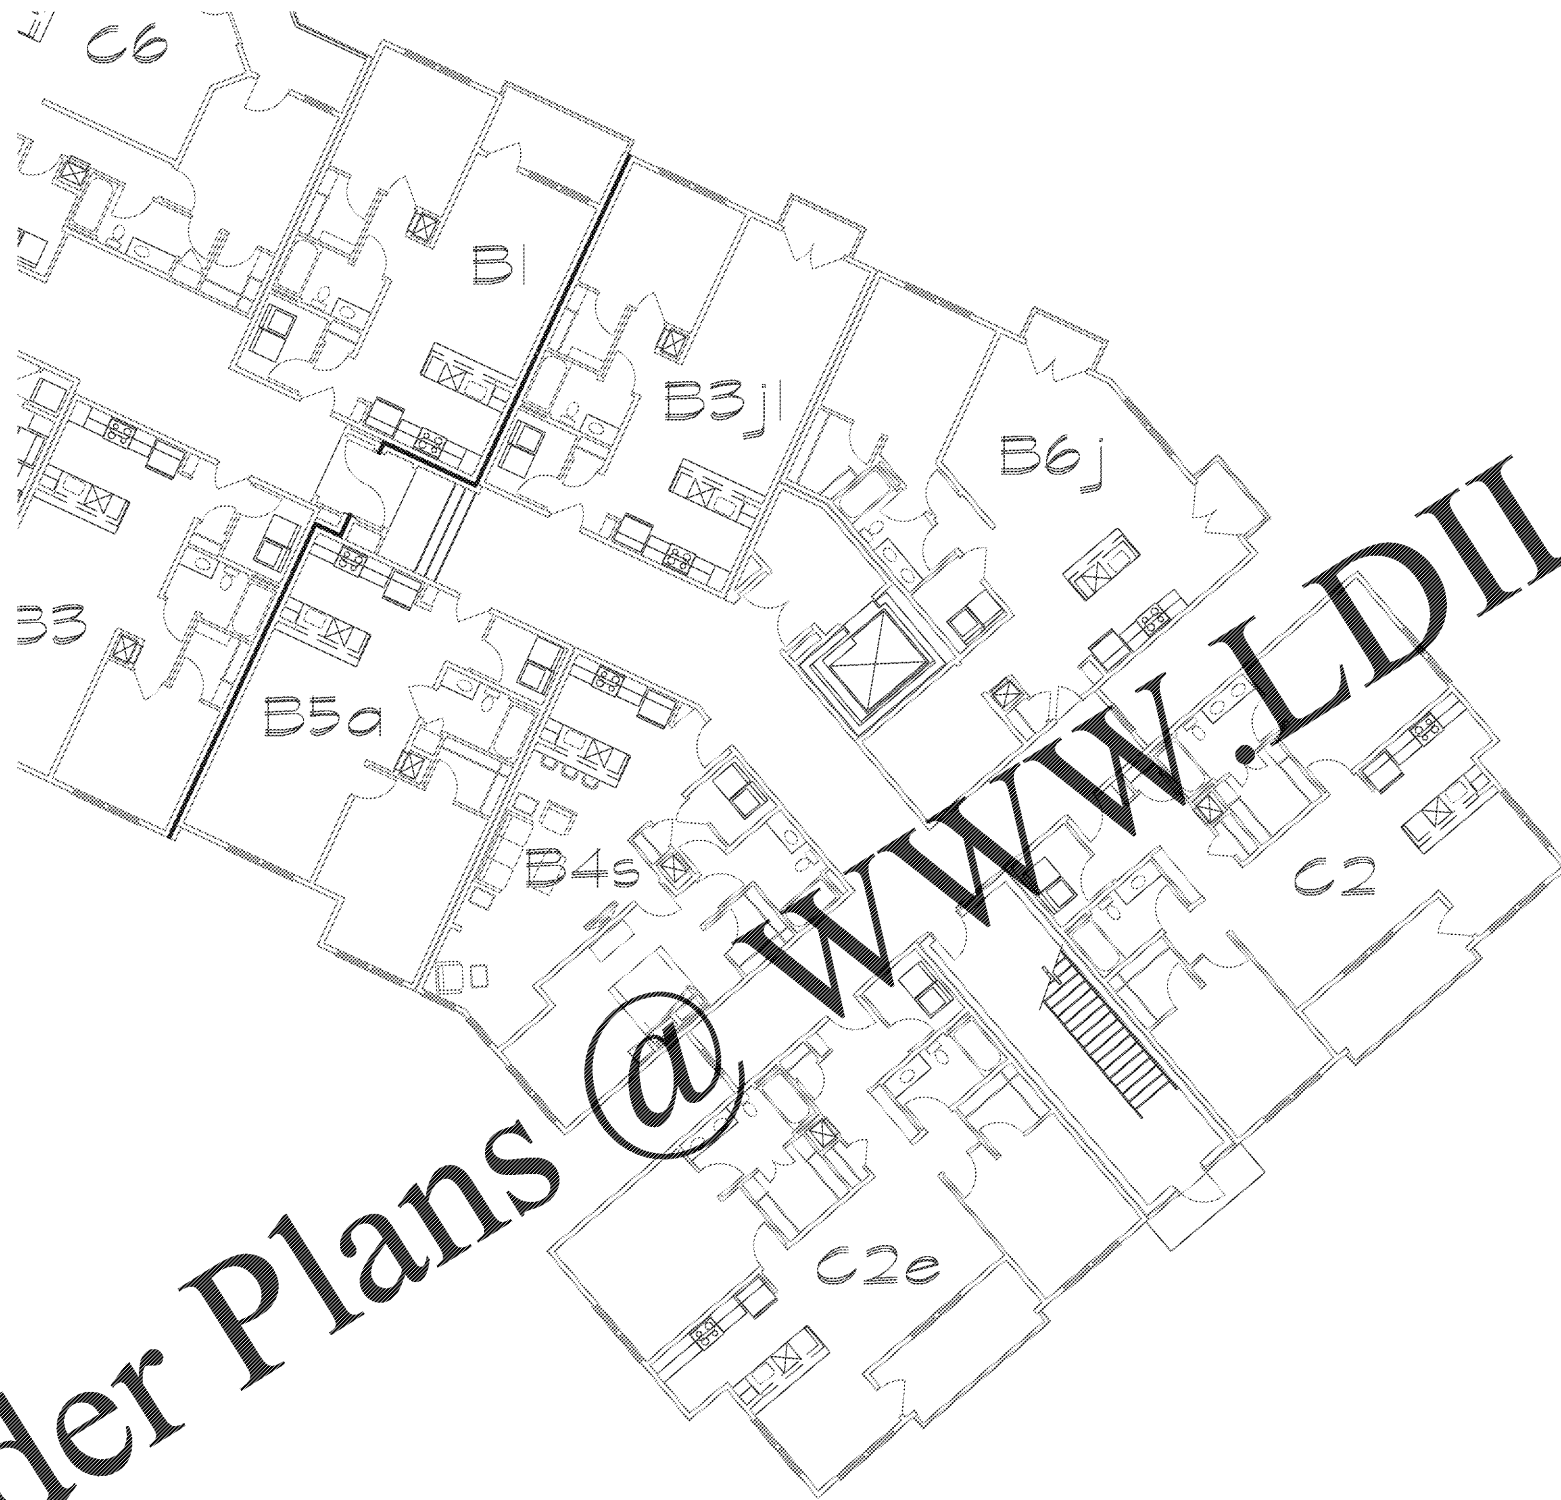

1 SECOND LEVEL BUILDING #4- PLUMBING PLAN
1/8" = 1'-0"



PROJECT 1915
DATE 01OCT19
DRAWN BY CME
CHECKED BY CME

SECOND LEVEL
BUILDING #4-
PLUMBING PLAN

P3.21

WLA
WATTS LEAF ARCHITECTS, PA
101 North McDowell Street Suite 112
Charlotte, North Carolina 28204
PH 704 376 1220 FX 704 376 5111

LD I
ENGINEERING
14301 SOUTH LAKES DRIVE, SUITE E
CHARLOTTE NC 28217
W.704-688-9320 C.704-968-8143
CONSULTING DESIGN-BUILD
NC LICENSE #P-1248

CRABTREE NORTH APTS.
2251 Charles Drive
Raleigh, North Carolina
EYC COMPANIES