




5 UNIT A6 - PLAN - MECHANICAL
1/4" = 1'-0"

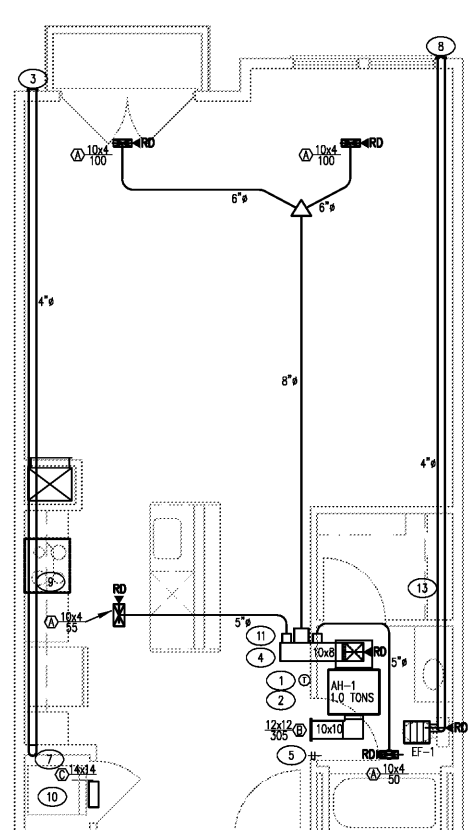


6 UNIT A6J - PLAN - MECHANICAL
1/4" = 1'-0"

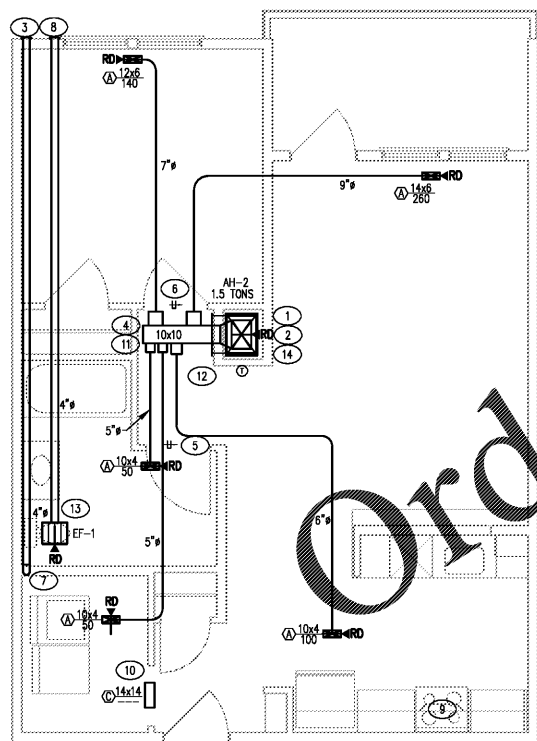


7 UNIT B1 HC - PLAN - MECHANICAL
1/4" = 1'-0"

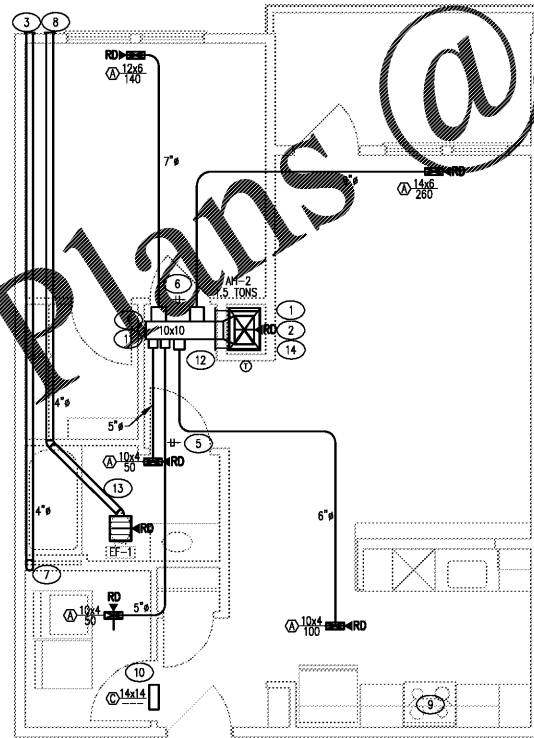

8 UNIT B1 - PLAN - MECHANICAL
1/4" = 1'-0"

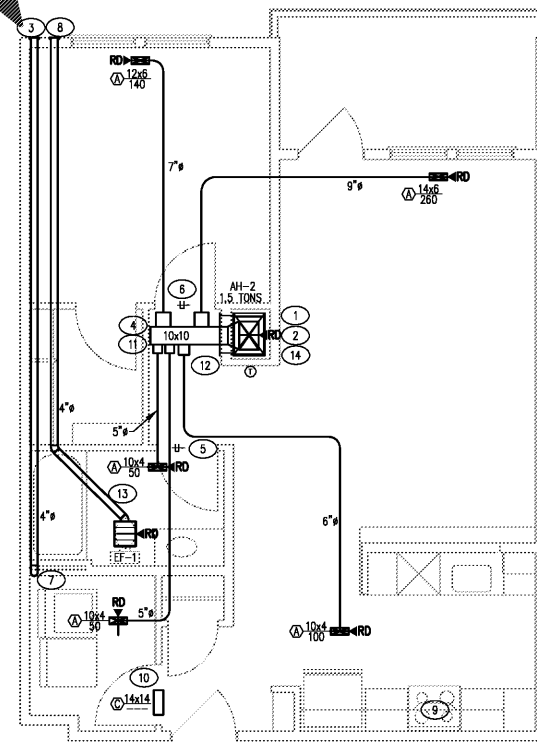

1 UNIT B1F - PLAN - MECHANICAL
1/4" = 1'-0"

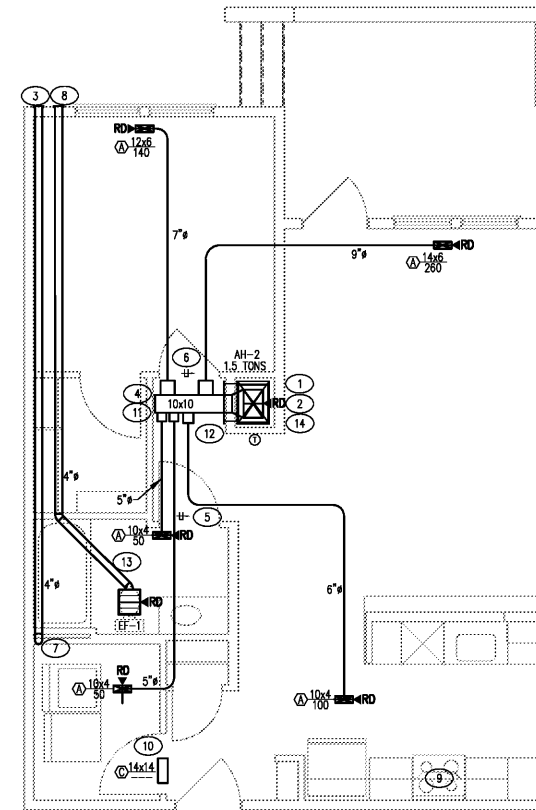

2 UNIT B2 - PLAN - MECHANICAL
1/4" = 1'-0"

- TAGGED NOTES**
- HVAC UNIT HANGER BRACKET FURNISHED & INSTALLED BY MECH. CONTRACTOR. UNIT SIZE, INSTALLATION, ETC., TO BE COORDINATED WITH GC & FRAMING CONTRACTOR.
 - 3/4" CONDENSATE DRAIN ROUTED TO HUB DRAIN (HD BY PC) IN MECH. CLOSET. REFER TO PLUMBING RISERS. COORDINATE W/ DUCTS, G.C., FRAMING CONTR., STRUCTURE, ETC.
 - DRYER VENT PIPE SHALL BE 4" SINGLE WALL RIGID SHEETMETAL PER MECH. CODE. M.C. TO PROVIDE 4" VENT CAP WITH DAMPER & SHALL CAULK BEHIND CAP WITH 100% SILICONE.
 - SUPPLY AIR PLENUM OFF AIR HANDLING UNIT SHALL BE MIN. 4' LONG, TYPICAL ALL UNITS.
 - ALL BATHROOM DOORS TO HAVE UNDERCUTS.
 - ALL ROOMS WITH S.A. TO HAVE DOOR UNDERCUTS FOR RETURN. SEE MECH. DOOR SCHEDULE FOR MORE INFORMATION.
 - 4" DRYER VENT DOWN WALL TO 2" ABOVE FINISHED FLOOR (LOWER FLOOR). 4" DRYER VENT UP WALL TO 2" ABOVE FINISHED FLOOR (UPPER FLOORS). PROVIDE RECESSED METAL BOX ABOVE RATED RECESS WHEN IN RATED WALL. PROVIDE THERMAL DRYER CAP WHEN IN RATED INTERSTITIAL SPACE/WALL. SEE DETAIL 3/01.4 FOR MORE INFORMATION.
 - 4" EYECAP WITH 2" COLLET TO MATCH WALL.
 - REOPERATING THIS RANGE HOOD BY OTHERS.
 - TRANSFER GRILLE FOR LAUNDRY ROOM. MIN. FREE AREA OF 100 SQ IN. IS REQUIRED. INSTALL GRILLE ABOVE DOOR(S). COORDINATE WITH STRUCTURAL.
 - SUPPLY AIR DUCT TRUNK TO RUN BETWEEN JOISTS. CONFIRM DIRECTION OF JOISTS DURING CONSTRUCTION AND ROTATE TRUNK 90° IF REQUIRED.
 - RETURN AIR THROUGH LOUVER, PART OF HVAC UNIT.
 - 4" GALVANIZED SHEET METAL FOR EXHAUST BATH FAN.
 - FIRESTAT EQUIVALENT TO DYNACON FS-200 TO BE INSTALLED IN SUPPLY DUCT. UNIT SHALL SHUTDOWN WHEN AIR TEMPERATURE REACHES THE PRESET LEVEL OF 135 DEG FAHRENHEIT. COORDINATE CONNECTION WITH E.C.

WWW.LDILLINGHAM.COM

Order Plans @



WATTS LEAF ARCHITECTS, PA
101 North McDowell Street, Suite 112
Charlotte, North Carolina 28204
PH 704.376.1202 FX 704.376.5111

CRABTREE NORTH APTS.
2251 Charles Drive
Raleigh, North Carolina
EYC COMPANIES

PROJECT 1915
DATE 01OCT19
DRAWN BY CME
CHECKED BY CME

UNIT PLANS - MECHANICAL
M2.03