 



FOUNDATION PLAN NOTES

- ELEVATIONS IN FTG/PIER TAGS AND NOTED (-X'-X") ON PLAN ARE REFERENCED FROM FINISHED FLOOR DATUM ELEVATION.
- BOTTOM OF PERIMETER FTGS SHALL BE AT LEAST 18" BELOW LOWEST ADJACENT FINISHED GRADE/T.O. PAVEMENT.
- SOIL BENEATH FOOTINGS SHALL BE INSPECTED AND APPROVED BY THE GEOTECHNICAL CONSULTANT PRIOR TO PLACING THE CONCRETE.
- COORDINATE ALL EXIST AND NEW UTILITY LINE LOCATIONS WITH SITE AND/OR MECH DWGS. REPORT ANY AND ALL INTERFERENCES WITH FDN CONFIGURATIONS TO ENGINEER PRIOR TO INSTALLING FDN.
- "CJ" = SUGGESTED WALL CONTROL JOINT LOCATIONS.
- TOP OF FOUNDATION WALL ELEVATION @ ALL DOORWAYS = (-0'-8"), UNO.

FOOTING/PIER LEGEND




MARK	SIZE (W X L X T)	REINFORCEMENT
F4.0	4'-0" X 4'-0" X 1'-2"	4 - #5 EA WAY
F4.5	4'-6" X 4'-6" X 1'-2"	5 - #5 EA WAY
F5.0	5'-0" X 5'-0" X 1'-4"	4 - #6 EA WAY
F5.5	5'-6" X 5'-6" X 1'-6"	5 - #6 EA WAY
F6.0	6'-0" X 6'-0" X 1'-6"	6 - #6 EA WAY
F6.5	6'-6" X 6'-6" X 1'-6"	6 - #6 EA WAY
F7.0	7'-0" X 7'-0" X 1'-8"	7 - #6 EA WAY
F7.5	7'-6" X 7'-6" X 1'-10"	6 - #7 EA WAY
F8.0	8'-0" X 8'-0" X 1'-10"	7 - #7 EA WAY

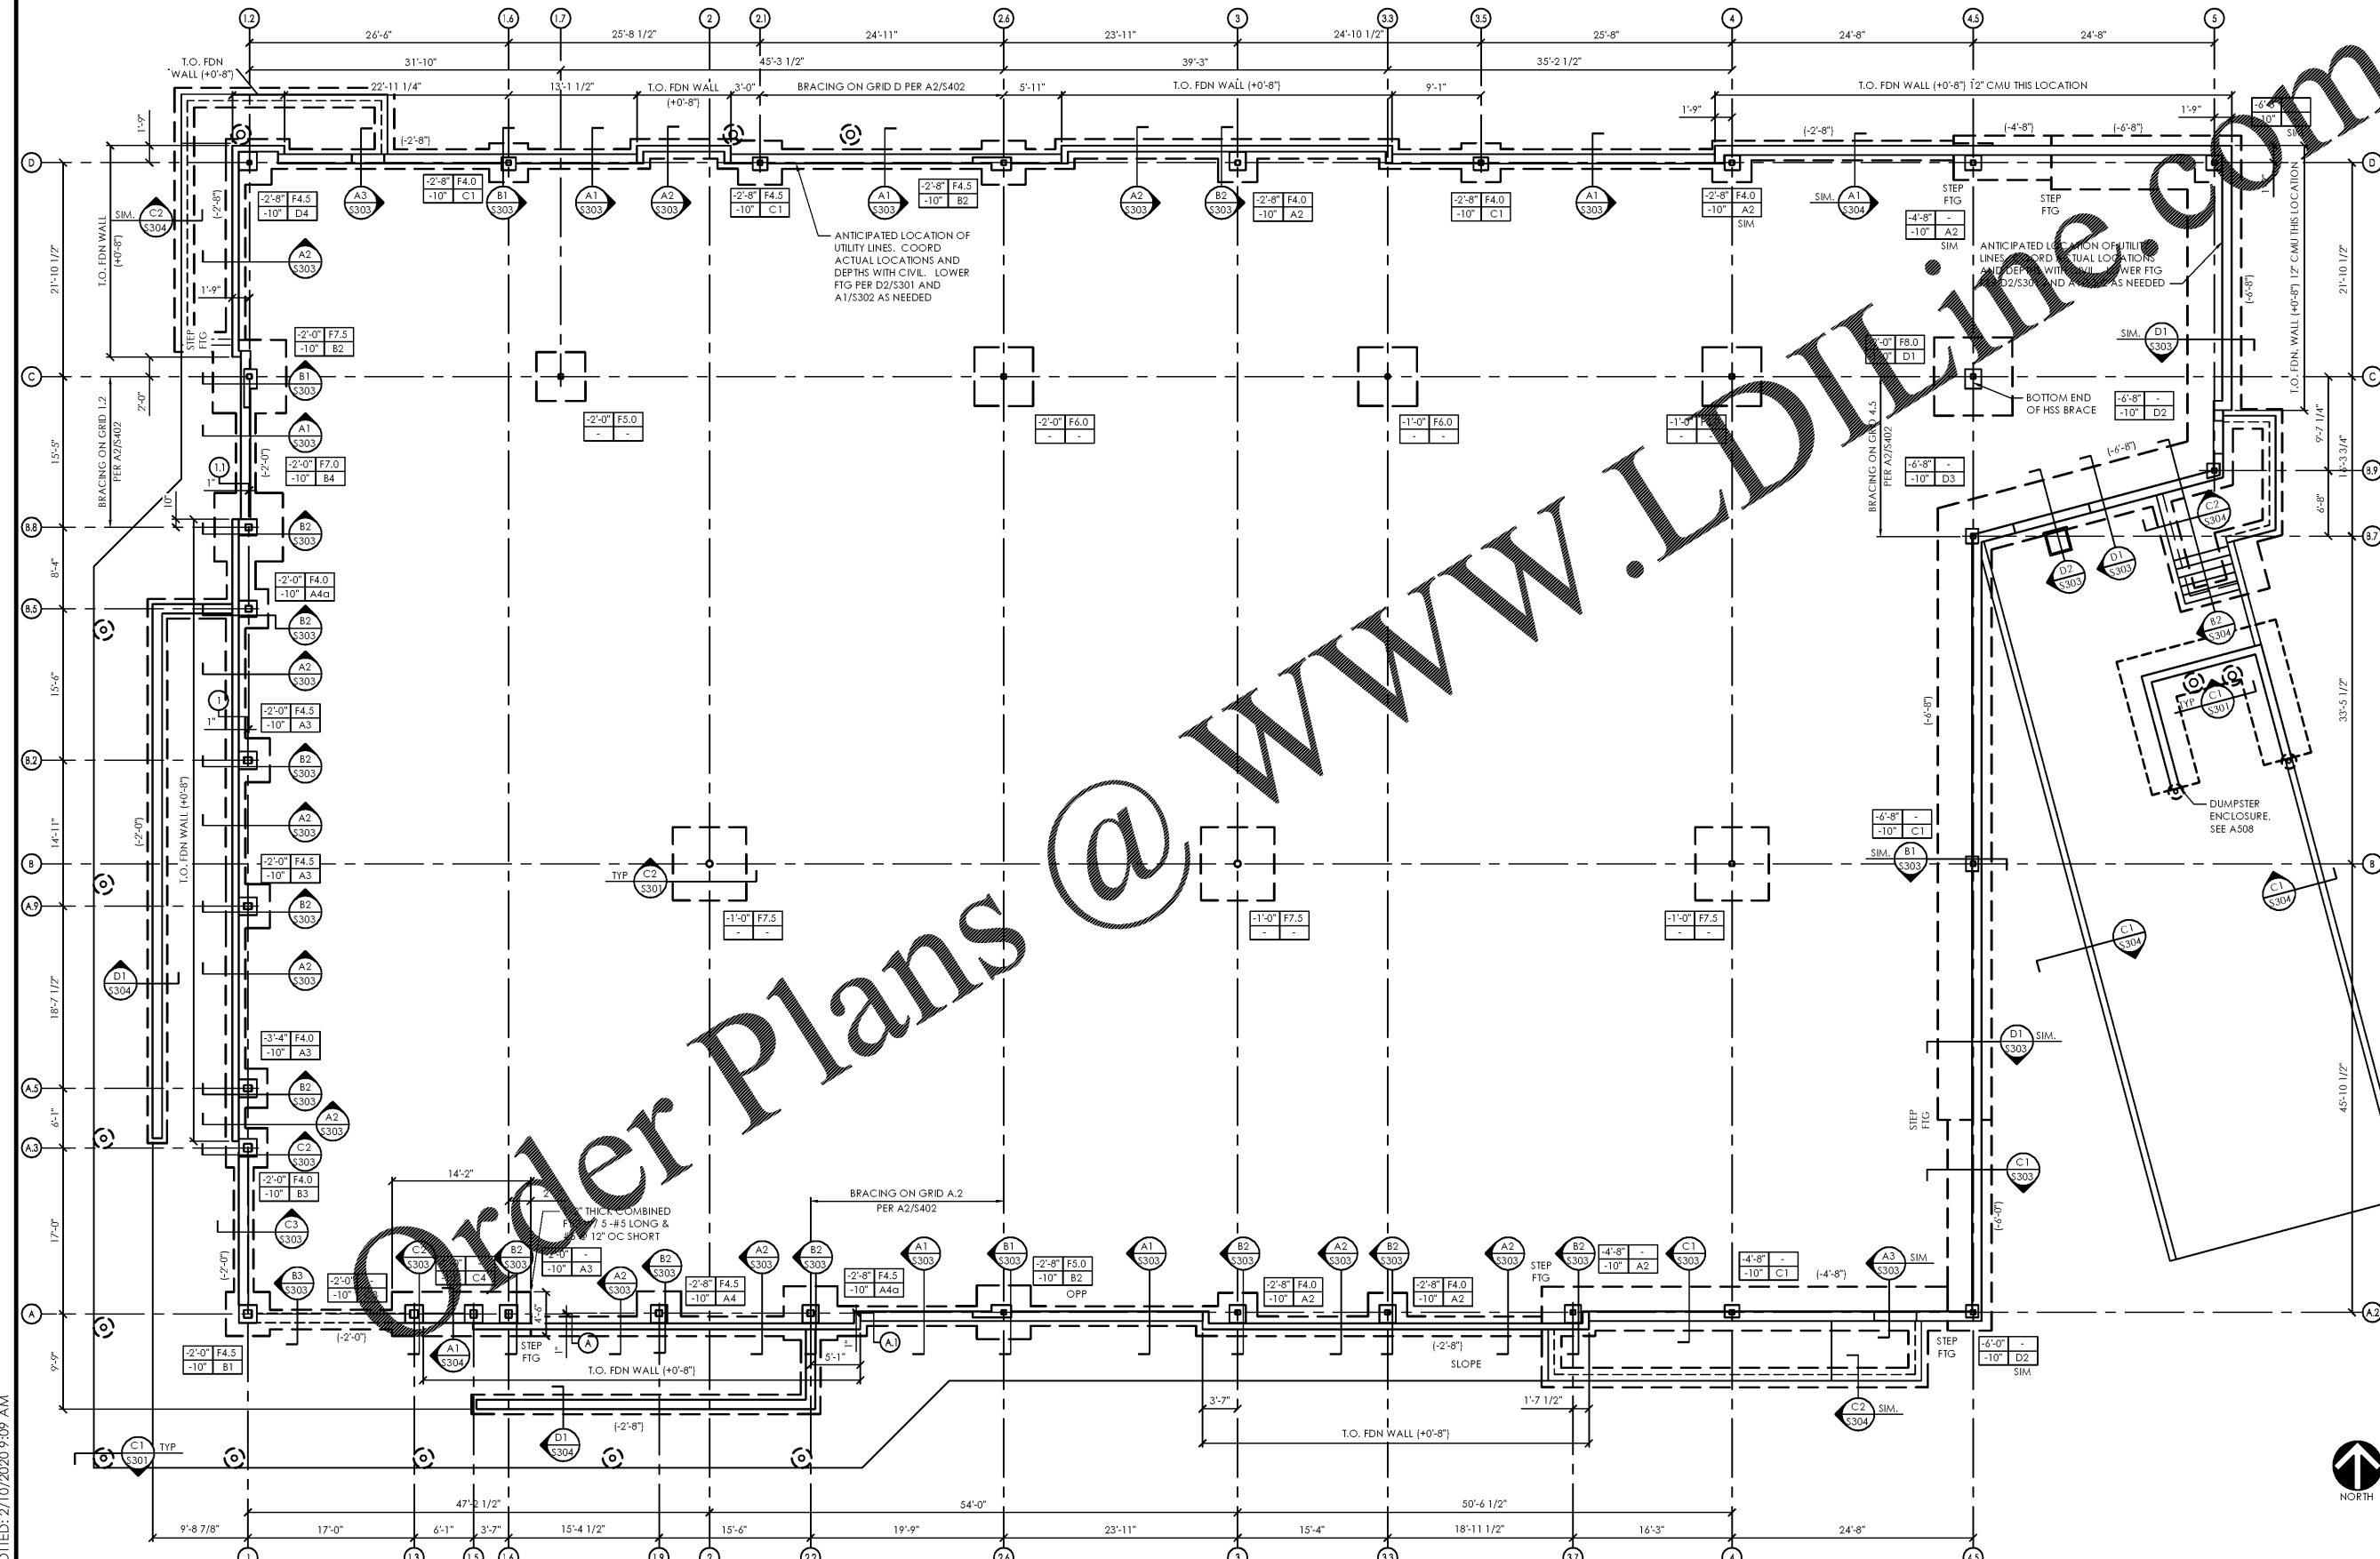

Revisions:	Date:
A Client Review Set	05/07/19
B Permit Set	06/12/19
C Client Review Set	02/07/20
D Bid Set	02/10/20

DO NOT SCALE PLANS
 Copying, Printing, Software and other processes required to produce these prints can stretch or shrink the actual paper or layout. Therefore, scaling of this drawing may be inaccurate. Contact us consultants with any need for additional dimensions or clarifications.

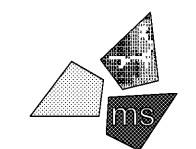

ms consultants, inc.
 engineers, architects, planners
 5444 Wade Park Blvd.
 Suite 160
 Raleigh, NC 27607-4299
 phone 919.772.5565
 fax 919.779.2308

DRAWN BY: CLS
 REVIEWED BY: DMS/CJH

Seal
 PROFESSIONAL OF RECORD:
 CRAIG E. METZGER PE No. 044723
 EXP. DATE: 12/31/19



ALDI Inc.
 1985 Old Union Church Road
 Salisbury, NC 28146
 (704) 642-2002
 (704) 642-0078 fax

ALDI Inc. Store #: 154
 Cornelius, NC
 20101 West Catawba Avenue
 Cornelius, NC 28031
 Mecklenburg County
 Project Name & Location:

Foundation Plan

Drawing Name:
 Prototype Rls. 12/10/18
 Type: LHSD-V8ER

Project No.
 40452-07

S-101
 Drawing No.

Scale: 1/8"=1'-0"

PLOTTED: 2/10/2020 9:09 AM