


D1 One-Line Diagram
SCALE: None

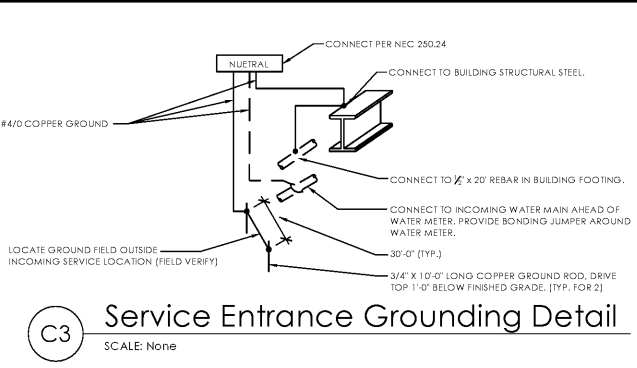

Issued:	Date:
A Client Review Set	05/07/19
B Permit Set	06/12/19
C Client Review Set	02/07/20
D Bid Set	02/10/20
Revisions:	Date:

DO NOT SCALE PLANS
Copying, Printing, Software and other processes required to produce these prints can stretch or shrink the actual paper or layout. Therefore, scaling of this drawing may be inaccurate. Contact mrc consultants with any need for additional dimensions or clarifications.

mrc consultants, inc.
engineers, architects, planners
5444 Wade Park Blvd.
Suite 160
Raleigh, NC 27607-4299
phone 919.772.5565
fax 919.779.2308

DRAWN BY:	MEM
REVIEWED BY:	KFF

Seal

PROFESSIONAL OF RECORD:
JASON E. CHRISTOFF No. 039391
EXP. DATE: 12/31/2020

ALDI Inc.
1985 Old Union Church Road
Salisbury, NC 28146
(704) 442-0023
(704) 642-0079 fax

ALDI Inc. Store #: 154
Cornelius, NC
20101 West Catawba Avenue
Cornelius, NC 28031
Mecklenburg County
Project Name & Location:

One-Line Diagram & Schedules Drawing Name:	
Prototype Rls. 12/10/18	Project No. 40452-07
Type: LHSD-V8ER	
	E-401
Scale: As Noted	Drawing No.