



**EUBANKS ENGINEERING PC**  
**HUMPHREY**  
 100 NORTH GREENE STREET  
 SUITE 100  
 GREENSBORO, NC 27401  
 Phone 336.273.0101  
 Fax 336.273.0141

NC FIRM LICENSE: C-2272



TEAM  
 FRYALDENHOVEN  
 FRYALDENHOVEN  
 ARCHITECTS & PLANNERS, LLP

100 NORTH GREENE STREET  
 SUITE 100  
 GREENSBORO, NC 27401  
 NORTH CAROLINA 27401  
 TEL 336.273.0101  
 FAX 336.273.0141

CANTERBURY SCHOOL  
 P. DAVID BROWN LIBRARY AND  
 ADMINISTRATION BUILDING  
 5400 OLD LAKE JEANETTE RD  
 GREENSBORO, NORTH CAROLINA

DATE

30JAN20

EHEPC PROJECT #

1969

REVISIONS


NO.	DATE	DESCRIPTION

THIS DRAWING IS THE PROPERTY OF EUBANKS ENGINEERING PC. IT IS TO BE USED ONLY FOR THE PROJECT AND SITE SPECIFICALLY IDENTIFIED HEREON. IT IS NOT TO BE REPRODUCED OR TRANSMITTED IN ANY FORM OR BY ANY MEANS, WITHOUT THE EXPRESS WRITTEN CONSENT OF THE ENGINEER. © 2020 EUBANKS ENGINEERING PC


SHEET

**M-2**

OF 6

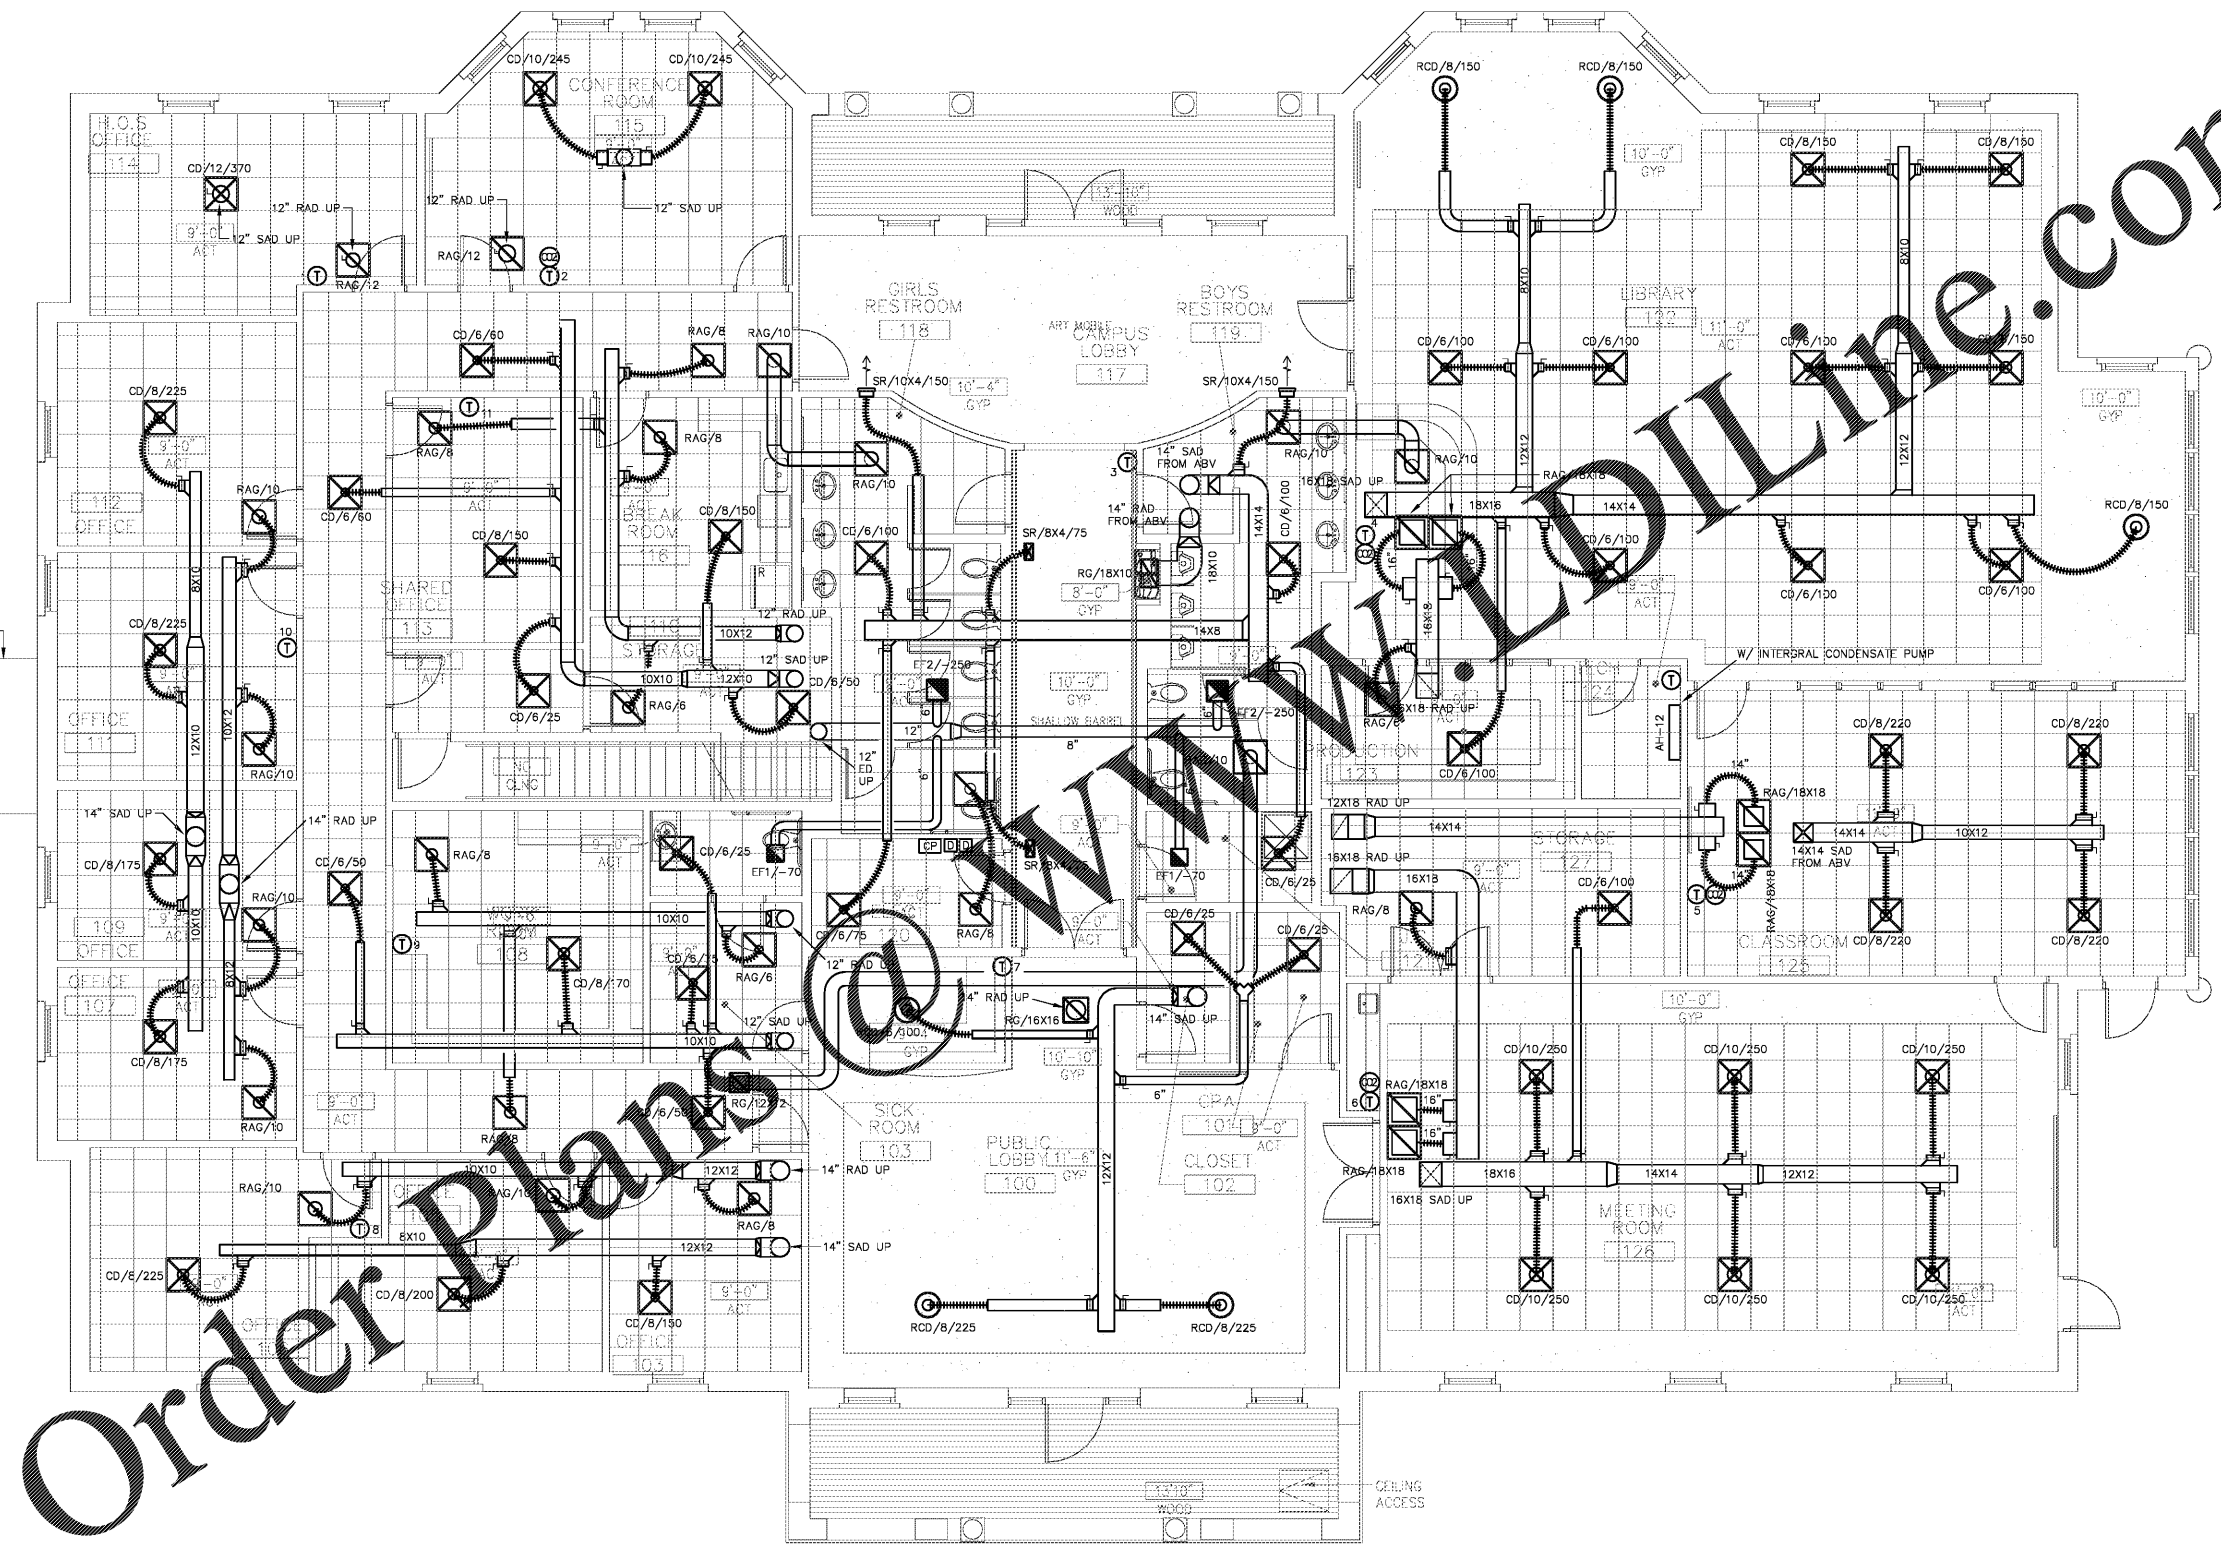

 Order Plans @ [www.dlline.com](mailto:www.dlline.com)



**HVAC PLAN**

SCALE: 3/16" = 1'-0"