


Order Plans @ [www.dlline.com](mailto:www.dlline.com)

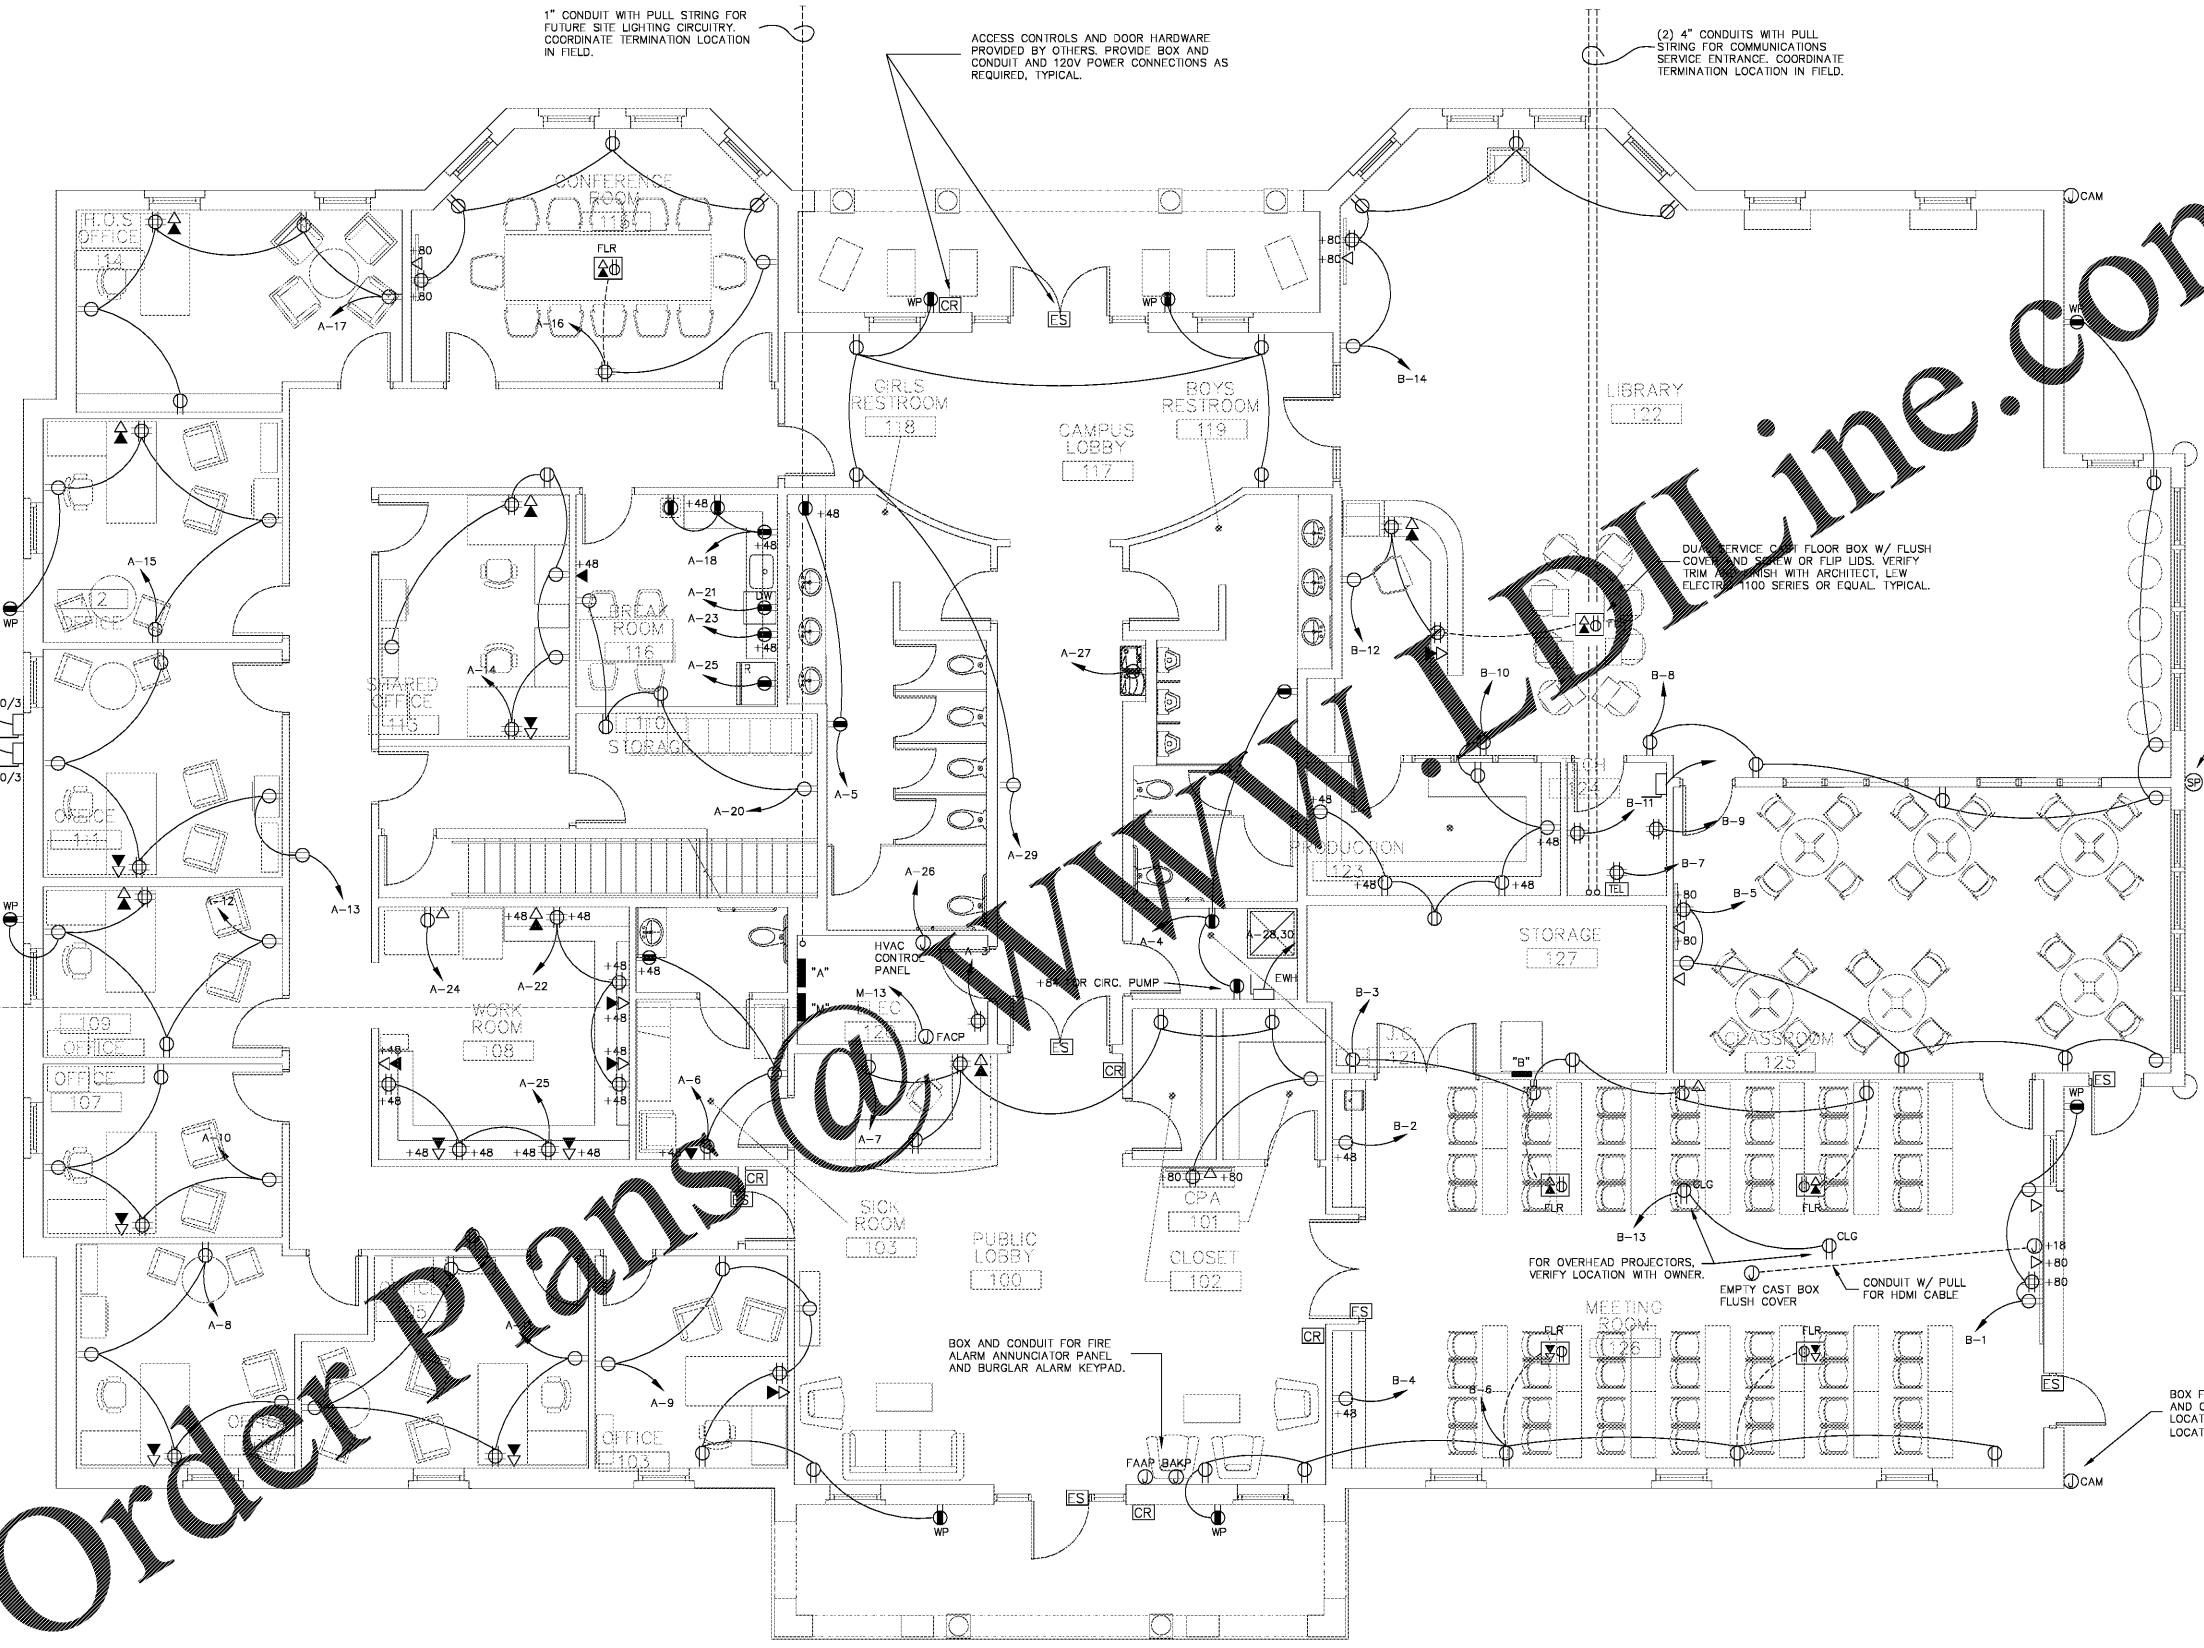

1" CONDUIT WITH PULL STRING FOR FUTURE SITE LIGHTING CIRCUITRY. COORDINATE TERMINATION LOCATION IN FIELD.

ACCESS CONTROLS AND DOOR HARDWARE PROVIDED BY OTHERS. PROVIDE BOX AND CONDUIT AND 120V POWER CONNECTIONS AS REQUIRED, TYPICAL.

(2) 4" CONDUITS WITH PULL STRING FOR COMMUNICATIONS SERVICE ENTRANCE. COORDINATE TERMINATION LOCATION IN FIELD.

DUPLICATE SERVICE CHASE FLOOR BOX W/ FLUSH COVER AND SCHEDULE OR FLIP LIDS. VERIFY TRIM FINISH WITH ARCHITECT, LEW ELECTRIC 1100 SERIES OR EQUAL. TYPICAL.

BOX AND CONDUIT TO ACCESSIBLE SPACE ABOVE HUNG CEILING FOR EXTERIOR SPEAKER BY OTHERS. MOUNTING LOCATION TO BE COORDINATED IN FIELD.


BOX FOR CAMERA BY OTHERS AND CONDUIT TO ACCESSIBLE LOCATION IN ATTIC, VERIFY LOCATION W/ OWNER, TYPICAL.

SERVICE CONDUCTORS FROM TRANSFORMER SECONDARY, COORDINATE ALL WORK W/ DUKE ENERGY.

BOX AND CONDUIT FOR FIRE ALARM ANNUNCIATOR PANEL AND BURGLAR ALARM KEYPAD.

FOR OVERHEAD PROJECTORS, VERIFY LOCATION WITH OWNER.

EMPTY CAST BOX FLUSH COVER CONDUIT W/ PULL FOR HDMI CABLE

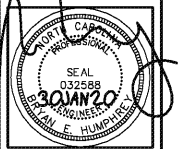

**EUBANKS HUMPHREY**  
ENGINEERING P.C.  
102 Parkway, Suite 2100  
Greensboro, NC 27402  
Phone 336.273.0101  
Fax 336.273.0141

NC FIRM LICENSE: C-2272



THE ASSOCIATE  
FREYALDENHOVER  
FREYALDENHOVER  
ARCHITECTS & PLANNERS, LLP

100 NORTH GREENE STREET  
SUITE 1101  
GREENSBORO, NC 27401  
TEL. 336.273.0101  
FAX. 336.273.0141

CANTERBURY SCHOOL  
P. DAVID BROWN LIBRARY AND  
ADMINISTRATION BUILDING  
5400 OLD LAKE JEANETTE RD  
GREENSBORO, NORTH CAROLINA

DATE  
30JAN20  
EHEPC PROJECT #  
1969



REVISIONS

DATE OWNERS REPRESENTATIVE SHALL  
AND SHALL BECOME PROPERTY OF THE OWNER.  
YOUR OWNERS AND PROJECTS ONLY.  
CANNOT BE REPRODUCED OR TRANSMITTED IN  
ANY FORM OR BY ANY MEANS, ELECTRONIC OR  
MECHANICAL, INCLUDING PHOTOCOPYING, RECORDING,  
OR BY ANY INFORMATION STORAGE AND RETRIEVAL  
SYSTEMS, WITHOUT THE WRITTEN PERMISSION OF  
THE ENGINEER.

SHEET

**E-2**

  OF 6



# POWER PLAN

SCALE: 3/16" = 1'-0"