


CORRIDOR COVE DETAIL  
NO SCALE

PROVIDE FIXTURE W/ LOW TEMP  
EMERGENCY BATTERY, INDICATOR  
LIGHT & TEST SWITCH, CONSULT  
MANUFACTURER FOR SELECTION.

EMERGENCY BATTERY PACK FIXTURES  
SHALL BE POWERED FROM UNSWITCHED  
HOT OF LOCAL LIGHTING CIRCUIT,  
TYPICAL.

+/- 13' AFF TO CENTER  
OF FIXTURE, CENTERED IN  
FACIA BOARD TYPICAL.

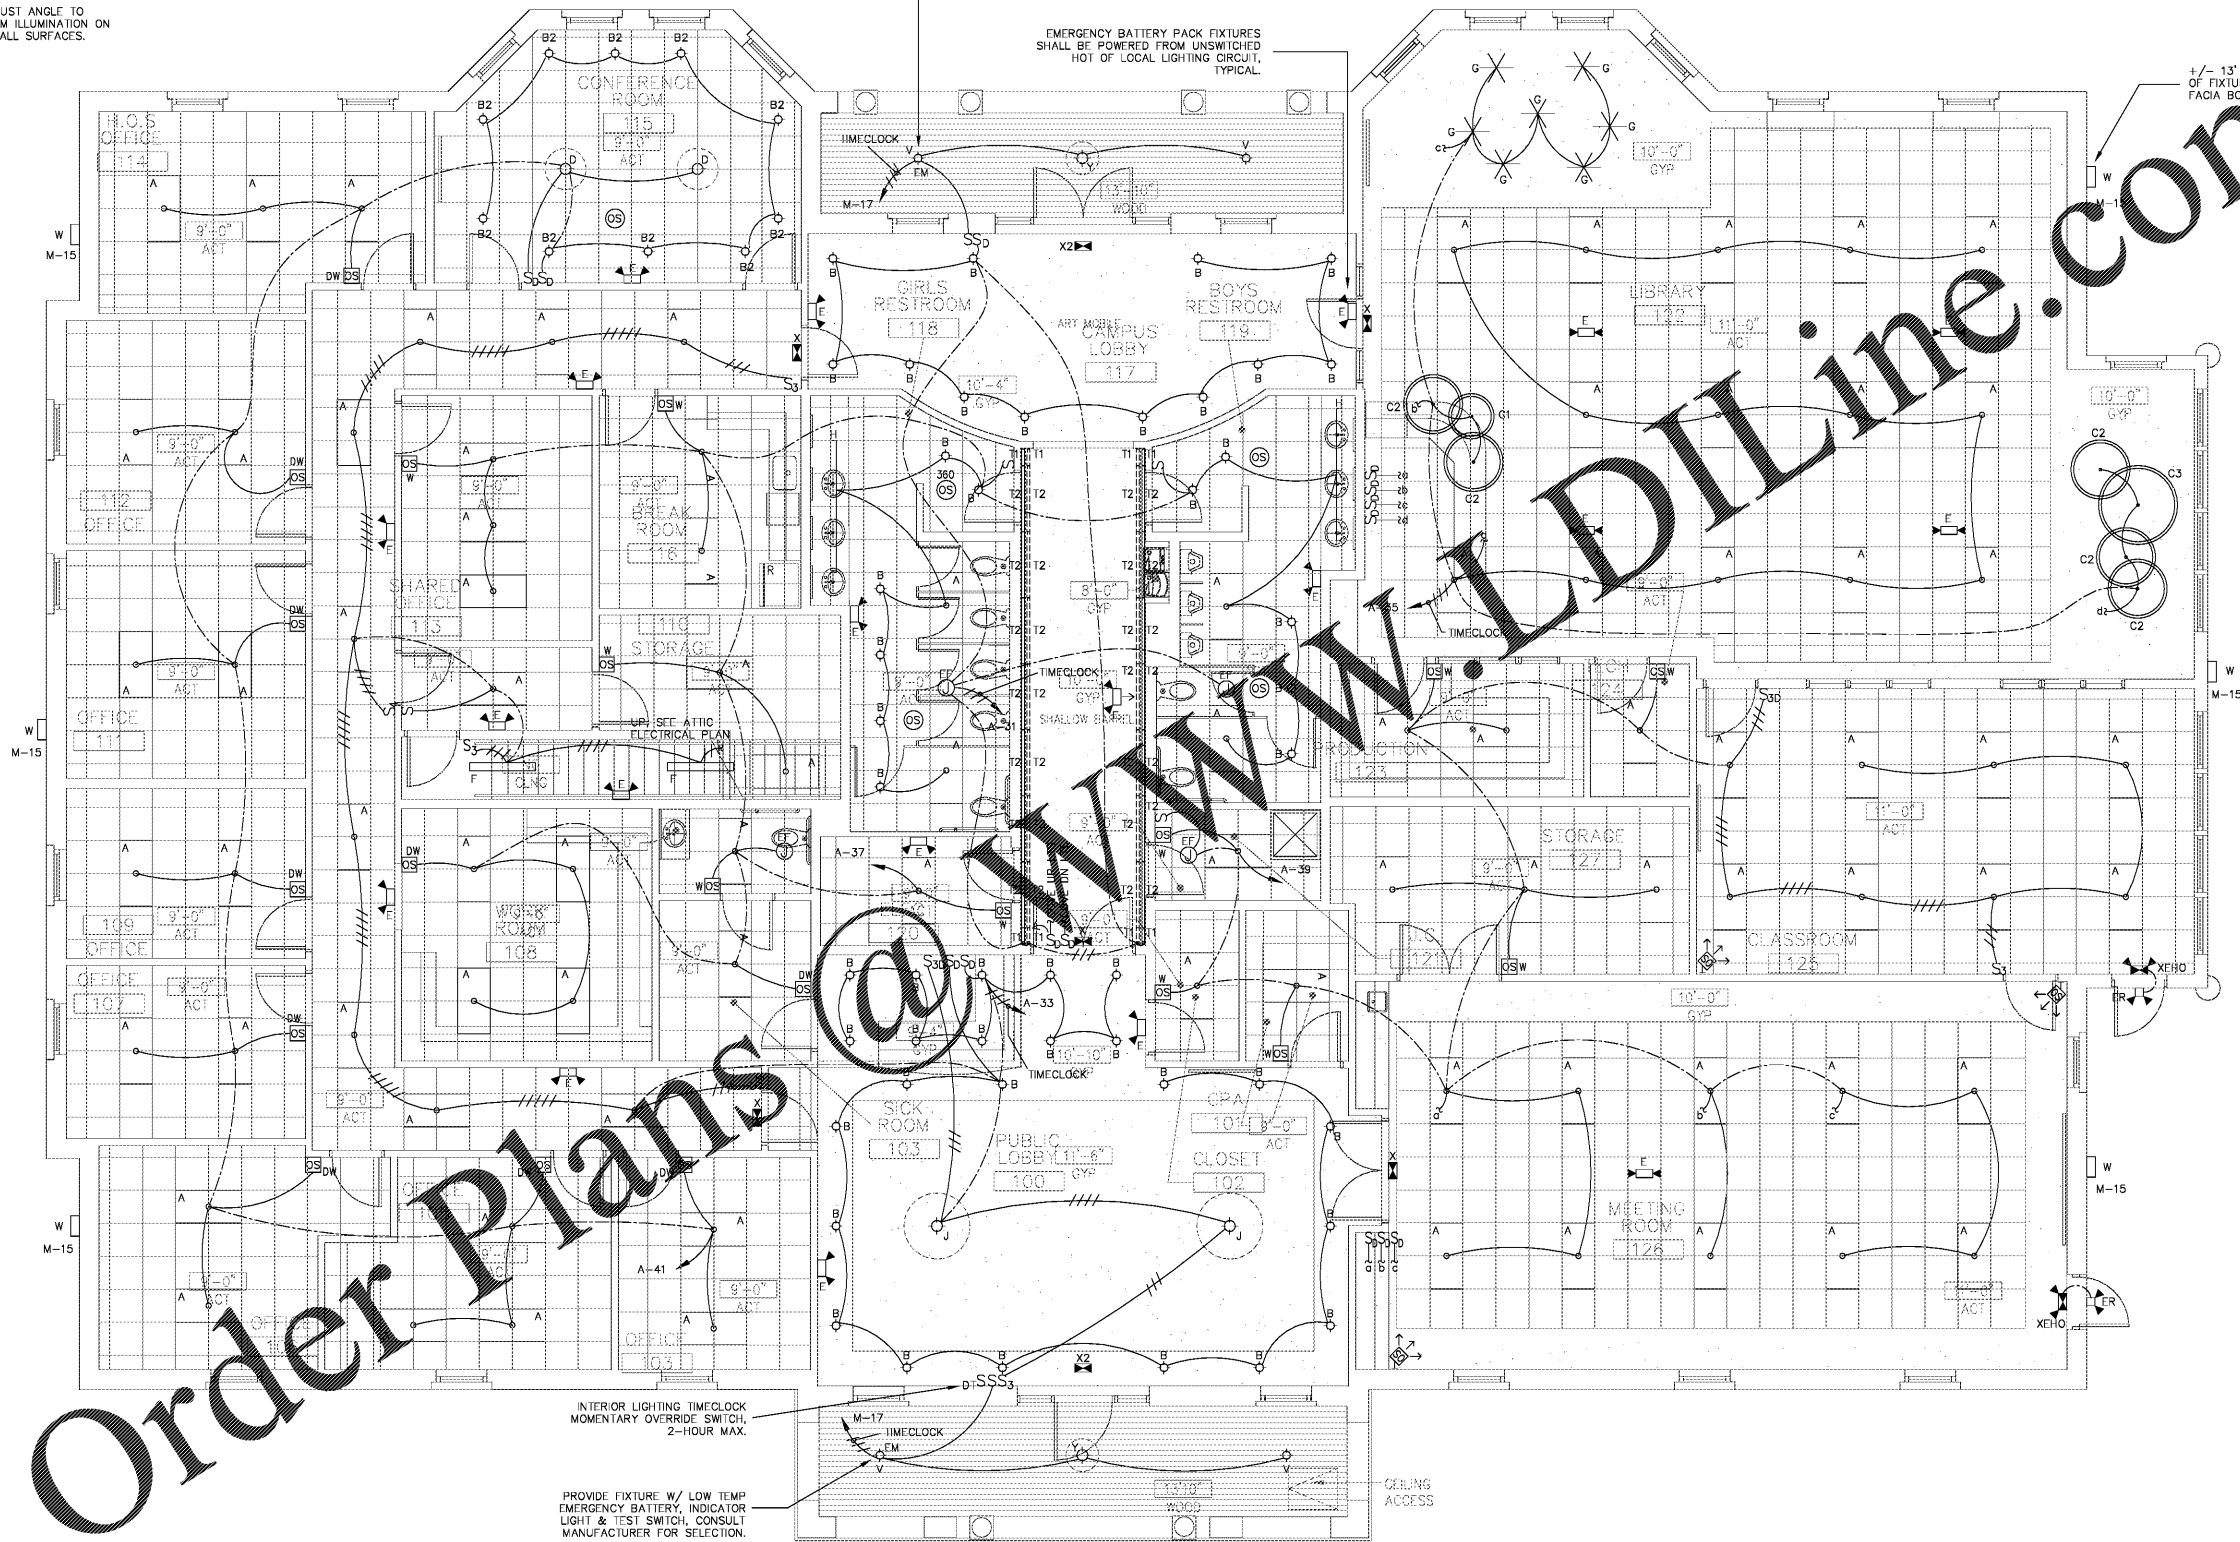

INTERIOR LIGHTING TIMECLOCK  
MOMENTARY OVERRIDE SWITCH,  
2-HOUR MAX.

PROVIDE FIXTURE W/ LOW TEMP  
EMERGENCY BATTERY, INDICATOR  
LIGHT & TEST SWITCH, CONSULT  
MANUFACTURER FOR SELECTION.

POLE LIGHT, SEE ARCHITECTURAL  
SITE PLAN FOR LOCATION, TYP.

M-15



**LIGHTING PLAN**

SCALE: 3/16" = 1'-0"



**EUBANKS**  
ENGINEERING PC  
**HUMPHREY**  
ARCHITECTS PC  
Greensboro, NC  
Shirley R. Humphrey, P.E.  
Shirley R. Humphrey, P.E.  
336.778.0053  
336.778.0053

NC FIRM LICENSE: C-2272



TEAM  
FREYALDENHOVEN  
FREYALDENHOVEN  
ARCHITECTS & PLANNERS, LLP

100 NORTH GREENE STREET  
SUITE 100  
GREENSBORO, NC 27401  
TEL 336.273.0101  
FAX 336.273.0141

CANTERBURY SCHOOL  
P. DAVID BROWN LIBRARY AND  
ADMINISTRATION BUILDING  
5400 OLD LAKE JEANETTE RD  
GREENSBORO, NORTH CAROLINA

DATE  
30JAN20

EHEPC PROJECT #  
1969

REVISIONS

SHEET

**E-4**

OF 6