



1 PARTIAL ALTERNATE MEZZANINE LEVEL PLUMBING PLAN
SCALE: 1/8" = 1'-0"

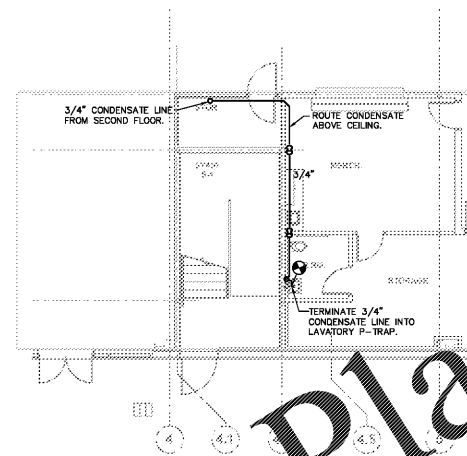

2 PARTIAL ALTERNATE FIRST LEVEL PLUMBING PLAN
SCALE: 1/8" = 1'-0"

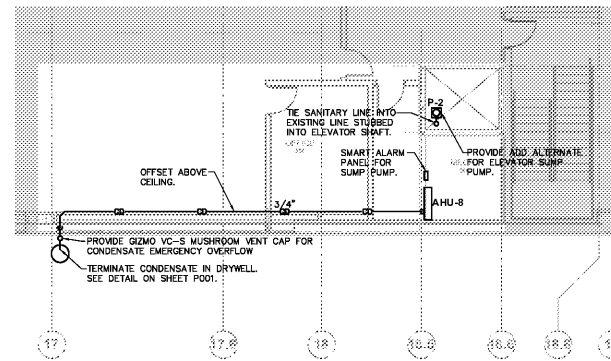

3 PARTIAL ALTERNATE FIRST LEVEL PLUMBING PLAN
SCALE: 1/8" = 1'-0"

Order Plans @ www.LDILine.com



3371 Peachtree Rd NE, Suite 400
Atlanta, Georgia 30326
404.973.0801

PROMUS
SCOTT MERIWETHER, P.E.
GEORGIA LICENSE #10780

4245 LAND RD
BALL GROUND, GA 30107
PROJECT MANAGER: SCOTT MERIWETHER
PHONE: 478.346.5143

LP Indoor Pavilion, LLC
Managed by LakePoint Land, LLC

755 Highway 293
Emerson, GA 30137



RENOVATIONS TO
LAKEPOINT SPORTS
PAVILION
MEZZANINE
755 Highway 293
Emerson, GA 30137

PROJECT NUMBER
19016.00



THIS DRAWING IS THE EXCLUSIVE PROPERTY OF THE ARCHITECTS
AND MAY NOT BE REPRODUCED OR USED WITHOUT THEIR WRITTEN
AUTHORIZATION AND PERMISSION.

COPYRIGHT © 2017 COLLINS COOPER CARUSI ARCHITECTS, INC.

100% CONSTRUCTION DOCUMENTS 11.15.19

DESIGNED FOR P&P 01.15.20

NOTE: READ THE SPECIFICATIONS
THIS SET OF DRAWINGS AND SPECIFICATIONS DEFINE
PROJECT SCOPE AND CONTRACT REQUIREMENTS.
INDIVIDUAL SHEETS SEPARATED FROM THE SET MAY
NOT ADEQUATELY REFLECT ALL INFORMATION NEEDED
TO SUITABLY COVER CERTAIN ITEMS. DO NOT
SEPARATE THIS SET OF DRAWINGS INTO INDIVIDUAL
SHEETS.

SHEET TITLE
PROPOSED ALTERNATE
MEZZANINE LEVEL
PLUMBING PLAN
P-201A