

DESIGN BY OTHERS FOR REFERENCE ONLY

**CRAIG A. SCHNEIDER, AIA**  
ARCHITECT  
1736 East Sandstone, Suite 417  
Springfield, Missouri 65804  
e-mail: architect@asterlyshelbert.com  
417.862.0558  
Fax: 417.862.3265

**PROJECT:**  
NEW O'REILLY AUTO PARTS STORE  
290 DEACON ROAD  
FREDERICKSBURG, VA #4  
**GRIDPOINT EMS**

**O'Reilly AUTO PARTS**  
CORPORATE OFFICES  
233 SOUTH PATTERSON  
SPRINGFIELD, MISSOURI 65802  
(417) 862-2674 TELEPHONE

COMM # 4251  
DATE: 11.02.18  
REVISION DATE:  
03-25-19, 05-30-19

EM1.0

O'REILLY PREFERRED ONE LINE DIAGRAM

5305 VALLEY PARK DRIVE SUITE # 2 - ROANOKE, VA 24019


**GRIDPOINT CONTACT**  
PLEASE CONTACT GRIDPOINT INSTALLATION MANAGEMENT @ 866-896-8965 FOR INSTALLATION CONTACT BASED ON THE STORE LOCATION. EMAIL: SUPPORT@GRIDPOINT.COM

REV	DESCRIPTION:	DATE:	BY:
0	EM 1.0 CREATED	10/1/2018	DC
1	ADDED GP CONTACT AND OTHER NOTES SECTIONS	2/7/2019	DC
2	CORRECTED MOTION SENSOR POWER TO 24VDC	5/1/2019	DC

**SHEET TITLE:**  
FULL SYSTEM MINUS LIGHTING/MOTION SENSORS  
**FILE NAME:**  
O'REILLY PREFERRED ONE LINE DIAGRAM  
**DATE:** 5/1/2019 **DRAWN BY:** DAVID COLWELL  
**SHEET NO.:**

**EM 1.0**

05-30-19  
SHEET CHANGED IN ITS ENTIRETY.

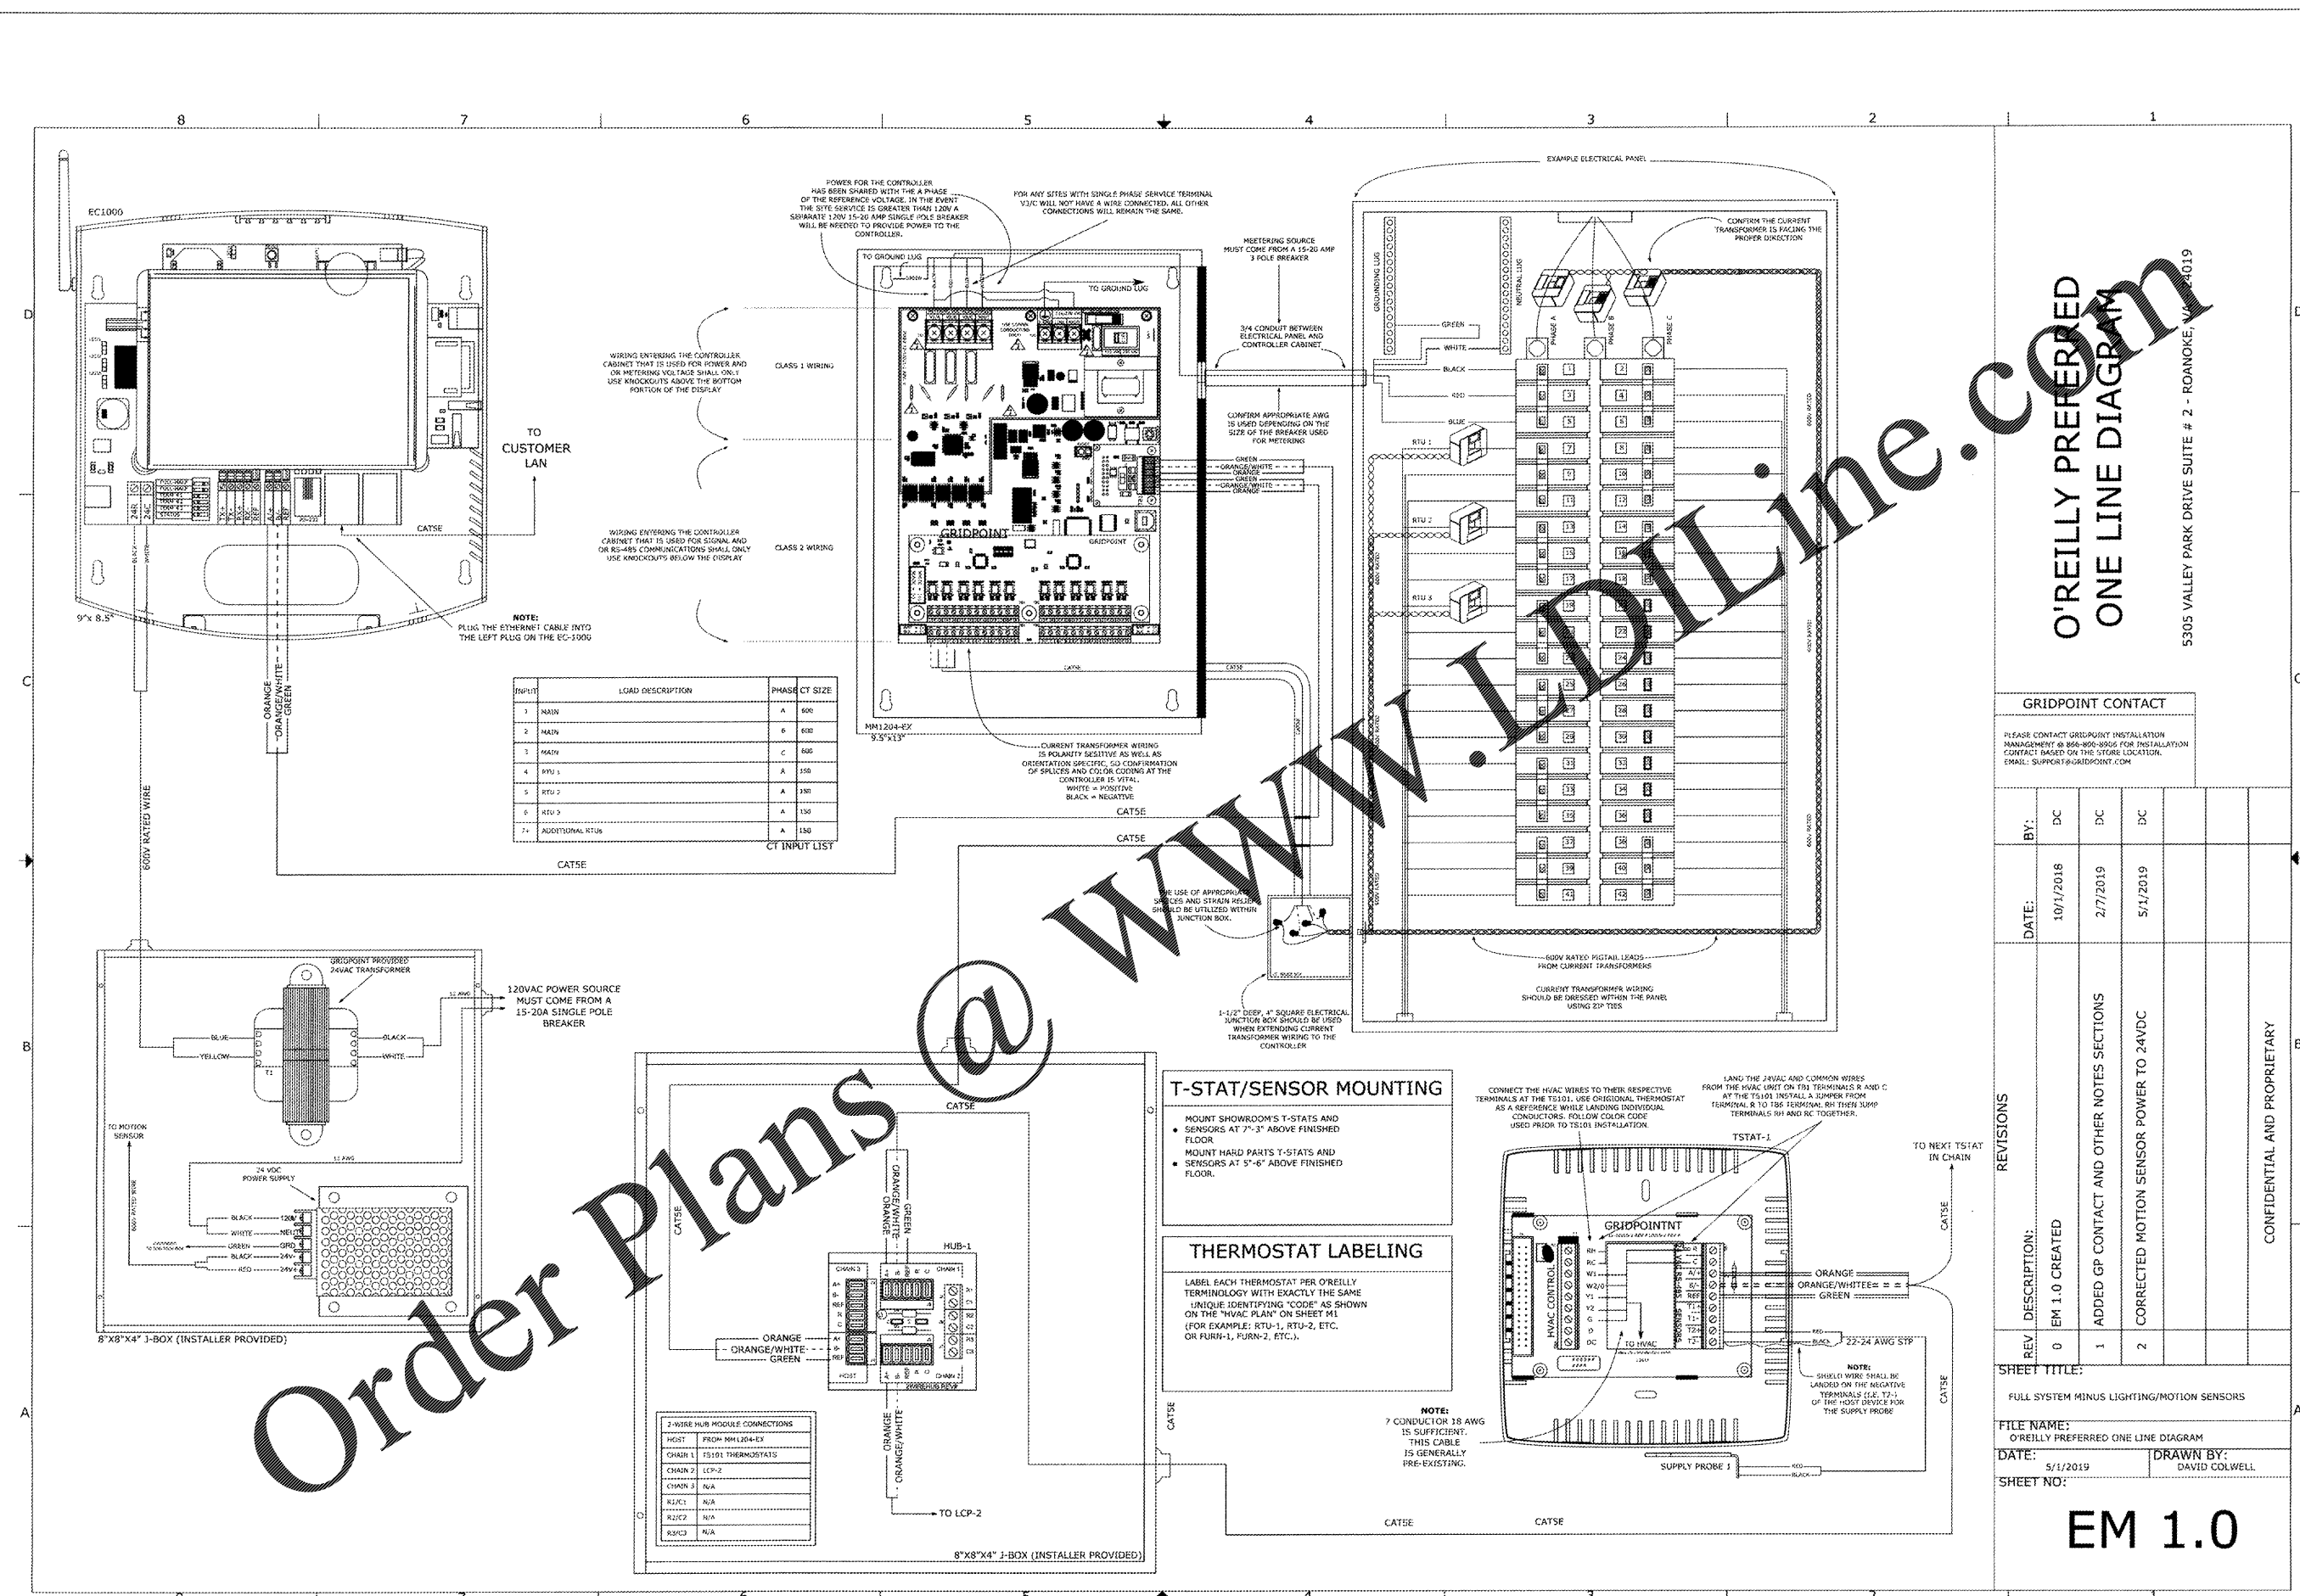

Order Plans @ WWW.IDLine.com

DESIGN  
DATE: 2.1.2018

© COPYRIGHT 2019-2020 - DESIGNS, DRAWINGS AND SPECIFICATIONS ARE INSTRUMENTS OF SERVICE AND ARE THE PROPERTY OF THE DESIGN PROFESSIONAL. REPRODUCTION PROHIBITED WITHOUT THE EXPRESSED WRITTEN CONSENT OF THE DESIGN PROFESSIONAL.