


John Franz Architect
 ARCHITECTURE, INTERIOR ARCHITECTURE, PLANNING (817) 277-8678
 405 INTERNATIONAL PLAZA, SUITE 100 FORT WORTH, TEXAS 76104

SHELL BUILDING
 920 STRICKLAND BRIDGE
 FAYETTEVILLE, NORTH CAROLINA 28304

Revisions:

File Name: 19033
 Project No: 19033
 Date: 04/16/19
 Drawn By:
 Checked By:

SHEET
PH101
 PHOTOMETRIC
 SITE PLAN

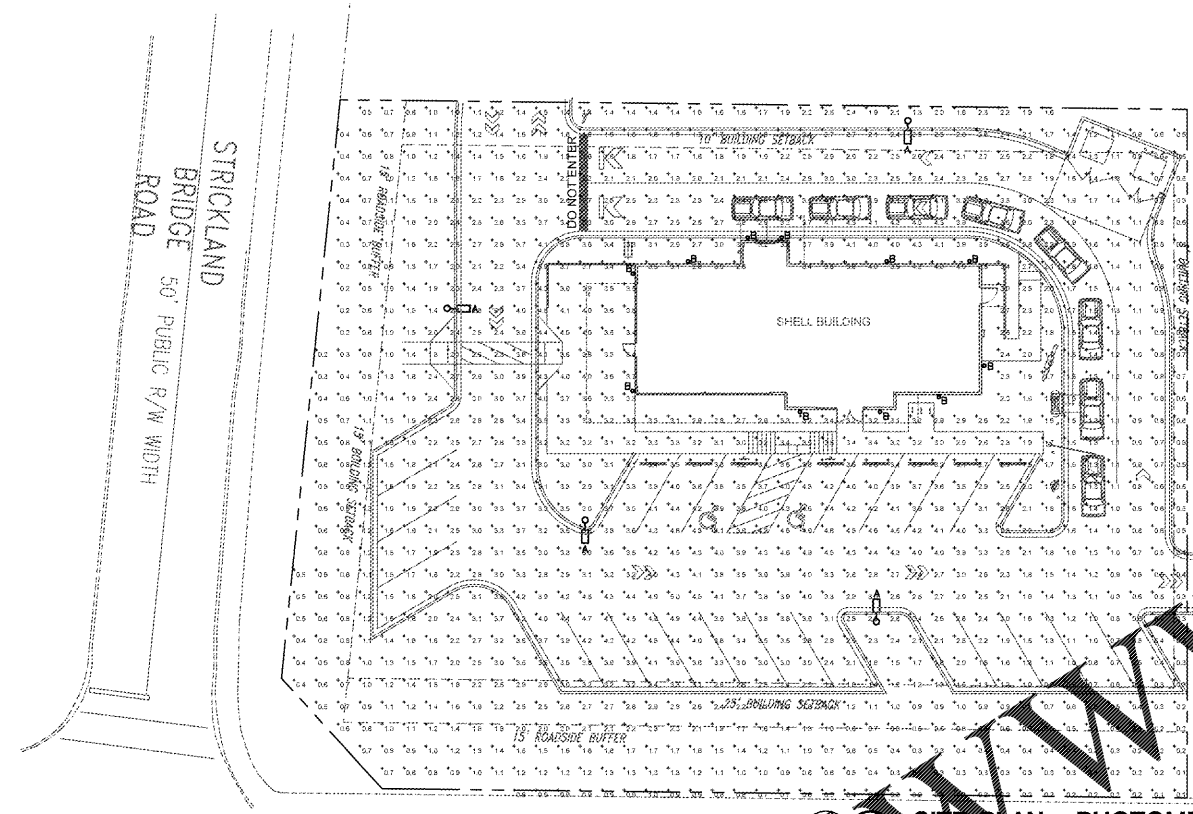

1 SITE PLAN - PHOTOMETRICS
 SCALE: 1" = 20'-0"

Statistics						
Description	Symbol	Avg	Max	Min	Max/Min	Avg/Min
Calc Zone #1	+	2.1 fc	5.0 fc	0.1 fc	50.0:1	21.0:1

Schedule											
Symbol	Label	Quantity	Manufacturer	Catalog Number	Description	Lamp	Number Lamps	Filename	Lumens Per Lamp	Light Loss Factor	Wattage
○	A		TECH LIGHTING SOLUTIONS	EAL503_H4AH740_	EAL503 EVOLVE LED AREA	LED	1	EAL503_H4AH740_IES	19301	1	140
		11	TECH LIGHTING				1	WINDFALL OUTDOOR FIXTURE.ies	154	1	0

Order Plans @ www.LDILine.com

CONTRACTOR SHALL COORDINATE
 MEP DRAWINGS WITH ALL OTHER
 DISCIPLINES

AOS JOB #: 25669-002-19

Gregory C. Speer
 5020 Tennyson Pkwy. - Plano, TX 75024
 Phone (214) 432-3030 / Fax (214) 618-8191