




John Frank Architect
 ARCHITECTURE-INTERIOR ARCHITECTURE-PLANNING (817) 737-8678
 605 INTERNATIONAL PLAZA, SUITE 100, FORT WORTH, TEXAS 76109

SHELL BUILDING
 1855 CEDAR CREEK ROAD
 FAYETTEVILLE, NORTH CAROLINA 28312

Revisions:
 File Name: 19086
 Project No: 19086
 Date: 10/11/19
 Drawn By:
 Checked By:

PH101
 PHOTOMETRIC
 SITE PLAN

Order Plans @ www.LDLine.com

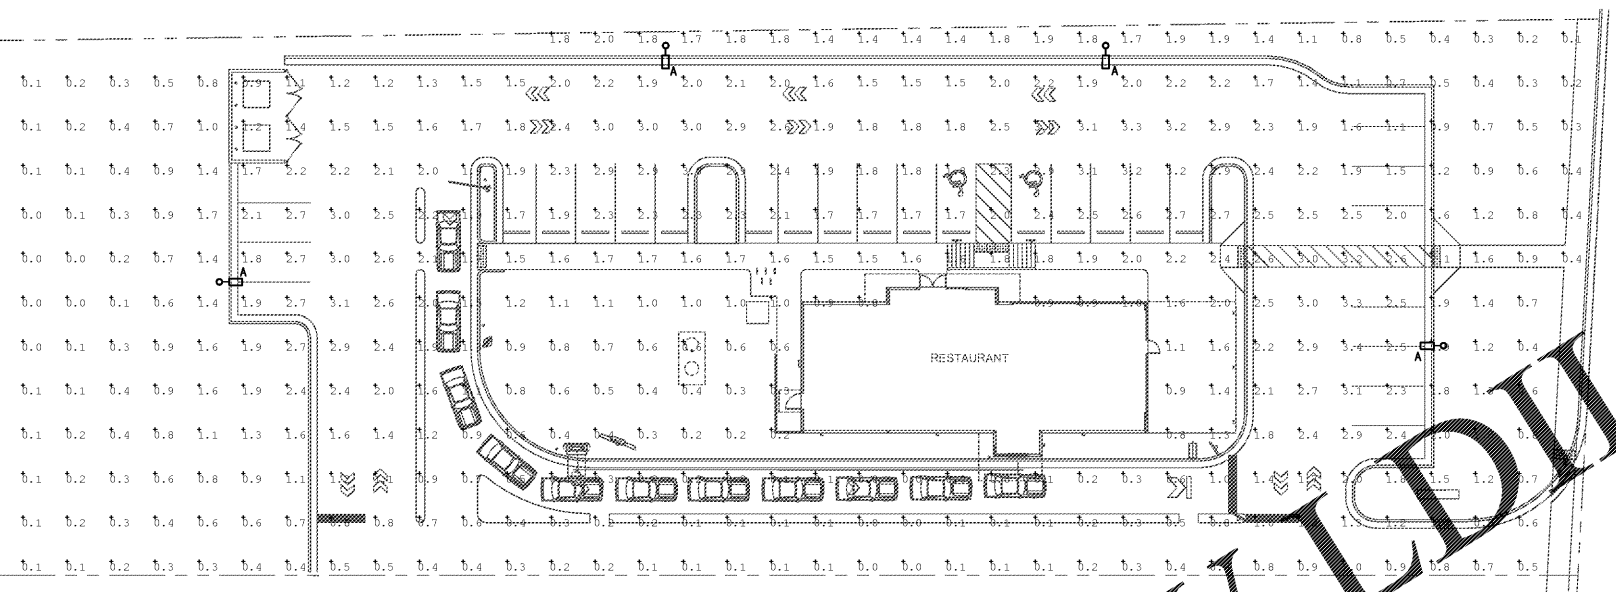

GENERAL LIGHTING NOTES:
 A. THIS LIGHTING PLAN COMPLIES WITH THE CITY OF FAYETTEVILLE CODE OF ORDINANCES CHAPTER 30 DESIGN STANDARDS FOR EXTERIOR LIGHTING.

Luminaire Schedule						
Symbol	Qty	Label	Arrangement	LLF	Description	Total Watts
☐	4	A	SINGLE	0.850	GE/EALS03 H4AH740NDD1DKB2	560

Calculation Summary						
Label	CalcType	Units	Avg	Max	Min	g/Min
Object 1 Top	Illuminance	Fc	1.2	3.4		N.A.

1 SITE PLAN - PHOTOMETRICS
 SCALE = 20'-0"

Gregory C. Speer
 5020 Tennyson Pkwy. - Plano, TX 75024
 Phone (214) 432-3030 / Fax (214) 618-8191
 CONTRACTOR SHALL COORDINATE
 MEP DRAWINGS WITH ALL OTHER
 DISCIPLINES

AOS JOB #: 2568-009-19