


- FIRE SPRINKLER DEMOLITION NOTES**
- FIRE SPRINKLER CONTRACTORS SCOPE OF WORK SHALL INCLUDE:
 - SHUT DOWN AND DRAINING OF EXISTING SYSTEM.
 - DEMOLITION OF EXISTING SPRINKLERS, PIPING, HANGERS, ETC. WHERE INDICATED ON THE PLANS.
 - FIRE SPRINKLER CONTRACTOR SHALL BE RESPONSIBLE FOR REPLACING ANY EXISTING PIPE OR FITTINGS TO REMAIN THAT ARE DAMAGED AS A RESULT OF THEIR WORK AT NO COST TO THE OWNER.

SYMBOL KEY

	EXISTING PIPING TO REMAIN
	EXISTING PIPING TO BE DEMOLISHED
	NEW PIPING
	EXISTING SPRINKLER AND ARM OVER TO BE DEMOLISHED BACK TO OUTLET ON BRANCH LINE UNLESS SHOWN OTHERWISE
	EXISTING BRASS UPRIGHT TO REMAIN VARS55 6SR
	EXISTING CHROME PENDENT TO REMAIN ORDS 6SR
	NEW BRASS UPRIGHT ORDS 6SR
	NEW CHROME PENDENT ON 2-PIECE TELESCOPING ESCUTCHEON ORDS 6SR
	CAPPED OUTLET
	CONNECT TO EXISTING PIPE AND/OR FITTING
	APPROXIMATE CENTER LINE LOCATION OF EXISTING PIPE BELOW METAL DECK ABOVE FINISH FLOOR OR SIZE OF PIPE AS SHOWN HELD TIGHT TO THE BOTTOM OF
	RECOMMENDED CENTER LINE ELEVATION OF NEW PIPE BELOW METAL DECK ABOVE FINISH FLOOR OR SIZE OF PIPE AS SHOWN HELD TIGHT TO THE BOTTOM OF
	PIPE FROM LEFT TO RIGHT AND/OR FROM RIGHT TO LEFT
	EXISTING PIPE
	HEAD LOSS REFERENCE POINT
	FLOOR DRAIN WITH 3/4" HOSE END ADAPTER
	ADJACENT TENANT (NOT IN SCOPE)

SEE SHEET FP2 FOR NOTES, DETAILS, AND SPECIFICATIONS

ALL ARM-OVERS TO NEW SPRINKLERS ARE 1"

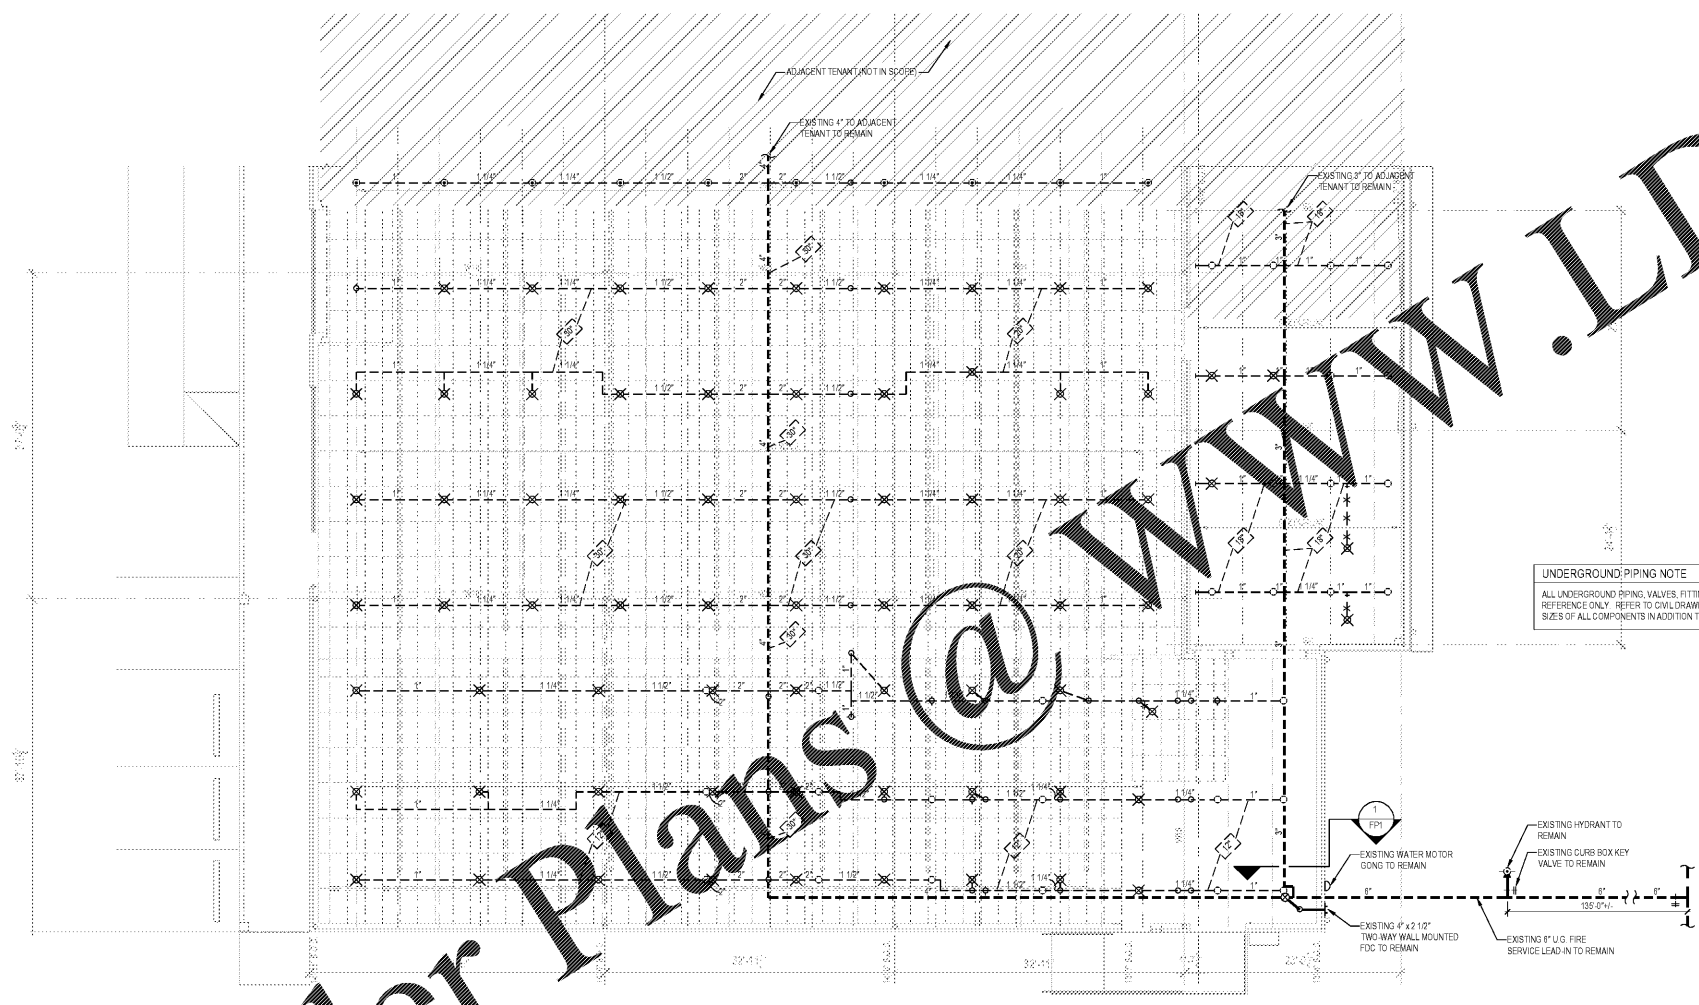

UNDERGROUND PIPING NOTE

ALL UNDERGROUND PIPING, VALVES, FITTINGS, DIMENSIONS, ETC. ARE SHOWN FOR REFERENCE ONLY. REFER TO CIVIL DRAWINGS FOR EXACT LOCATIONS, TYPES, AND SIZES OF ALL COMPONENTS IN ADDITION TO DETAILS OF CONSTRUCTION.

FIRE PROTECTION ENGINEER OF RECORD:
 WILLIAM B. SMITH, PE
 LICENSE NO. 38107
 CODE CONSULTANTS, INC.
 240 WOODLAND PARKWAY, SUITE 200
 ST. LOUIS, MISSOURI 63108-5207
 PHONE: 314.991.8833
 CORPORATE CERTIFICATE OF AUTHORITY NO. 9213



RRMM ARCHITECTS, PC
 1317 Executive Blvd, Suite 200
 Chesapeake, VA 23320
 (757) 622-2828 / fax (757) 622-6883

date: 10/02/20
 project: 201803
 designed: ASR
 drawn: VBS
 checked:

mark: description
 by:
 date:
 reflects:

CODE CONSULTANTS, INC.
 240 WOODLAND PARKWAY, SUITE 200
 ST. LOUIS, MISSOURI 63108-5207
 314.991.8833
 www.codeconsultants.com

FIRE SPRINKLER PLAN - DEMOLITION WORK
 SCALE: 1/8" = 1'-0"
 FIN FLOOR ELEV. 100'-0"

Order Plans @

FAMILY DOLLAR
 FAMILY DOLLAR STORE FDS #791567
 501 TENNESSEE AVE NORTH-PARSONS, TN 38363
 FIRE SPRINKLER PLAN - DEMOLITION WORK

project:
 drawing:

sheet
FPD1