




**DUNWODY/BEELEND,**  
architects, inc.

Web: [www.dunwodybeeland.com](http://www.dunwodybeeland.com)  
Macon, Georgia, Suite 604  
1478 W. 42nd St.  
T 478.742.5321  
F 478.743.6863

Dunwody/Beeland, Architects, Inc.  
This drawing may be utilized only for the purpose of constructing or installing the work shown thereon at the site of the work specified. Any other use of this drawing, including without limitation any reproduction or alteration of this drawing, without prior written approval of Dunwody/Beeland, Architects, Inc. is prohibited.

LEGEND

- 2x4 SURFACE MOUNTED FLAT PANEL LIGHT
- 2x2 SURFACE MOUNTED FLAT PANEL LIGHT
- 4x SURFACE MOUNTED STRAIGHT LIGHT
- RECESSED DOWN LIGHT
- VANITY FIXTURE
- WALL SCONCE
- EXIT LIGHT
- EMERGENCY LIGHT
- EXIT DOOR EMERGENCY LIGHT
- EXIT FAN

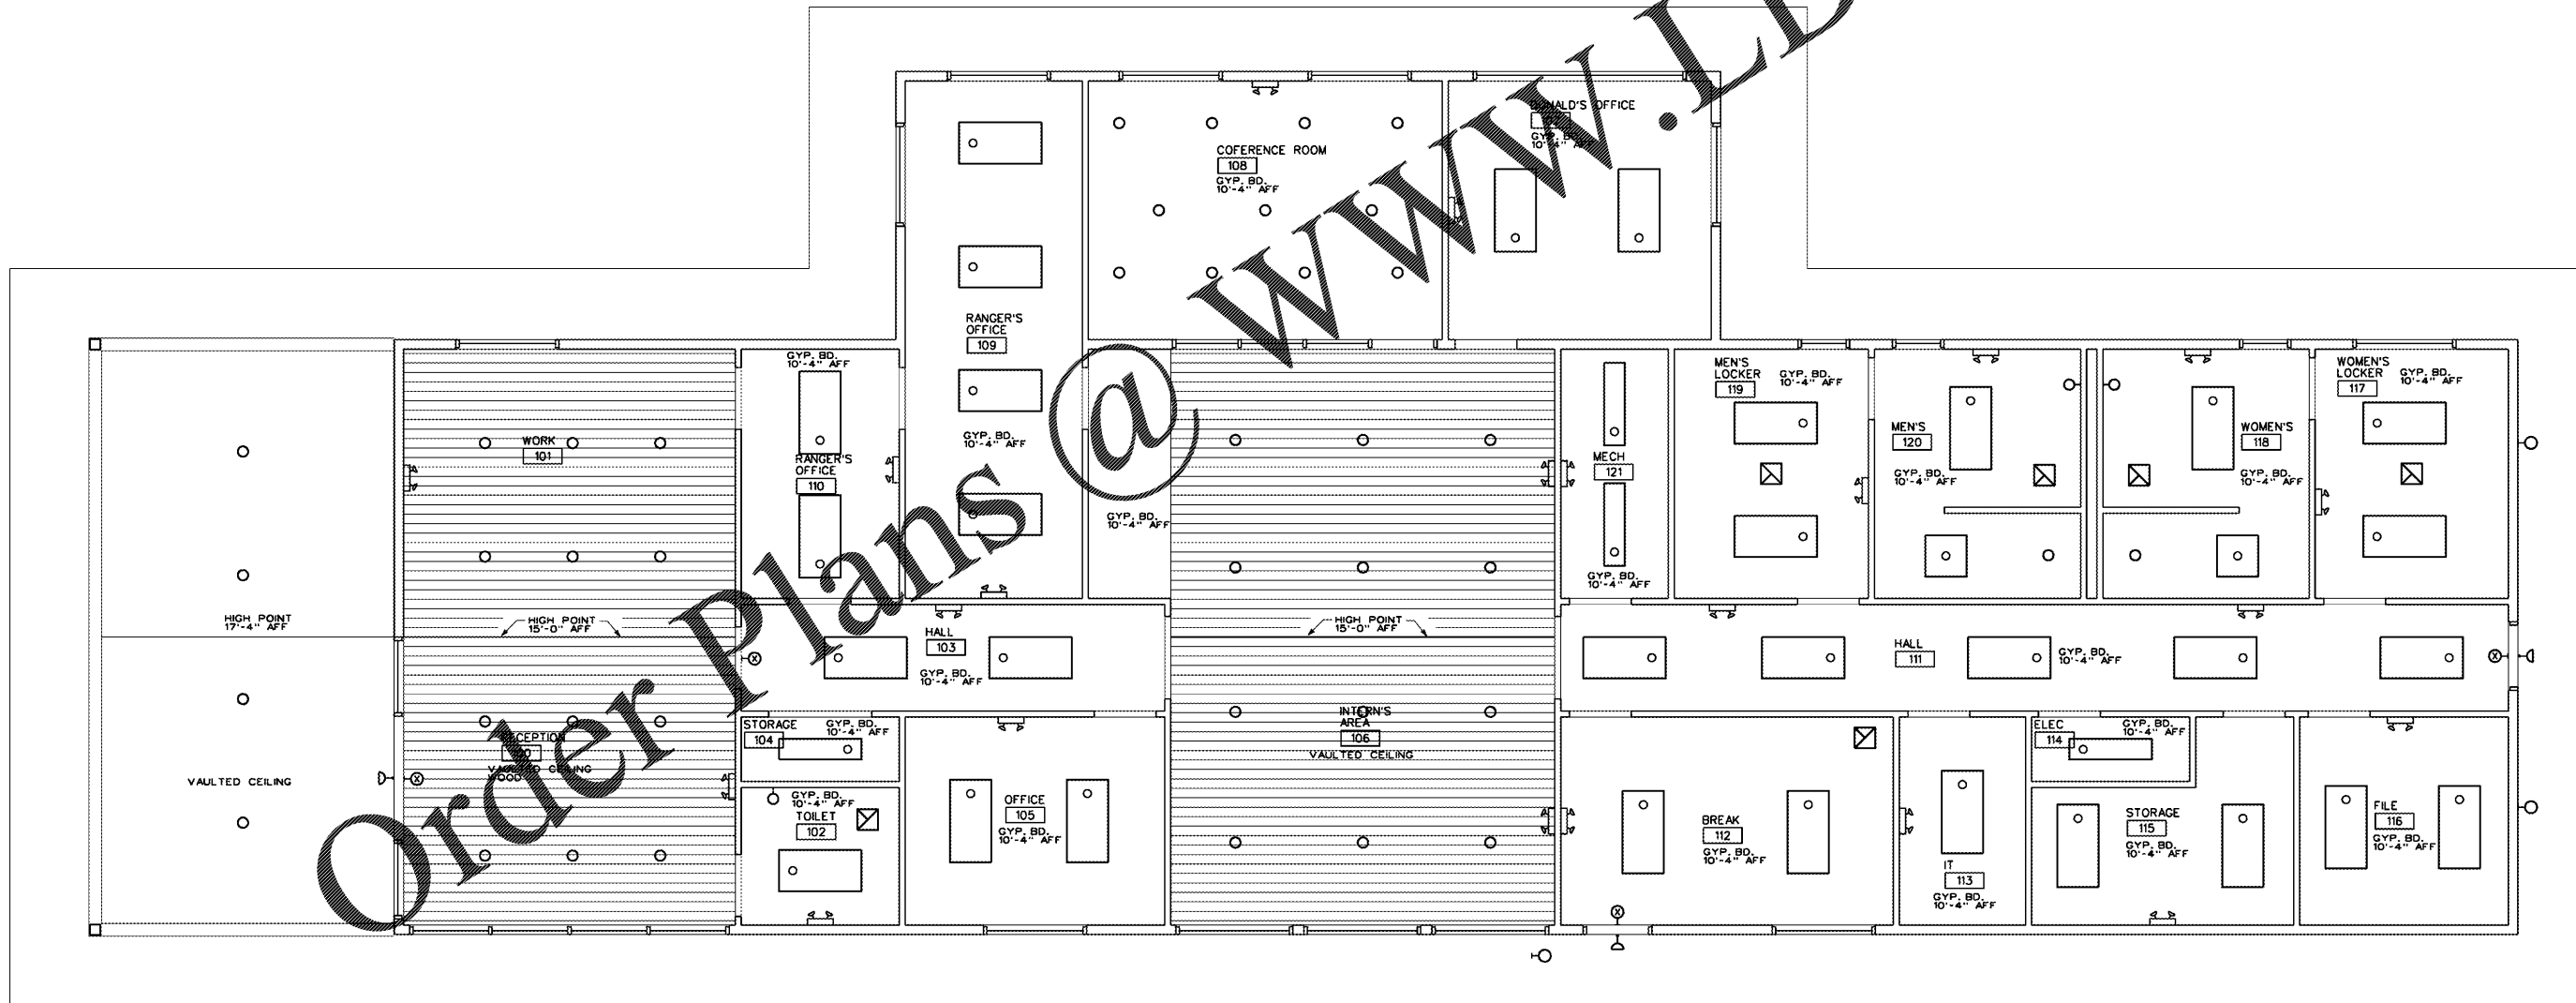

Order Plans @

A NEW RANGER STATION  
AT CLAYSTONE PARK  
FOR MACON-BIBB COUNTY

MOSLEY DIXON ROAD MACON, GEORGIA

Revisions:

Sheet Title:  
Reflected Ceiling Plan

Project #: 1819 Date: 12/20/19

**REFLECTED CEILING PLAN**  
SCALE: 1/4" = 1'-0"

**A9.1**