




DUNWODY/BEELEND,
architects, inc.

Web: www.dunwodybeeland.com
 169 New Street, Suite 604
 Macon, Georgia 31201
 T 478 742 5321
 F 478 743 0863

Dunwody/Beeland, Architects, Inc.
 This drawing may be utilized only for the purpose of constructing or installing the work shown thereon at the site of the work specified. Any other use of this drawing, including without limitation any reproduction or alteration of this drawing, without prior written approval of Dunwody/Beeland, Architects, Inc. is prohibited.

**A NEW RANGER STATION
 AT CLAYSTONE PARK
 FOR MACON-BIBB COUNTY**
 MOSLEY DIXON ROAD MACON, GEORGIA

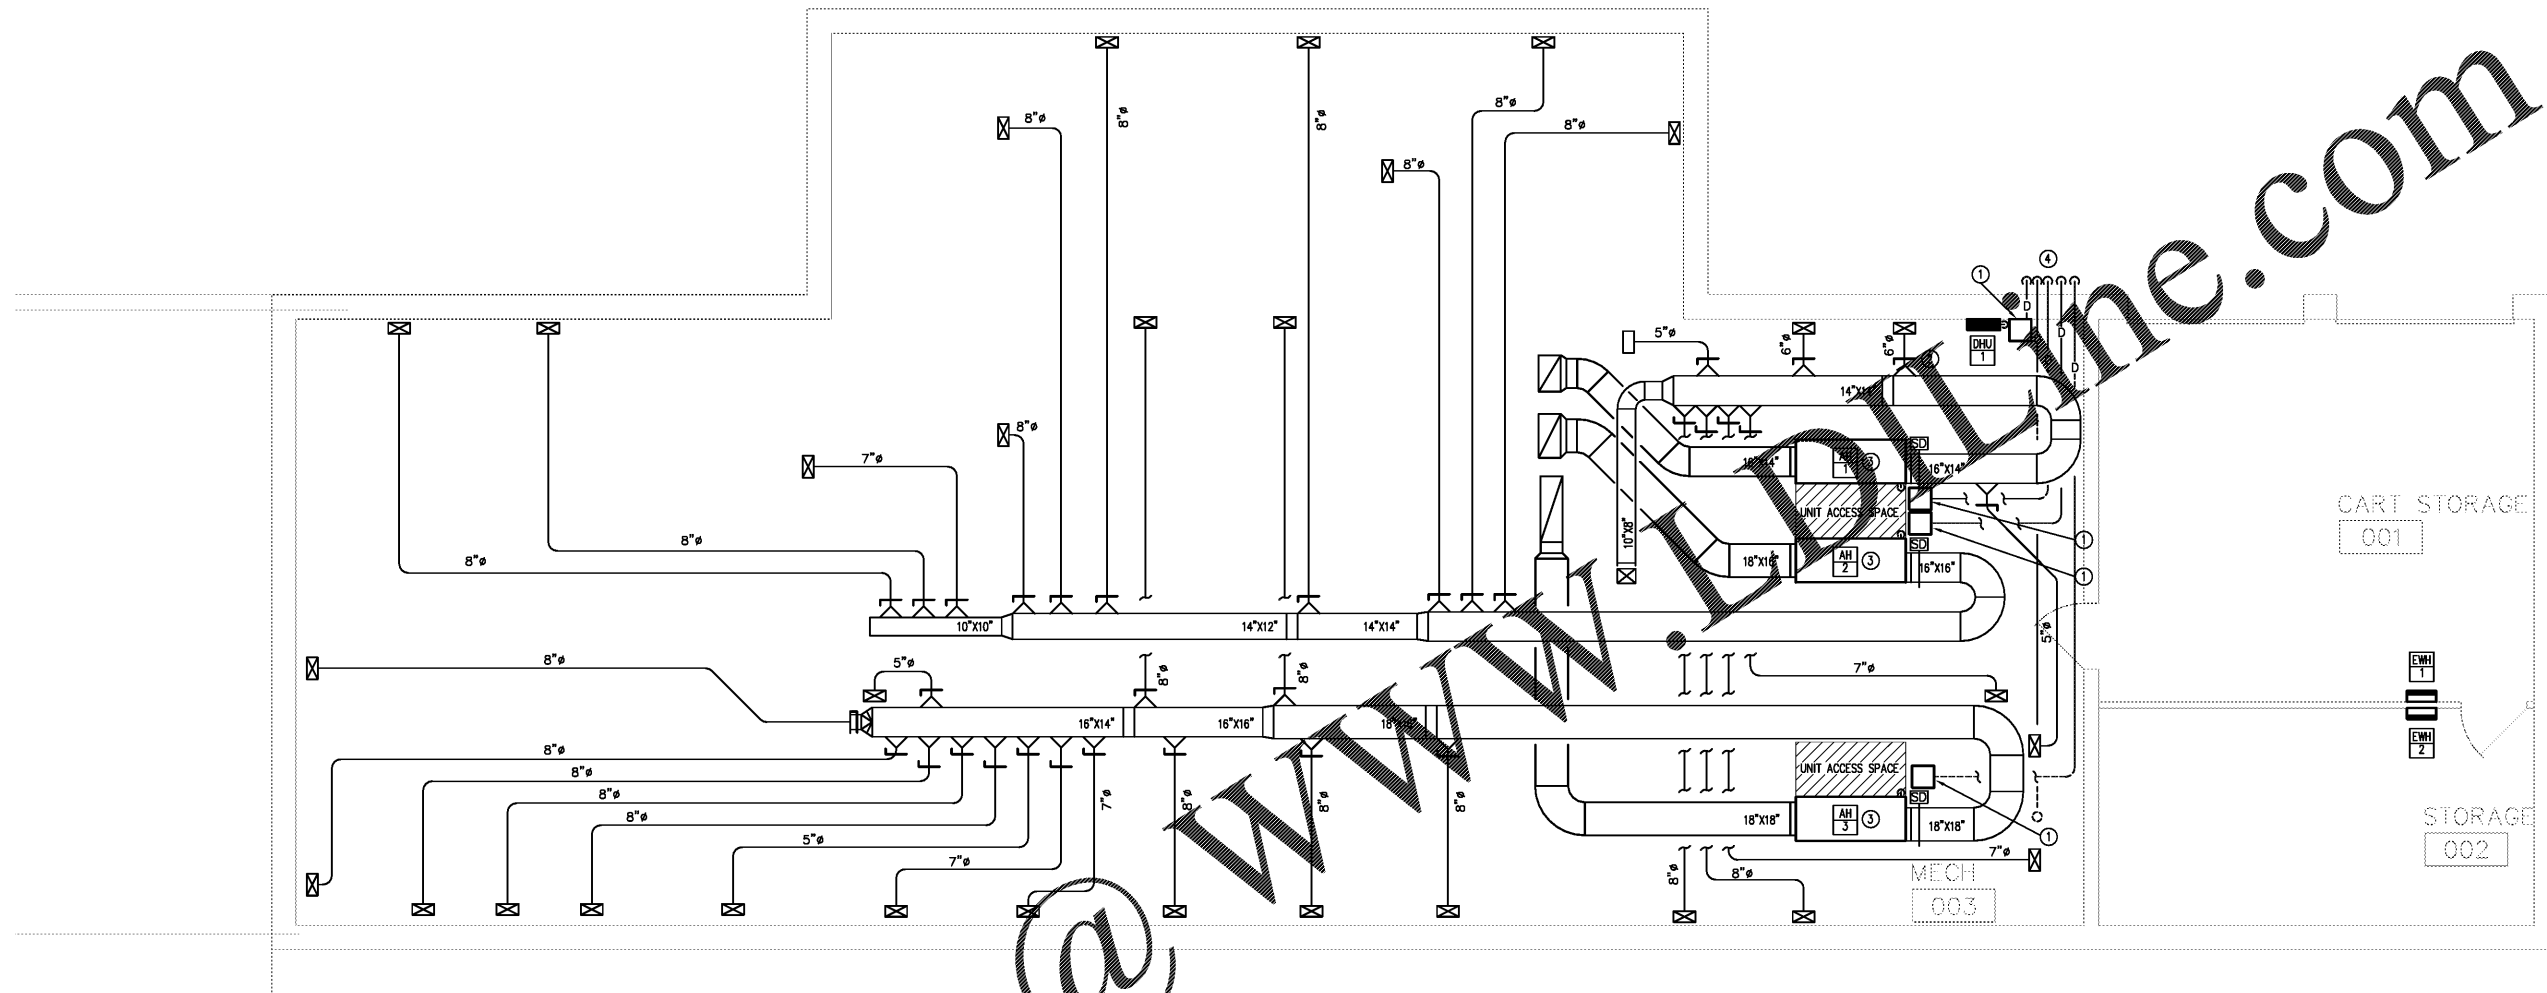

① LOWER LEVEL MECHANICAL PLAN
 SCALE: 1/4"=1'-0"


Order Plans @ www.dunwodybeeland.com

- KEY NOTES (THIS SHEET ONLY):
- ① CONDENSATE PUMP. REFER TO SPECIFICATION.
 - ② TYPICAL MANUAL VOLUME DAMPER.
 - ③ ROUTE REFRIGERANT PIPES TO THEIR RESPECTIVE HEAT PUMPS. PROVIDE OUTSIDE BUILDING ROUTE AND SIZE REFRIGERANT PIPES PER MANUFACTURER'S INSTRUCTIONS.
 - ④ ROUTE CONDENSATE 8" AFF. PROVIDE 1/2" DISCHARGE ELIMINATOR TO DISCHARGE CONDENSATE AWAY FROM WALL. PROVIDE SPLASH BLOCK AT DISCHARGE.

Revisions:	

Sheet Title:
 RANGER STATION
 LOWER LEVEL
 MECHANICAL PLAN

Project #: 1819 Date: 12/23/19

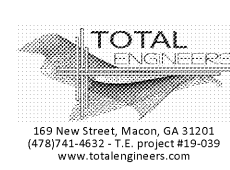

M1.1RS