



DUNWODY/BEELEND,
architects, inc.

Macon
300 Mulberry Street, Suite 604
31201
T 478.742.5321
F 478.743.0863
Web:
www.DunwoodyBeeland.com

Dunwoody/Beeland, Architects, Inc.
This drawing may be utilized only for the
purpose of constructing or installing the
work shown thereon at the site of the work
specified. Any other use of this drawing,
including without limitation any
reproduction or alteration of this drawing,
without prior written approval of
Dunwoody/Beeland, Architects, Inc. is
prohibited.


A NEW RANGER STATION
AT CLAYSTONE PARK
FOR MACON-BIBB COUNTY
MOSLEY DIXON ROAD MACON, GEORGIA

Revisions:


Sheet Title:
RANGER STATION
LOWER LEVEL
PLUMBING PLAN

Project #: 1819 Date: 12/23/19

P1.1RS

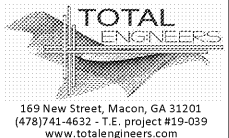

169 New Street, Macon, GA 31201
(478)741-4632 - T.E. project #19-039
www.totalengineers.com

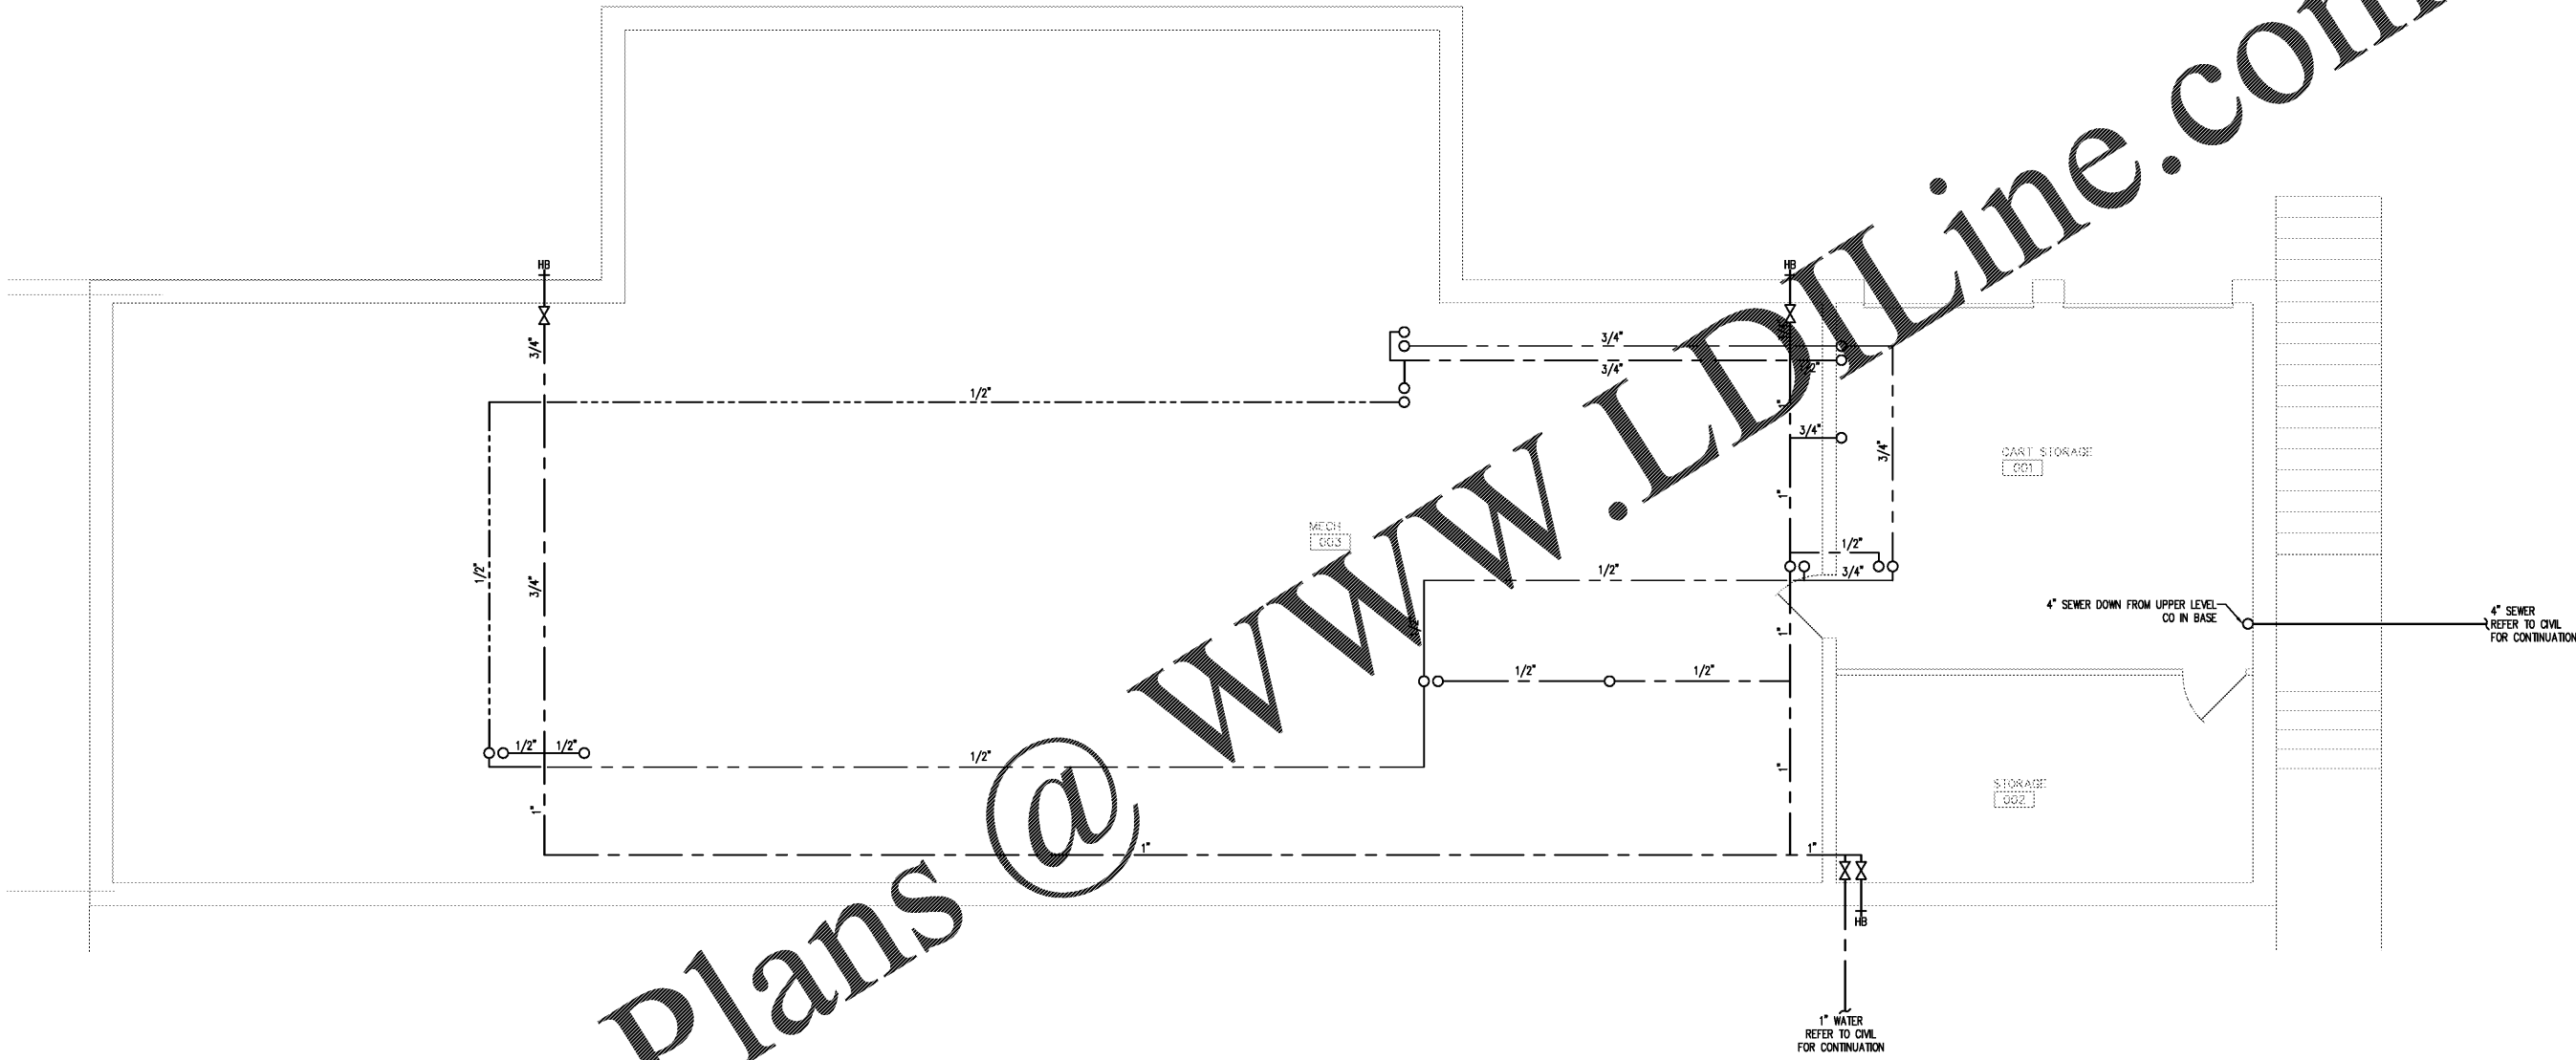

1 LOWER LEVEL PLUMBING PLAN
SCALE: 1/4"=1'-0"

Order Plans @ WWW.LDILine.com