




DUNWODY/BEELEND,
architects, inc.

Macon
300 Mulberry Street, Suite 604
Macon, GA 31201
T: 478.742.5321
F: 478.743.0863
Web: www.DunwodyBeeland.com

Dunwody/Beeland, Architects, Inc.
This drawing may be utilized only for the purpose of constructing or installing the work shown thereon at the site of the work specified. Any other use of this drawing, including without limitation any reproduction or alteration of this drawing, without prior written approval of Dunwody/Beeland, Architects, Inc. is prohibited.

**A NEW RANGER STATION
AT CLAYSTONE PARK
FOR MACON-BIBB COUNTY**
MOSLEY DIXON ROAD MACON, GEORGIA

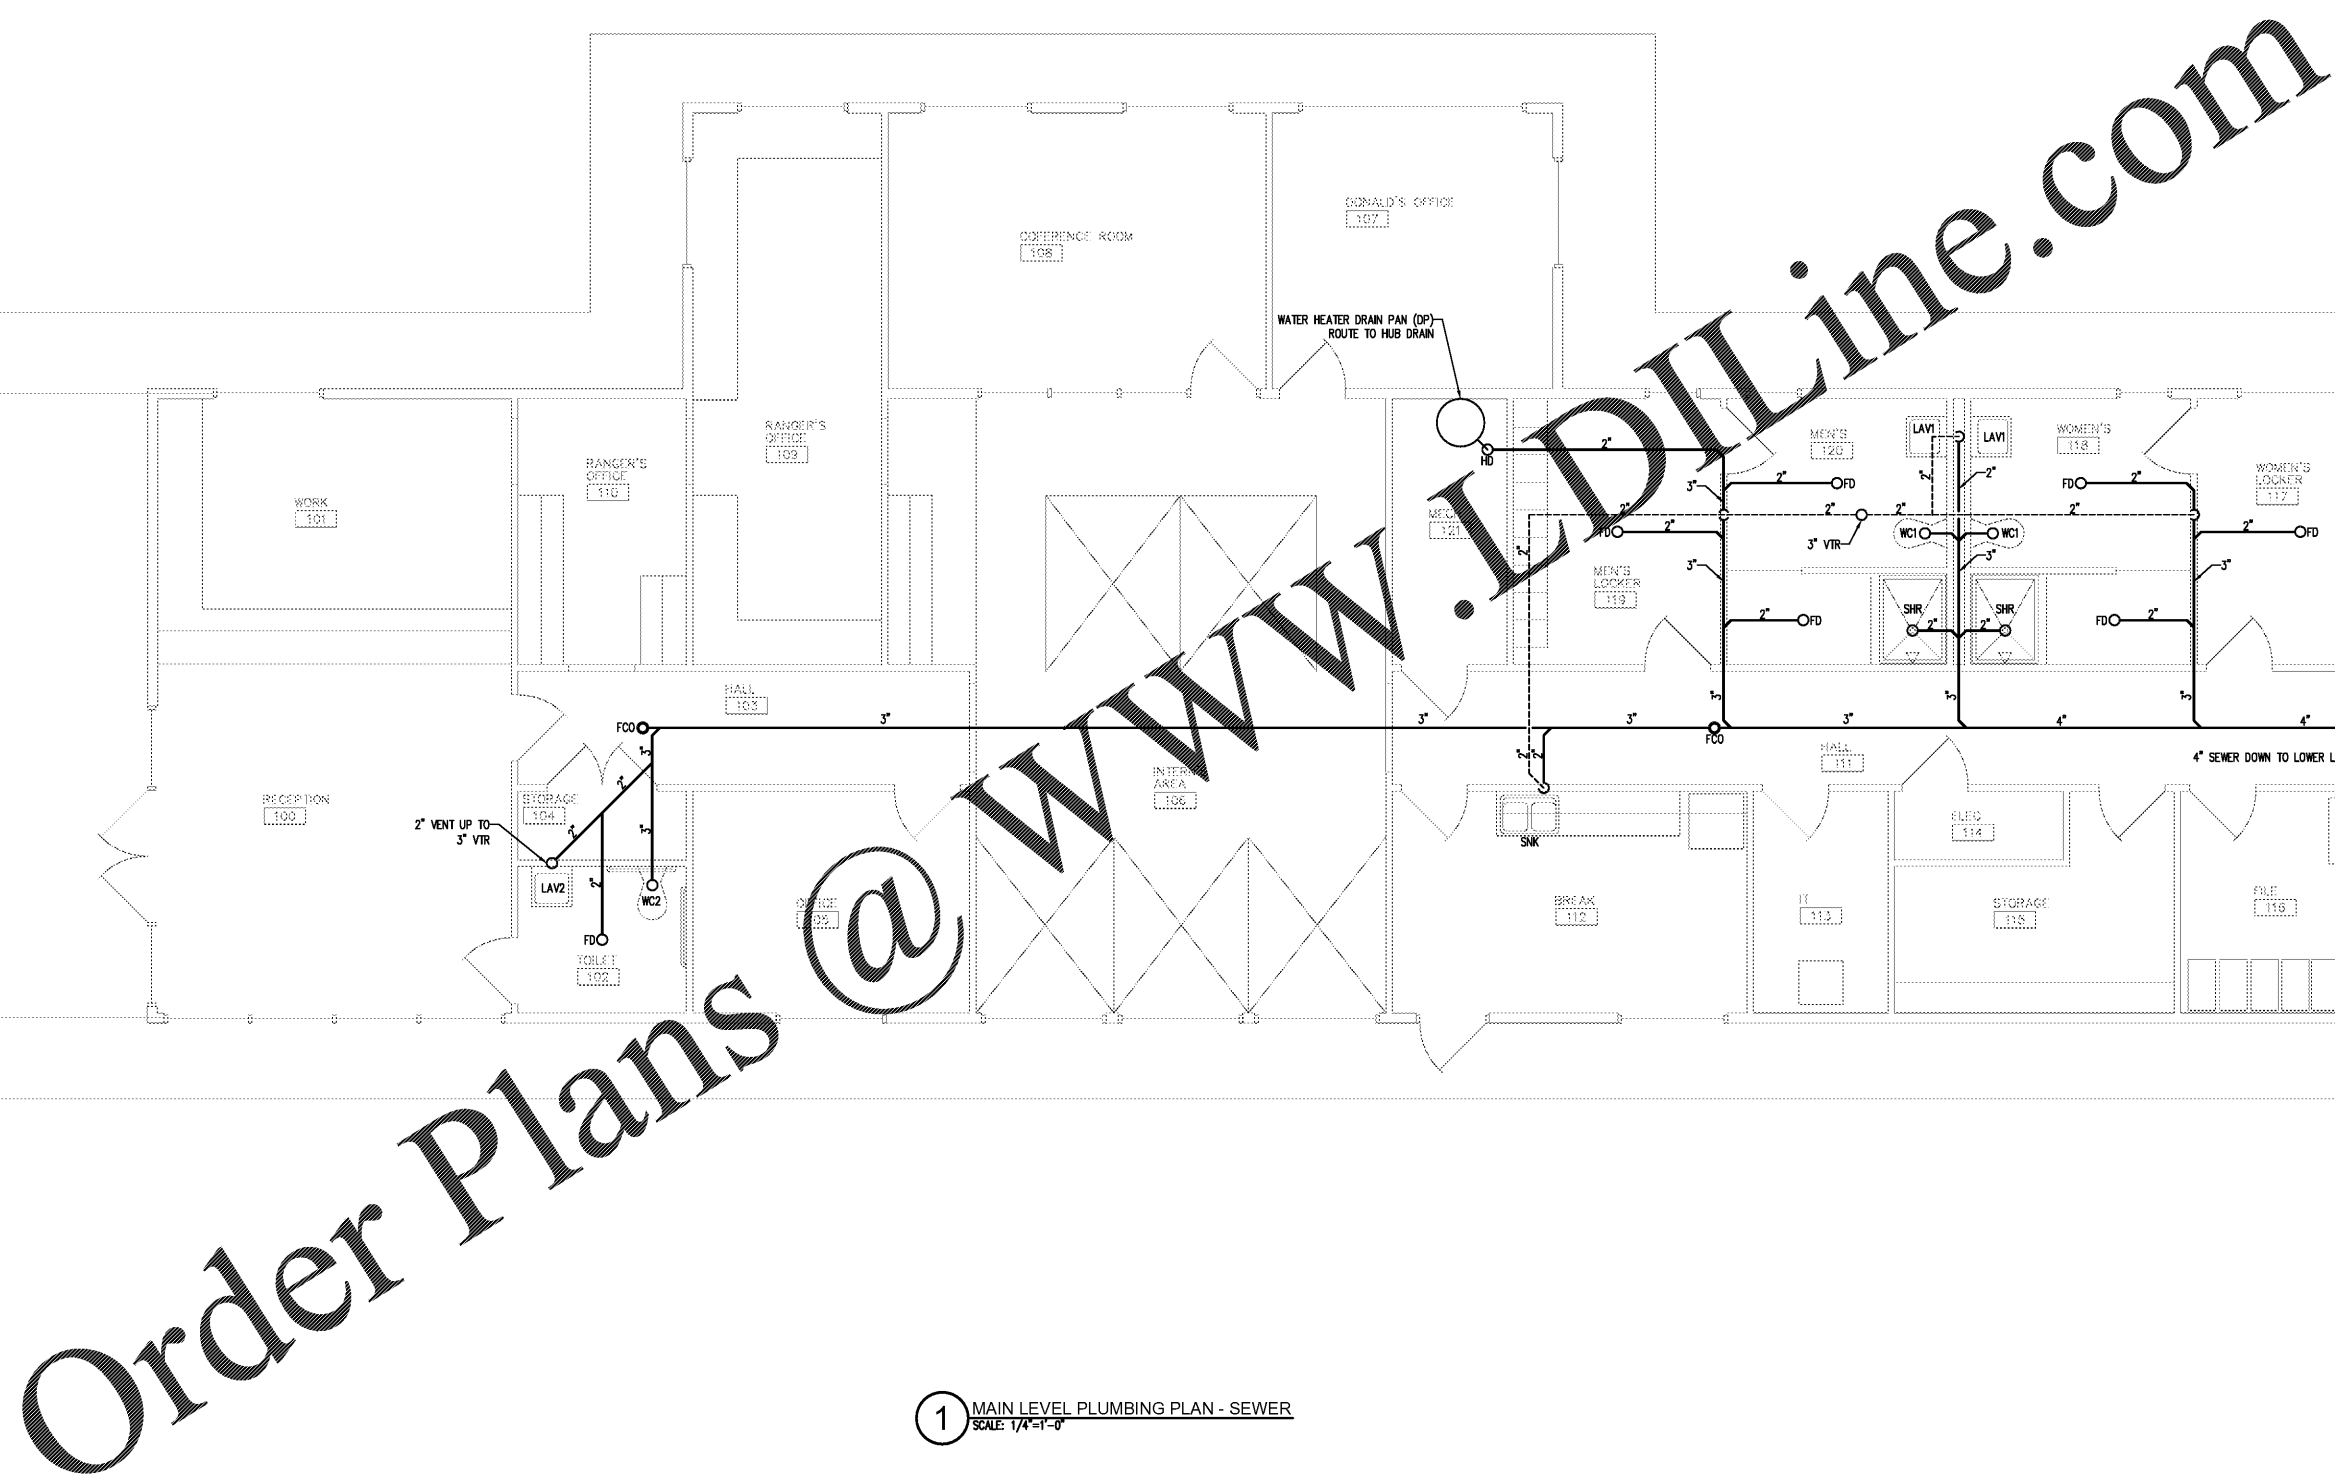


1 MAIN LEVEL PLUMBING PLAN - SEWER
SCALE: 1/4"=1'-0"

Revisions:

Sheet Title:
RANGER STATION
MAIN LEVEL
PLUMBING PLAN -
SEWER

Project #: 1819 Date: 12/23/19

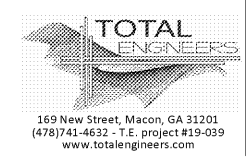

P2.1RS