



DUNWODY/BEELEND,
architects, inc.

Macon
300 Mulberry Street, Suite 604
Macon, GA 31201
T 478.742.5321
F 478.743.0863
Web: www.DunwodyBeeland.com

Dunwody/Beeland, Architects, Inc.
This drawing may be utilized only for the
purpose of constructing or installing the
work shown thereon at the site of the work
specified. Any other use of this drawing,
including without limitation any
reproduction or alteration of this drawing,
without prior written approval of
Dunwody/Beeland, Architects, Inc. is
prohibited.



A NEW RANGER STATION
AT CLAYSTONE PARK
FOR MACON-BIBB COUNTY
MOSLEY DIXON ROAD MACON, GEORGIA

Revisions:

Sheet Title:
RANGER STATION
MAIN LEVEL
PLUMBING PLAN -
WATER

Project #: 1819 Date: 12/23/19

P2.2RS

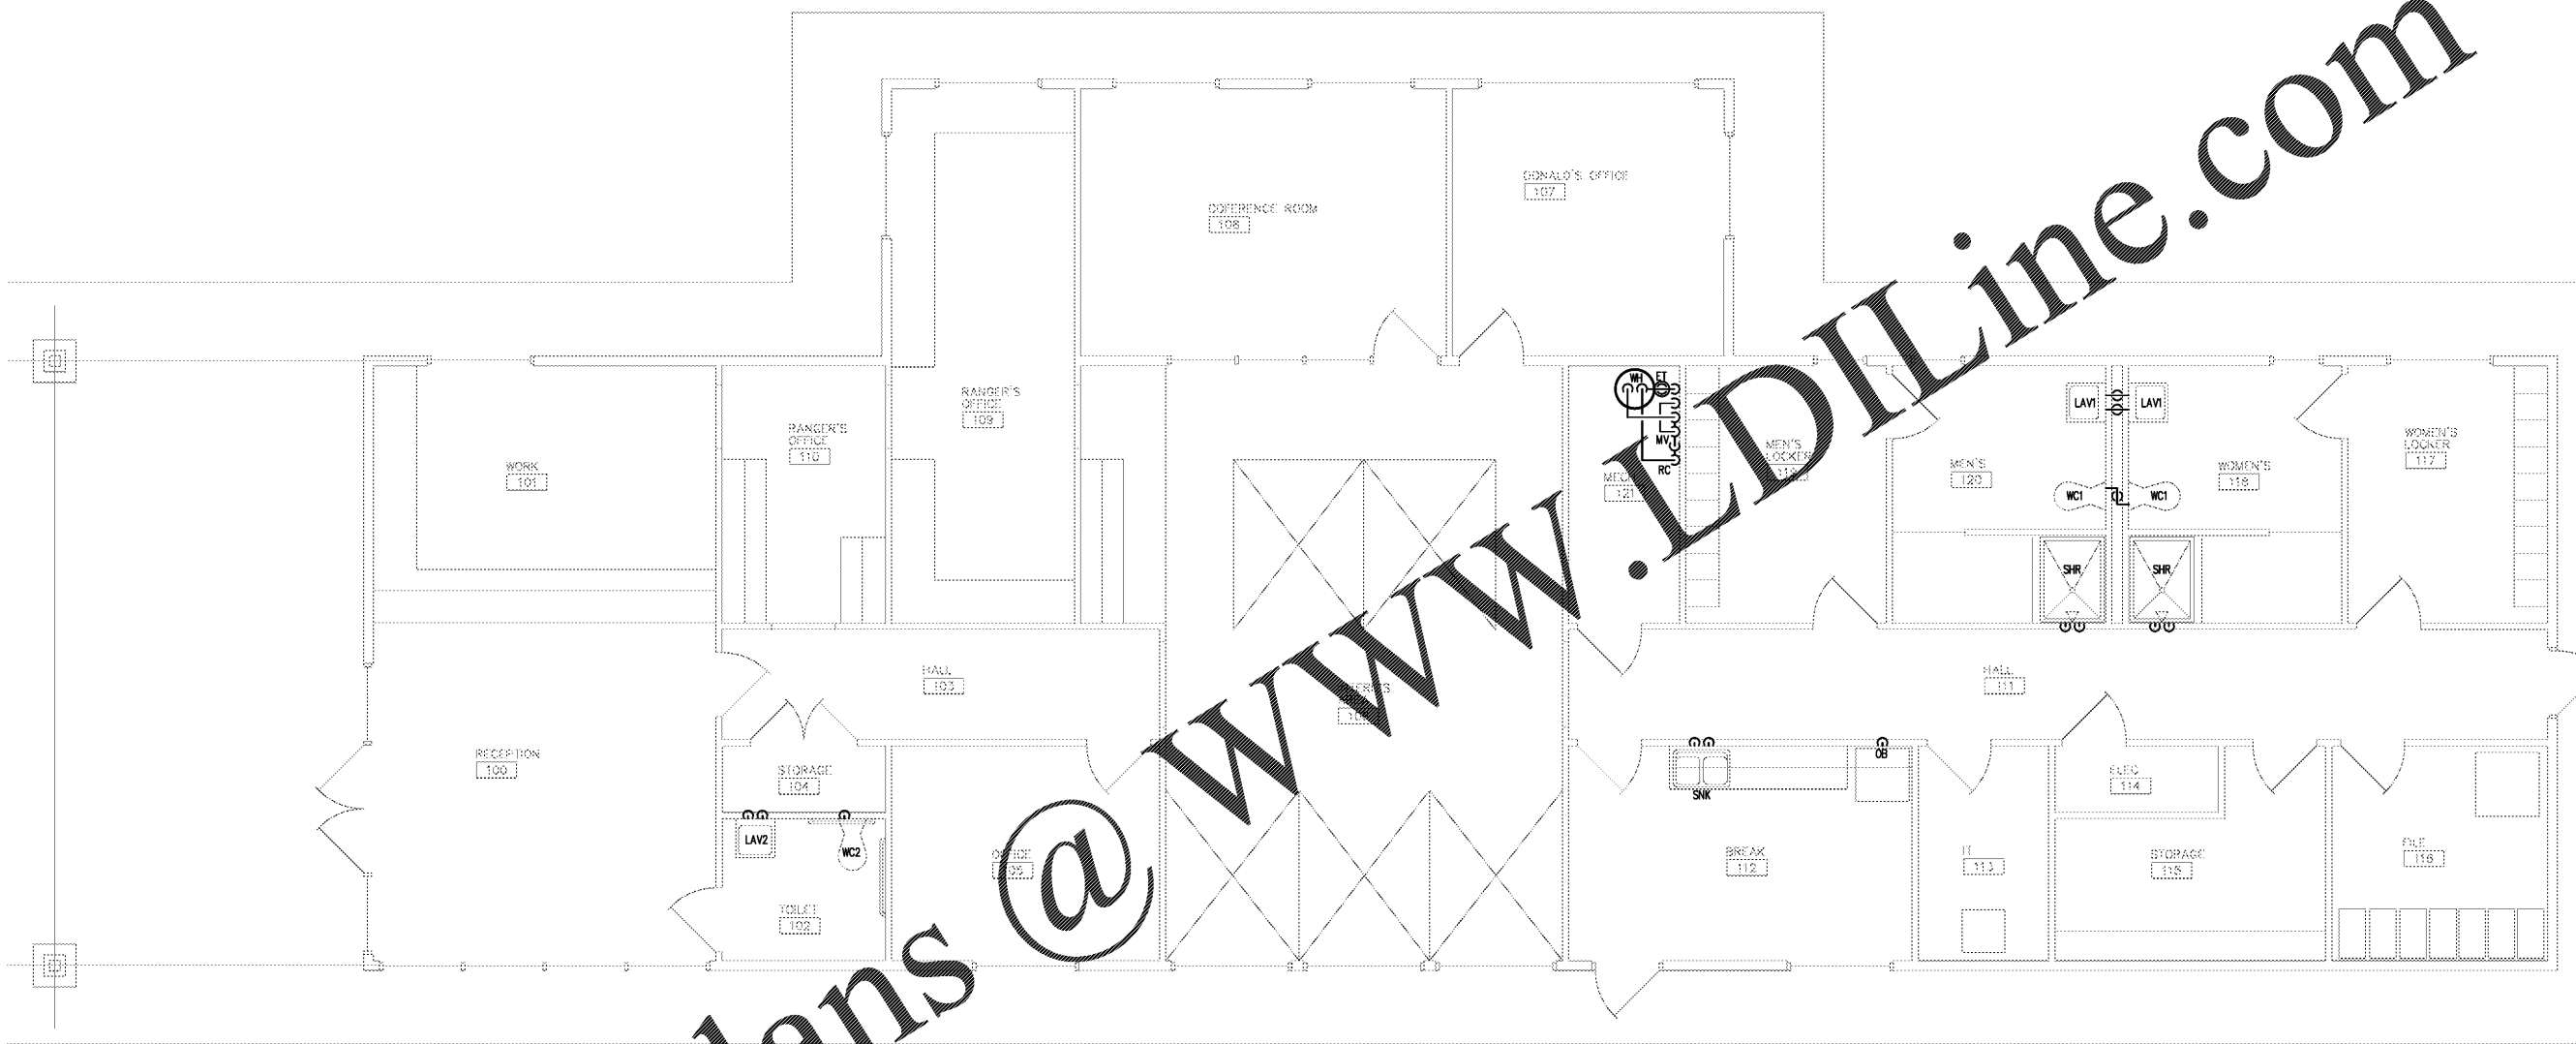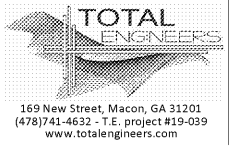

1 MAIN LEVEL PLUMBING PLAN - WATER
SCALE: 1/4"=1'-0"

Order Plans @ WWW.LDILine.com