



**DUNWODY/BEELAND,**  
Architects, Inc.

300 Mulberry Street, Suite 604  
Macon, Georgia 31201  
T 478 742 6321  
F 478 742 0863  
www.dunwodybeeland.com

Dunwody/Beeland, Architects, Inc.  
This drawing may be utilized only for  
the purpose of constructing or  
installing the work shown thereon at the  
site of the work specified. Any other  
use of this drawing, including without  
limitation any reproduction or alteration  
of this drawing, without prior written  
approval of Dunwody/Beeland,  
Architects, Inc. is prohibited.

**A NEW RANGER STATION  
AT CLAYSTONE PARK  
FOR MACON-BIBB COUNTY**

MOSLEY DIXON ROAD MACON, GEORGIA


Revisions:	

Sheet Title:  
**FLOOR PLAN -  
LIGHTING**

Project #: 1819 Date: 12/19/2019


**E2.1**

**ELECTRICAL DESIGN**  
**EDC**  
CONSULTANTS, INC.  
175 NEW ST., STE. 1  
MACON, GA 31201  
EDC • M19050

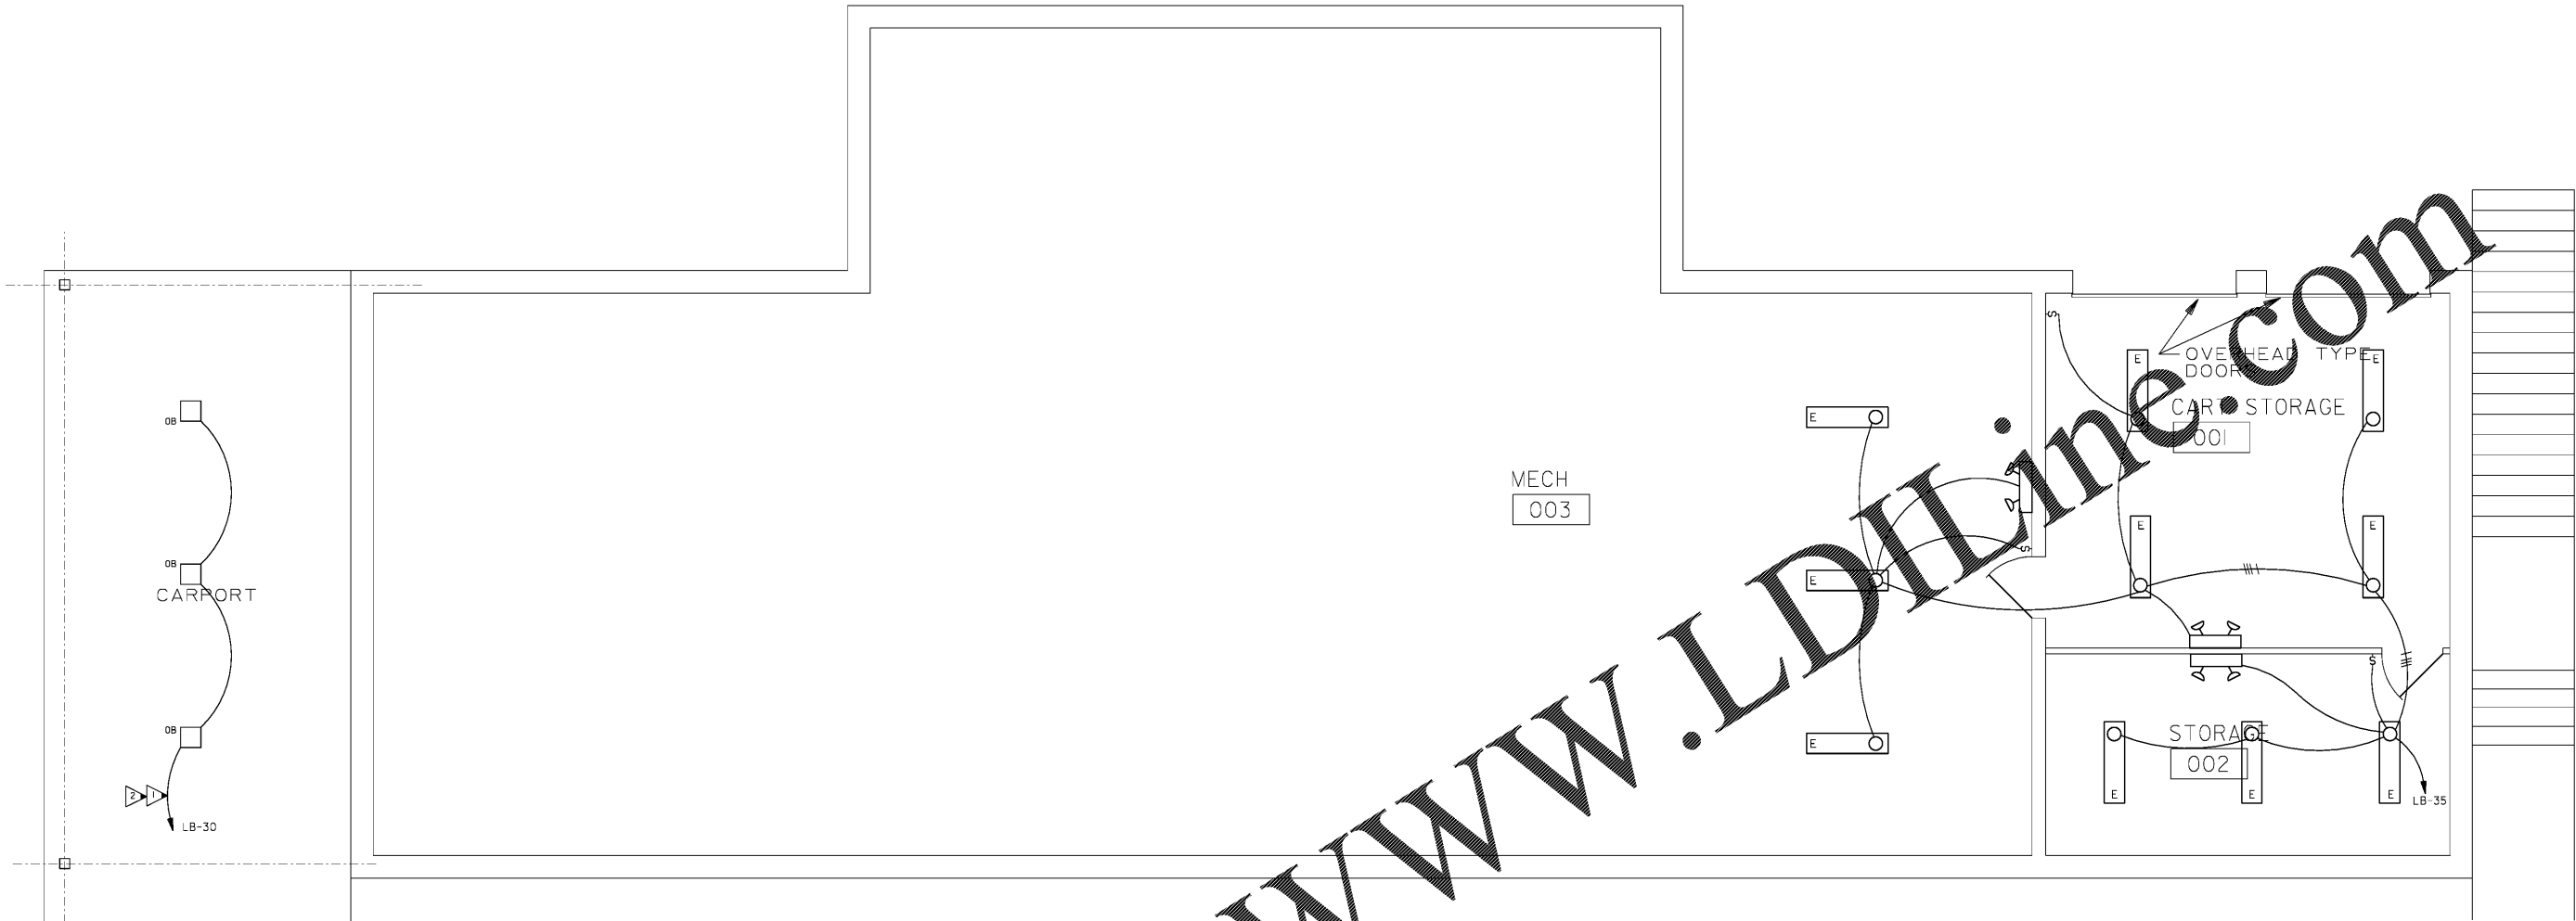

FOUNDATION/LOWER LEVEL FLOOR PLAN - LIGHTING

 SCALE: 1/4" = 1'-0"



**KEYED NOTES:** (THIS SHEET ONLY)

- 1 TO'S ENTIRE CIRCUIT.
- 2 ROUTE VIA PHOTO CELL SHALL CONTROL DUSK TILL DAWN OPERATIONS.

Order Plans @ WWW.LDILine.com