



McFarland Johnson
 2409 N. ROOSEVELT BOULEVARD
 SUITE 4
 KEY WEST, FLORIDA 33040
 P: 321-431-7029
 mjinc.com

PROJECT MILESTONE
BID PLANS

NO.	DATE	DESCRIPTION

CLIENT:
KEY WEST INTERNATIONAL AIRPORT
 KEY WEST, FLORIDA


PROJECT:
AIRPORT MAINTENANCE STORAGE FACILITY PROJECT

DRAWN	JES
DESIGNED	AJF
CHECKED	AJF
SCALE	1"=10'
DATE	MARCH 04, 2020
PROJECT	18221_05

IT IS A VIOLATION OF LAW FOR ANY PERSON, UNLESS THEY ARE ACTING UNDER THE DIRECT DIRECTION OF A LICENSED PROFESSIONAL ENGINEER, ARCHITECT, LANDSCAPE ARCHITECT, OR LAND SURVEYOR, TO ALTER AN ITEM IN ANY WAY. IF AN ITEM BEARING THE STAMP OF A LICENSED PROFESSIONAL IS ALTERED, THE ALTERING ENGINEER, ARCHITECT, LANDSCAPE ARCHITECT, OR LAND SURVEYOR SHALL STAMP THE DOCUMENT AND INCLUDE THE NOTATION "ALTERED BY" FOLLOWED BY THEIR SIGNATURE, THE DATE OF SUCH ALTERATION, AND A SPECIFIC DESCRIPTION OF THE ALTERATION.

DRAWING TITLE
DEMOLITION PLAN

DRAWING NUMBER
 DP-01

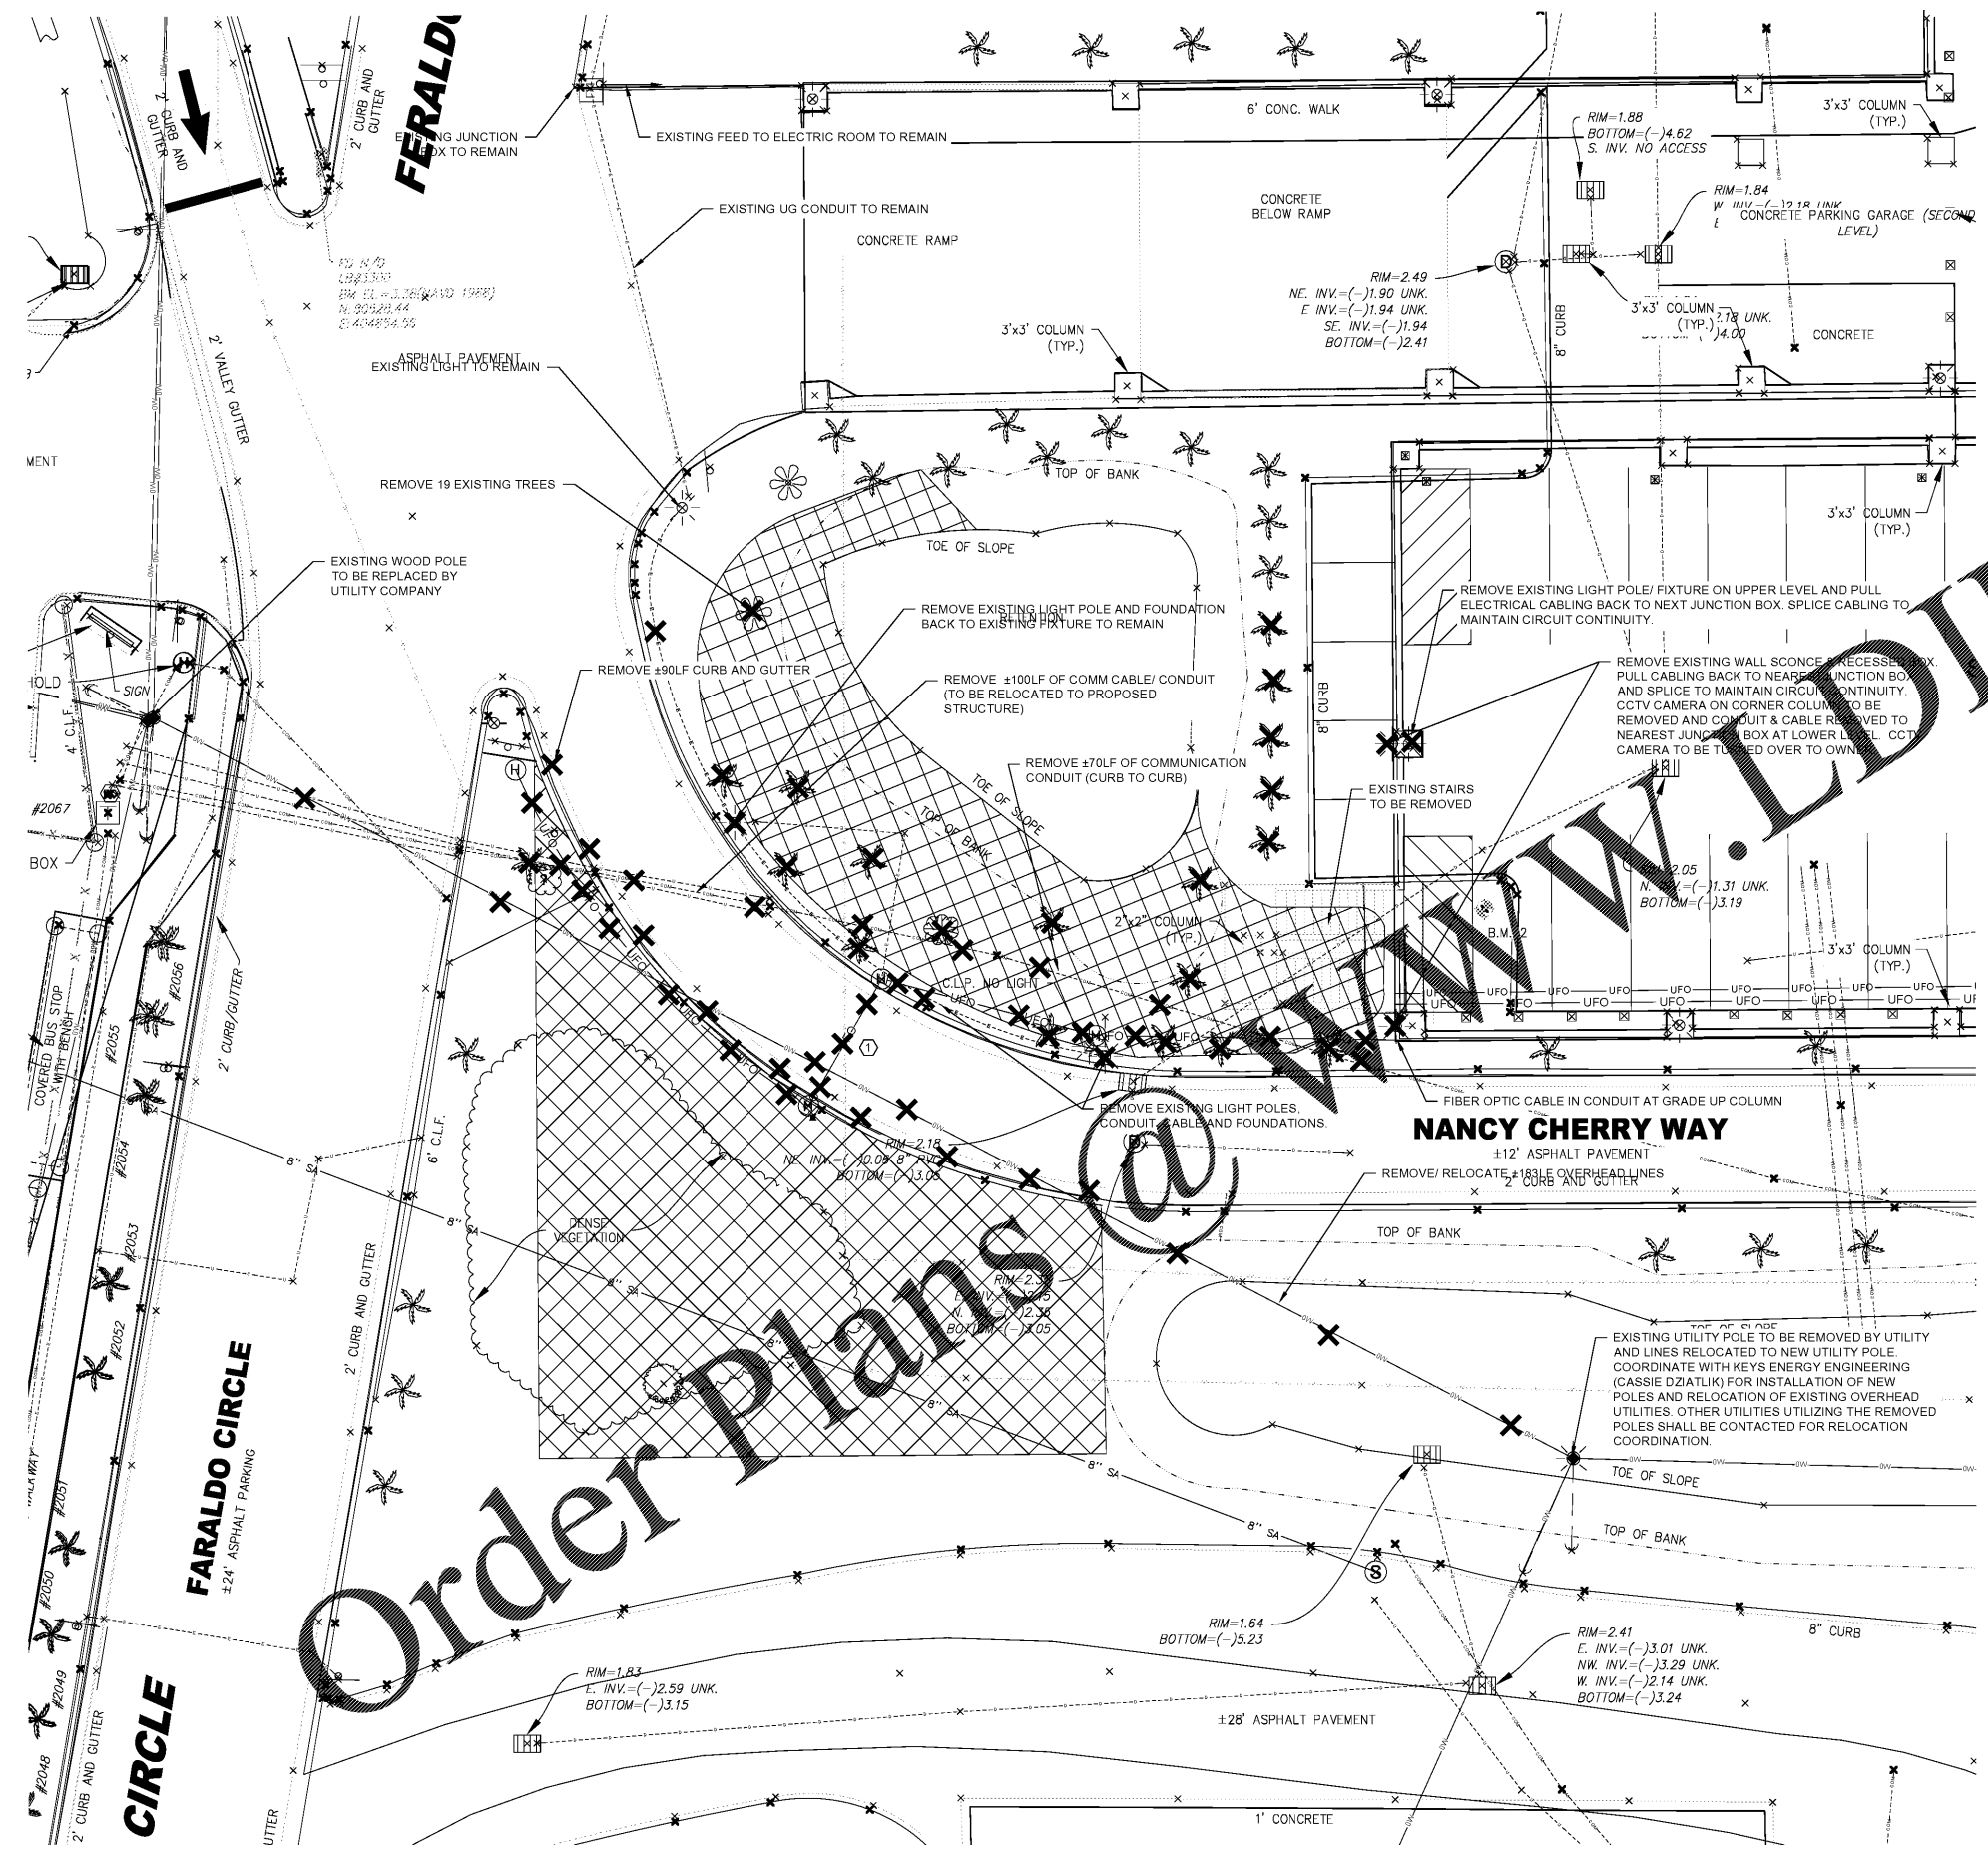

ELECTRICAL REMOVAL NOTES:

EXISTING FIBER OPTIC CABLE AND CONDUIT TO BE REMOVED FROM UNDERGROUND AND CABLE TO BE RE-ROUTED IN NEW CONDUIT. FIBER OPTIC CABLE TO BE PULLED BACK INTO PARKING GARAGE TO ALLOW FOR NEW CONDUIT INSTALLATION. ACTIVE FIBER FOR PARKING REVENUE CONTROL (FROM EAST PAY STATION TO SHORT-TERM PARKING LOT WEST) SHALL BE REMOVED FROM CONDUIT IN ITS ENTIRETY AND REPLACED WITH NEW FIBER FOR ITS ENTIRE LENGTH. INACTIVE FIBER SHALL BE PULLED BACK INTO PARKING GARAGE. SEE ELECTRICAL PLANS E-100 AND E-101 FOR ADDITIONAL INFORMATION.

LEGEND:

- TO BE DEMOLISHED/ REMOVED
- UTILITY SERVICE TO BE DEMOLISHED/ REMOVED
- ITEM TO BE REMOVED
- EXISTING UNDERGROUND ELECTRICAL CONDUIT & CABLE
- EXISTING UNDERGROUND FIBER OPTIC CONDUIT & CABLE
- JUNCTION CAN

