



McFarland Johnson
 2409 N. ROOSEVELT BOULEVARD
 SUITE 4
 KEY WEST, FLORIDA 33040
 P: 321-4321-7029
 mjinc.com

PROJECT MILESTONE
BID PLANS

NO.	DATE	DESCRIPTION

CLIENT: **KEY WEST INTERNATIONAL AIRPORT**

KEY WEST, FL

 

PROJECT: **MAINTENANCE STORAGE FACILITY**

DRAWN	WEF
DESIGNED	WEF
CHECKED	BFD/CMH
SCALE	1/8"=1'-0"
DATE	MARCH 4, 2020
PROJECT	18221.05

IT IS A VIOLATION OF LAW FOR ANY PERSON, UNLESS THEY ARE ACTING UNDER THE DIRECTION OF A LICENSED PROFESSIONAL ENGINEER, ARCHITECT, LANDSCAPE ARCHITECT, OR LAND SURVEYOR, TO ALTER AN ITEM IN ANY WAY. IF AN ITEM BEARING THE STAMP OF A LICENSED PROFESSIONAL IS ALTERED, THE ALTERING ENGINEER, ARCHITECT, LANDSCAPE ARCHITECT, OR LAND SURVEYOR SHALL STAMP THE DOCUMENT AND INCLUDE THE NOTATION "ALTERED BY" FOLLOWED BY THEIR SIGNATURE, THE DATE OF SUCH ALTERATION, AND A SPECIFIC DESCRIPTION OF THE ALTERATION.

DRAWING TITLE
1ST FLOOR ELECTRICAL PLAN

DRAWING NUMBER
E-100

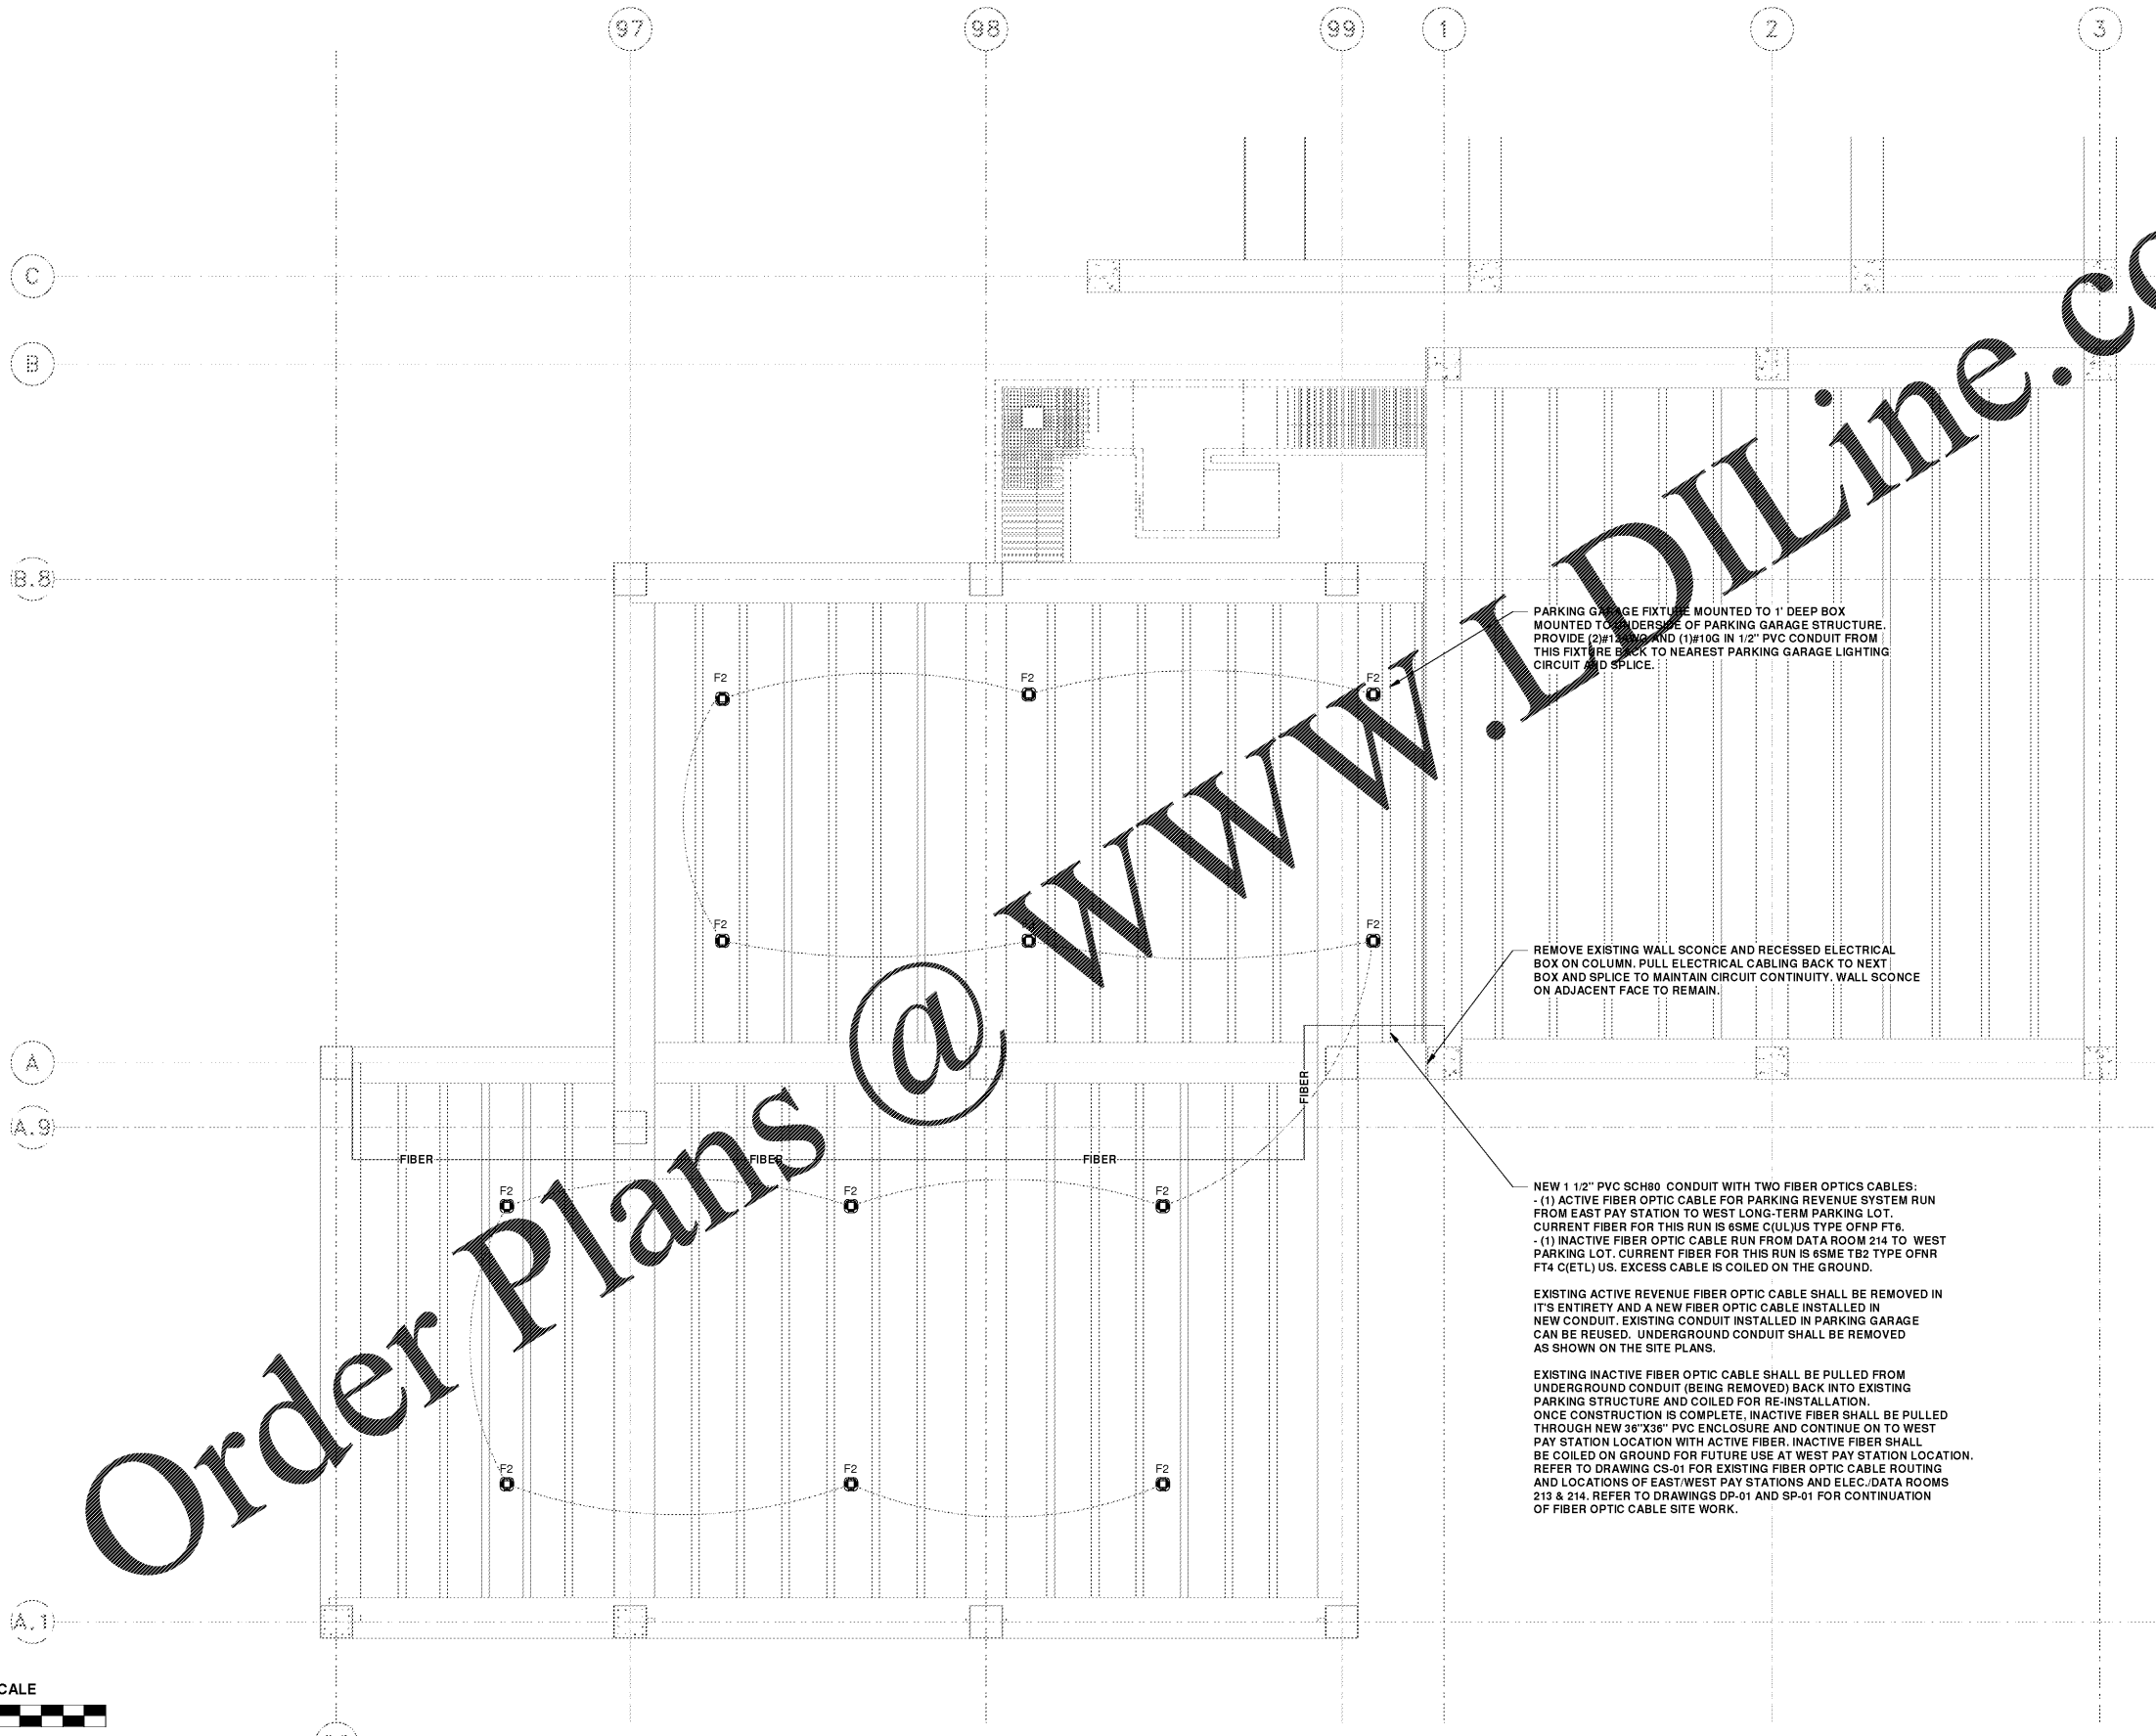

1 Lower Level - Lighting Plan
 1/8" = 1'-0"



Order Plans @ www.LDILine.com

www.LDILine.com

\\pvs01\work\DWG\18221\18221-05\18221-05-100-1.dwg - E:\M\18221-05-100-1.dwg