

CEILING LEGEND


SYMBOL	DESCRIPTION	REMARKS
[Symbol]	RESTROOM EXHAUST DUCT	REFER TO THE MECHANICAL DWGS FOR THE DUCTING GRILLE SIZES
[Symbol]	SUPPLY DIFFUSERS (TYPICAL)	REFER TO THE MECHANICAL DWGS FOR THE CEILING GRILLE SIZES. ALL GRILLES TO BE PAINTED TO MATCH
[Symbol]	RETURN/EXHAUST GRILLE	REFER TO THE MECHANICAL DWGS FOR THE CEILING GRILLE SIZES. ALL GRILLES TO BE PAINTED TO MATCH
[Symbol]	MUSIC SPEAKERS	FURNISHED & INSTALLED BY AUDIO VENDOR. PAINT TO MATCH CEILING TILES
[Symbol]	DRIVE-THRU SPEAKERS	FURNISHED BY OWNER, INSTALLED BY GC
[Symbol]	SURFACE MOUNTED SPEAKERS	FURNISHED & INSTALLED BY AUDIO VENDOR.

- ### NOTES
- THE ELECTRICAL CONTRACTOR SHALL FURNISH AND INSTALL ALL REQUIRED ACCESSORIES, OPTIONS, MOUNTING HARDWARE, AND FIELD FABRICATION REQUIRED TO PROPERLY ADAPT THE FIXTURES TO THE SPECIFIC APPLICATIONS.
 - LAY-IN LIGHTING FIXTURES SHALL NOT RELY ON THE CEILING SYSTEM ALONE FOR SUPPORT. LAY-IN LIGHTING FIXTURES SHALL BE SUPPORTED FROM THE STRUCTURE BY NO LESS THAN TWO HANGER WIRES AND SECURED TO THE CEILING GRID SYSTEM WITH THE APPROPRIATE SCREW HARDWARE.
 - CUT-OUTS AT FIXTURES IN LAY-IN CEILING SHALL BE PRECISE WITH NO GAPS, CHIPS OR IRREGULARITIES.
 - CEILING GRID SHALL BE LEVEL WITHIN A TOLERANCE OF 1/8" IN A SPAN OF 10'-0".
 - ELECTRICAL CONTRACTOR TO CLEARLY LABEL PANEL BOARD CIRCUITING AS TO OPERATION.
 - ALL ELECTRICAL DEVICES SHALL BEAR THE U.L. LABEL.
 - ALL ELECTRICAL WORK SHALL FOLLOW ALL APPLICABLE NATIONAL, STATE AND LOCAL CODES, REGULATIONS AND LAWS.
 - SEE ELECTRICAL DRAWINGS FOR ADDITIONAL REQUIREMENTS AND SPECIFICATIONS.
 - SEE MECHANICAL DRAWINGS FOR ADDITIONAL REQUIREMENTS AND SPECIFICATIONS.
 - DIMENSIONS SHOWN ARE FINISH DIMENSIONS, UNLESS NOTED OTHERWISE.
 - REFER TO FLOOR PLAN, SHT. A-1 FOR FRAMING DIMENSIONS OF WALLS AND BULKHEADS.
 - AT DINING AREAS, THIS ORDER AREA, KITCHEN AREA, MANAGER OFFICE, ALL SUPPLY AND RETURN DIFFUSERS (AND CEILING SPEAKERS WHERE APPLICABLE) ARE TO BE FACTORY FINISH COLOR AND SHALL MATCH THE COLOR OF ADJOINING CEILING.
 - AT EACH RESTROOM, ALL EXHAUST FANS, SUPPLY DIFFUSERS, AND SPEAKERS ARE TO BE FACTORY FINISH COLOR: WHITE.


REFLECTED CEILING PLAN SCALE: 1/4" = 1'-0" ①

LIGHTING FIXTURE SCHEDULE

FIXTURE TYPE	SYMBOL	DESCRIPTION	MANUFACTURER & MODEL NUMBER	LAMP TYPE	LAMP WATTAGE	REMARKS	GENERAL NOTE
A	[Symbol]	2x4 LAY-IN LED RECESSED CEILING LIGHT FIXTURE WITH REFLECTOR AND DRIVER	SECURITY LITE (2020) 2x4x4 (ACT-1)	LED	55W	G.C. TO ORDER AND PROVIDE APPROPRIATE HANGERS AND FIELD FABRICATION FOR PROPER CEILING INSTALLATION.	
B	[Symbol]	SMALL 1x2x2 LED RECESSED CEILING LIGHT FIXTURE FOR EMERGENCY LIGHTING	SECURITY LITE (2020) 1x2x2 (ACT-2)	LED	10W		
D	[Symbol]	2x4 RECESSED LED IN PROTRUSIVE CEILING LIGHT FIXTURE WITH ENHANCED ALUM. REFLECTOR AND DRIVER FOR EMERGENCY LIGHTING	SECURITY LITE (2020) 2x4x4 (ACT-3)	LED	55W		
E	[Symbol]	SMALL 1x2x2 LED OUT VENTILATOR	SECURITY LITE (2020) 1x2x2 (ACT-4)	LED	10W		
F	[Symbol]	PENDANT FIXTURE	SECURITY LITE (2020) P-1	LED	60W	FIELD PROVIDED CHAIN LINKS 18"	
G	[Symbol]	PENDANT FIXTURE	SECURITY LITE (2020) P-2	LED	60W	LARGE BROWN FINISH WITH 18" X 18" GLASS SHADE, WITH 18" CHAIN LINKS	
J	[Symbol]	RECESSED LED DOWN LIGHT	SECURITY LITE (2020) D-1	LED	10W	PROVIDE WHITE TRIM & BLACK TRIM FOR THE WHITE CLG. & BLACK CLG.	DINING ROOM CEILING
K	[Symbol]	DRY STORAGE/UTILITY AREA - 1x4 RECESSED LED	SECURITY LITE (2020) S-1	LED	10W	GYP BOARD MOUNTING KIT AND RECESSED LED DOWN LIGHT	
L	[Symbol]	EMERGENCY SIGN OVER LIGHT WITH RECESSED OUTDOOR FIXTURE	SECURITY LITE (2020) E-1	LED	3.65W	COMBO EXIST LIGHT SHALL BE WHITE	
M	[Symbol]	AWNING LED	SECURITY LITE (2020) A-1	LED	60W	RECESSED OUTDOOR LIGHT SHALL BE BLACK	
P	[Symbol]	AWNING LIGHTS & DOWNLIGHT	SECURITY LITE (2020) P-3	LED	25W	LED SUPPLIED WITH AWNING. G.C. TO SUPPORT CONNECT TO POWER	
Q	[Symbol]	AWNING DOWNLIGHT ONLY	SECURITY LITE (2020) P-4	LED	12W	FIELD PROVIDE UPDOWN LIGHTING, 25 WATT, BLACK FINISH	
T1	[Symbol]	SITE LIGHT	SECURITY LITE (2020) T-1	LED	12W	WALL MOUNTED, DOWN LIGHTING, 14 WATT, BLACK FINISH	SEE CIVIL DWGS FOR LOCATION
T2	[Symbol]	SITE LIGHT	SECURITY LITE (2020) T-2	LED	12W	WALL MOUNTED, DOWN LIGHTING, 14 WATT, BLACK FINISH	SEE CIVIL DWGS FOR LOCATION
Z	[Symbol]	FREEZER LIGHTS - AMPOR TYPE	SEE DRAWINGS	FLUORESCENT	40W	FURNISHED AND LAMP PROVIDED BY GYP. - SEE DRAWINGS FOR LOCATION	

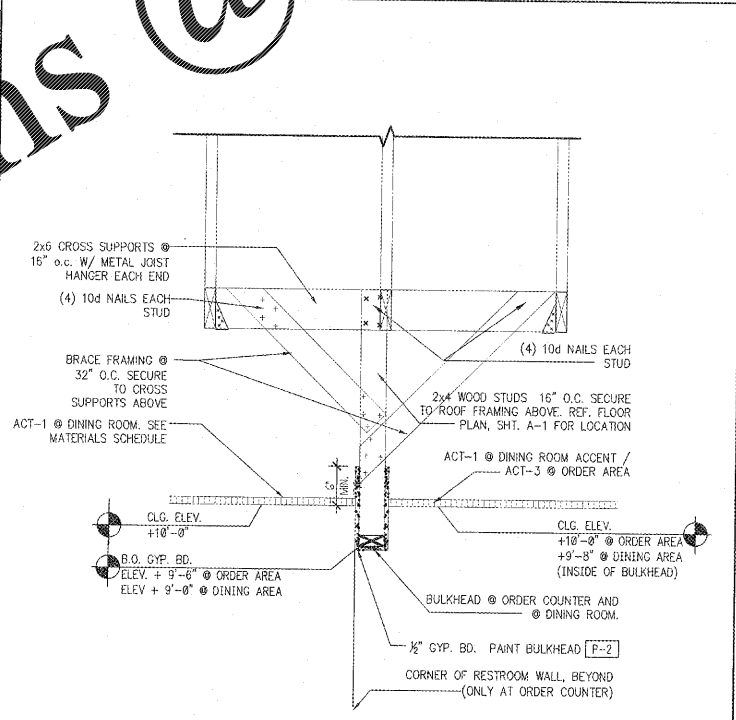

BULKHEAD DTL. • ORDER COUNTER / • DINING ROOM SCALE: 1" = 1'-0" ⑤

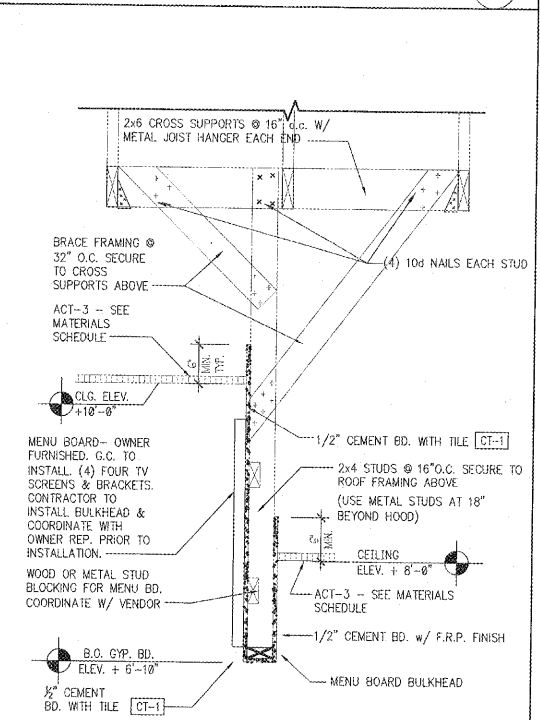

MENU BOARD BULKHEAD DTL. SCALE: 1" = 1'-0" ⑦

MATERIALS SCHEDULE

SYMBOL	MATERIAL	DESCRIPTION	REMARKS
ACT-1	2'x 2' CEILING TILE	ARMSTRONG - FINE FISSURED #928 WHITE COLORED TILE WITH SQUARE EDGE. ARMSTRONG 15/16" TEE GRID SYSTEM WITH MATCHING WHITE COLOR.	
ACT-2	2'x 2' CEILING TILE	ARMSTRONG - FINE FISSURED #1729 BL - TECH BLACK COLORED TILE WITH SQUARE EDGE. ARMSTRONG 15/16" EXPOSED TEE GRID SYSTEM WITH MATCHING TECH BLACK COLOR.	
ACT-3	2'x 2' WASHABLE CEILING TILE	USC (500) 950-3839 - SHEETROCK OLIMPLUS 3270 VINYL FACED GYPSUM LAY-IN PANELS, 24"x24"x1/2" SQUARE EDGE, WHITE STIPPLE, w/DOWN SERIES DXL CLASS A 15/16" STANDARD EXPOSED GRID SYSTEM. COLOR: FLAT WHITE.	
GYP-1	GYP. BOARD, CEILING	5/8" GYP. BOARD CEILING (RESTROOMS). PAINTED SHERWIN WILLIAMS SW7009 COLOR: PEARLY WHITE - SATIN LATEX.	SEE P-4 SHT. A1.1
GYP-2	GYP. BOARD, CEILING	5/8" GYP. BD. CEILING (DRY STORAGE AREA). PAINTED SHERWIN WILLIAMS SW7009 COLOR: PEARLY WHITE - SATIN LATEX.	SEE P-5 SHT. A1.1

MATERIALS SCHEDULE N.T.S. ⑧

LIGHT FIXTURE SCHEDULE SCHEDULE REVISED TO MATCH LIGHT FIXTURE SCHEDULE SHEET E-2.

NRD Project # 19228

NRD national restaurant designers
ARCHITECTS & ENGINEERS
3005 CARRINGTON MILL RD., SUITE 105
MORRISVILLE, NORTH CAROLINA 27560
PH: 919 544 7251 FAX: 919 544 5369
A Division of LHNT Associates

COMMONWEALTH OF VIRGINIA
Professional Seal
Lyle W. Hordner
L.S. No. 1018279
ARCHITECT

Hordner
ARCHITECTURAL PROFESSIONAL SERVICE
ONE WOOD PROTOTYPE REVERSE
LARGE DINING ROOM - BN2016 LDR
COUNTY DRIVE
DISPUTANTA, VA 23842

OWNER
BN

BODDE-NOELL ENTERPRISES, INC.
P.O. BOX 1908
ROCKY MOUNT, NC
27802-1908
(252) 927-2800

REVISIONS

NO.	DATE	DESCRIPTION

DRAWN BY: _____ CHECKED BY: _____

REFLECTED CEILING PLAN

DATE: 9-4-2019

SHEET NUMBER: **A-2.0**