


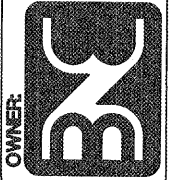

BODDIE-NOELL ENTERPRISES, INC.
 P.O. BOX 908
 ROCKY MOUNT, NC 27802-1908
 (252) 987-2800




NO.	REVISIONS	DESCRIPTION	DATE

DRAWN BY: _____ CHECKED BY: _____

ROOF POWER PLAN

DATE: 9-4-2019

SHEET NUMBER:
E4

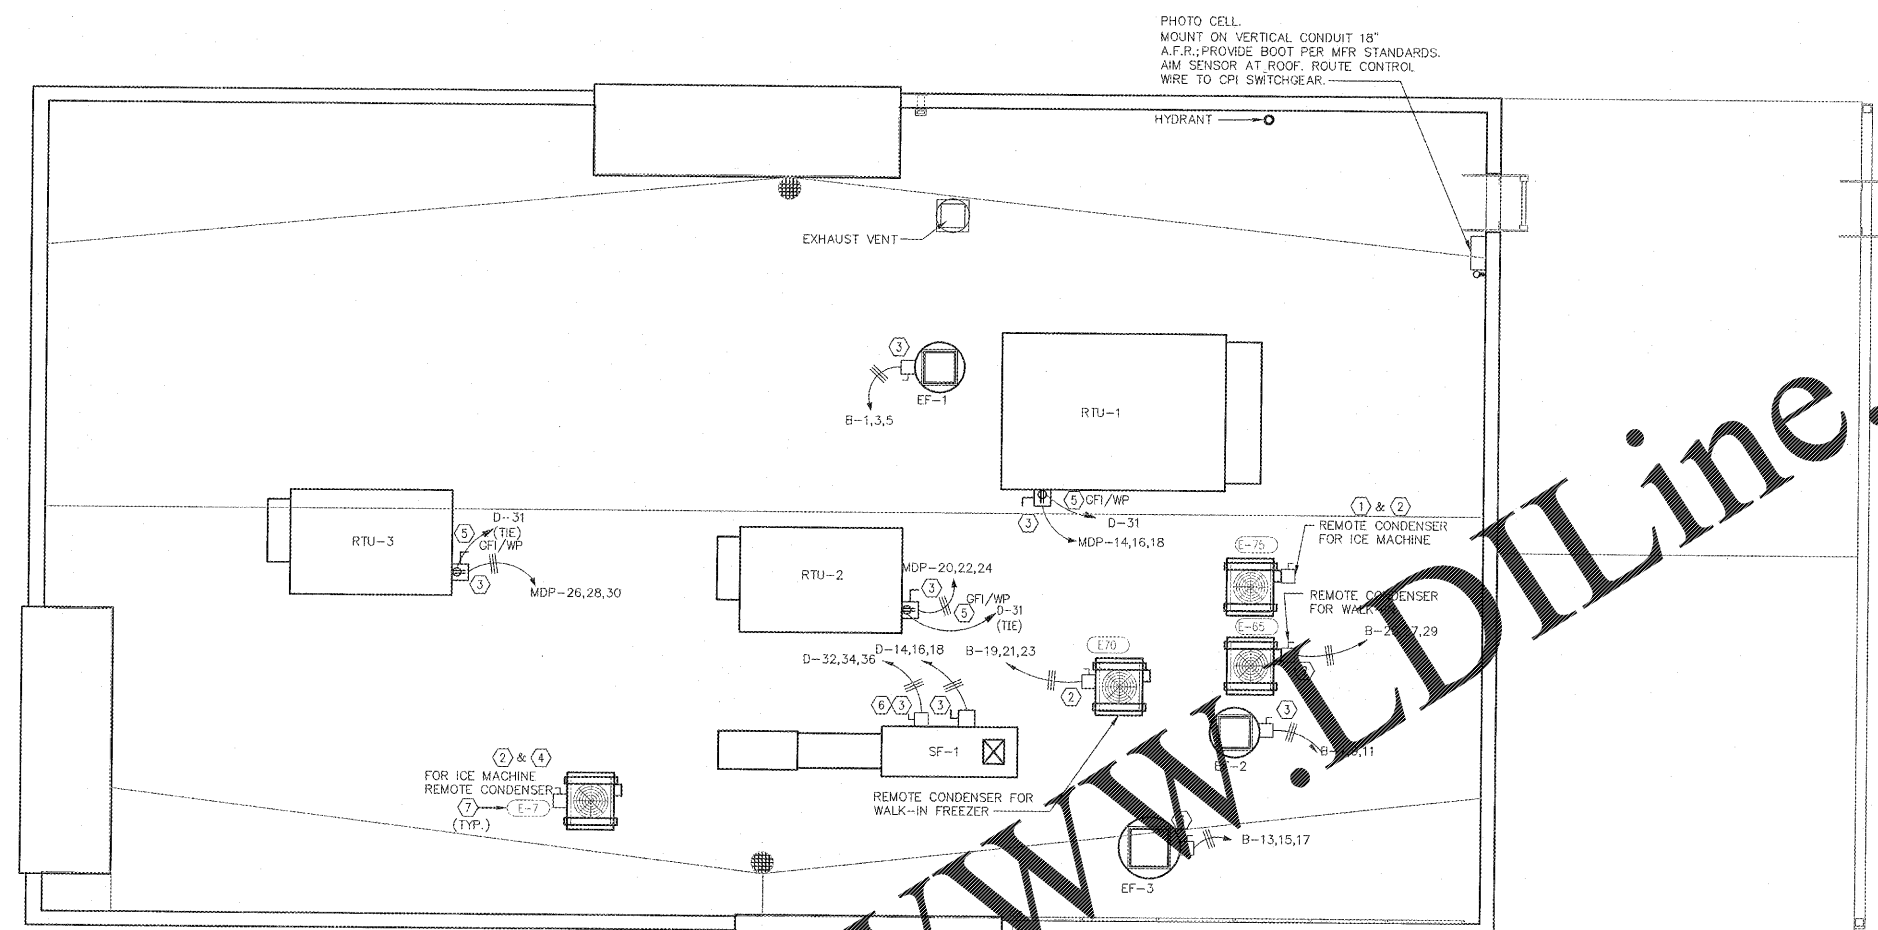


ROOF POWER PLAN

SCALE: 1/4"=1'-0" 1

Order Plans @ WWW.LDLine.com

NOTE: SEE SHEETS CPI-1.0 THRU CPI-2.3 FOR CPI INFORMATION RELATED TO WIRING OF CONTROLS & ENERGY MANAGEMENT.

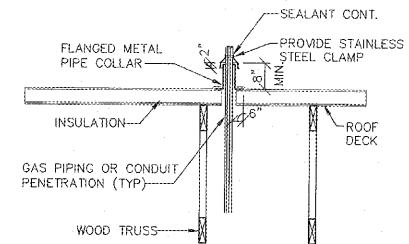

PIPE SEAL THRU ROOF

N.T.S. 3 SHEET NOTES

- NOTES:**
- ICE MACHINE CONDENSER POWERED FROM ICE MACHINE IN KITCHEN.
 - E.C. TO FURNISH & INSTALL NEMA 3R WEATHERPROOF DISCONNECT.
 - NEMA 3R DISCONNECT SWITCH FURNISHED W/ EQUIPMENT.
 - ICE MACHINE CONDENSER POWERED FROM ICE MACHINE ON BEVERAGE TOWER AT SELF SERVE BAR.
 - WP/ GFCI 20A DUPLEX FACTORY INSTALLED W/ RTU, E.C. TO PROVIDE WIRING.
 - FOR MUA ELECTRICAL HEATER, VERIFY WIRING WITH MFG.
 - EQUIPMENT TAGS, SEE QF100 & QF300 FOR ADDITIONAL INFORMATION

GENERAL NOTE:

- ROOFTOP RECEPTACLES REQUIRED WITHIN 25' OF MECHANICAL EQUIPMENT.