


N/F  
SHIV I, INC  
T.M. #340(20)00-003-0  
INST. #070005780  
P.B. 23, PG. 122-123  
NEW BOHEMIA BUSINESS PARK  
LOT 3

PROPOSED 45' WIDE CROSS ACCESS EASEMENT

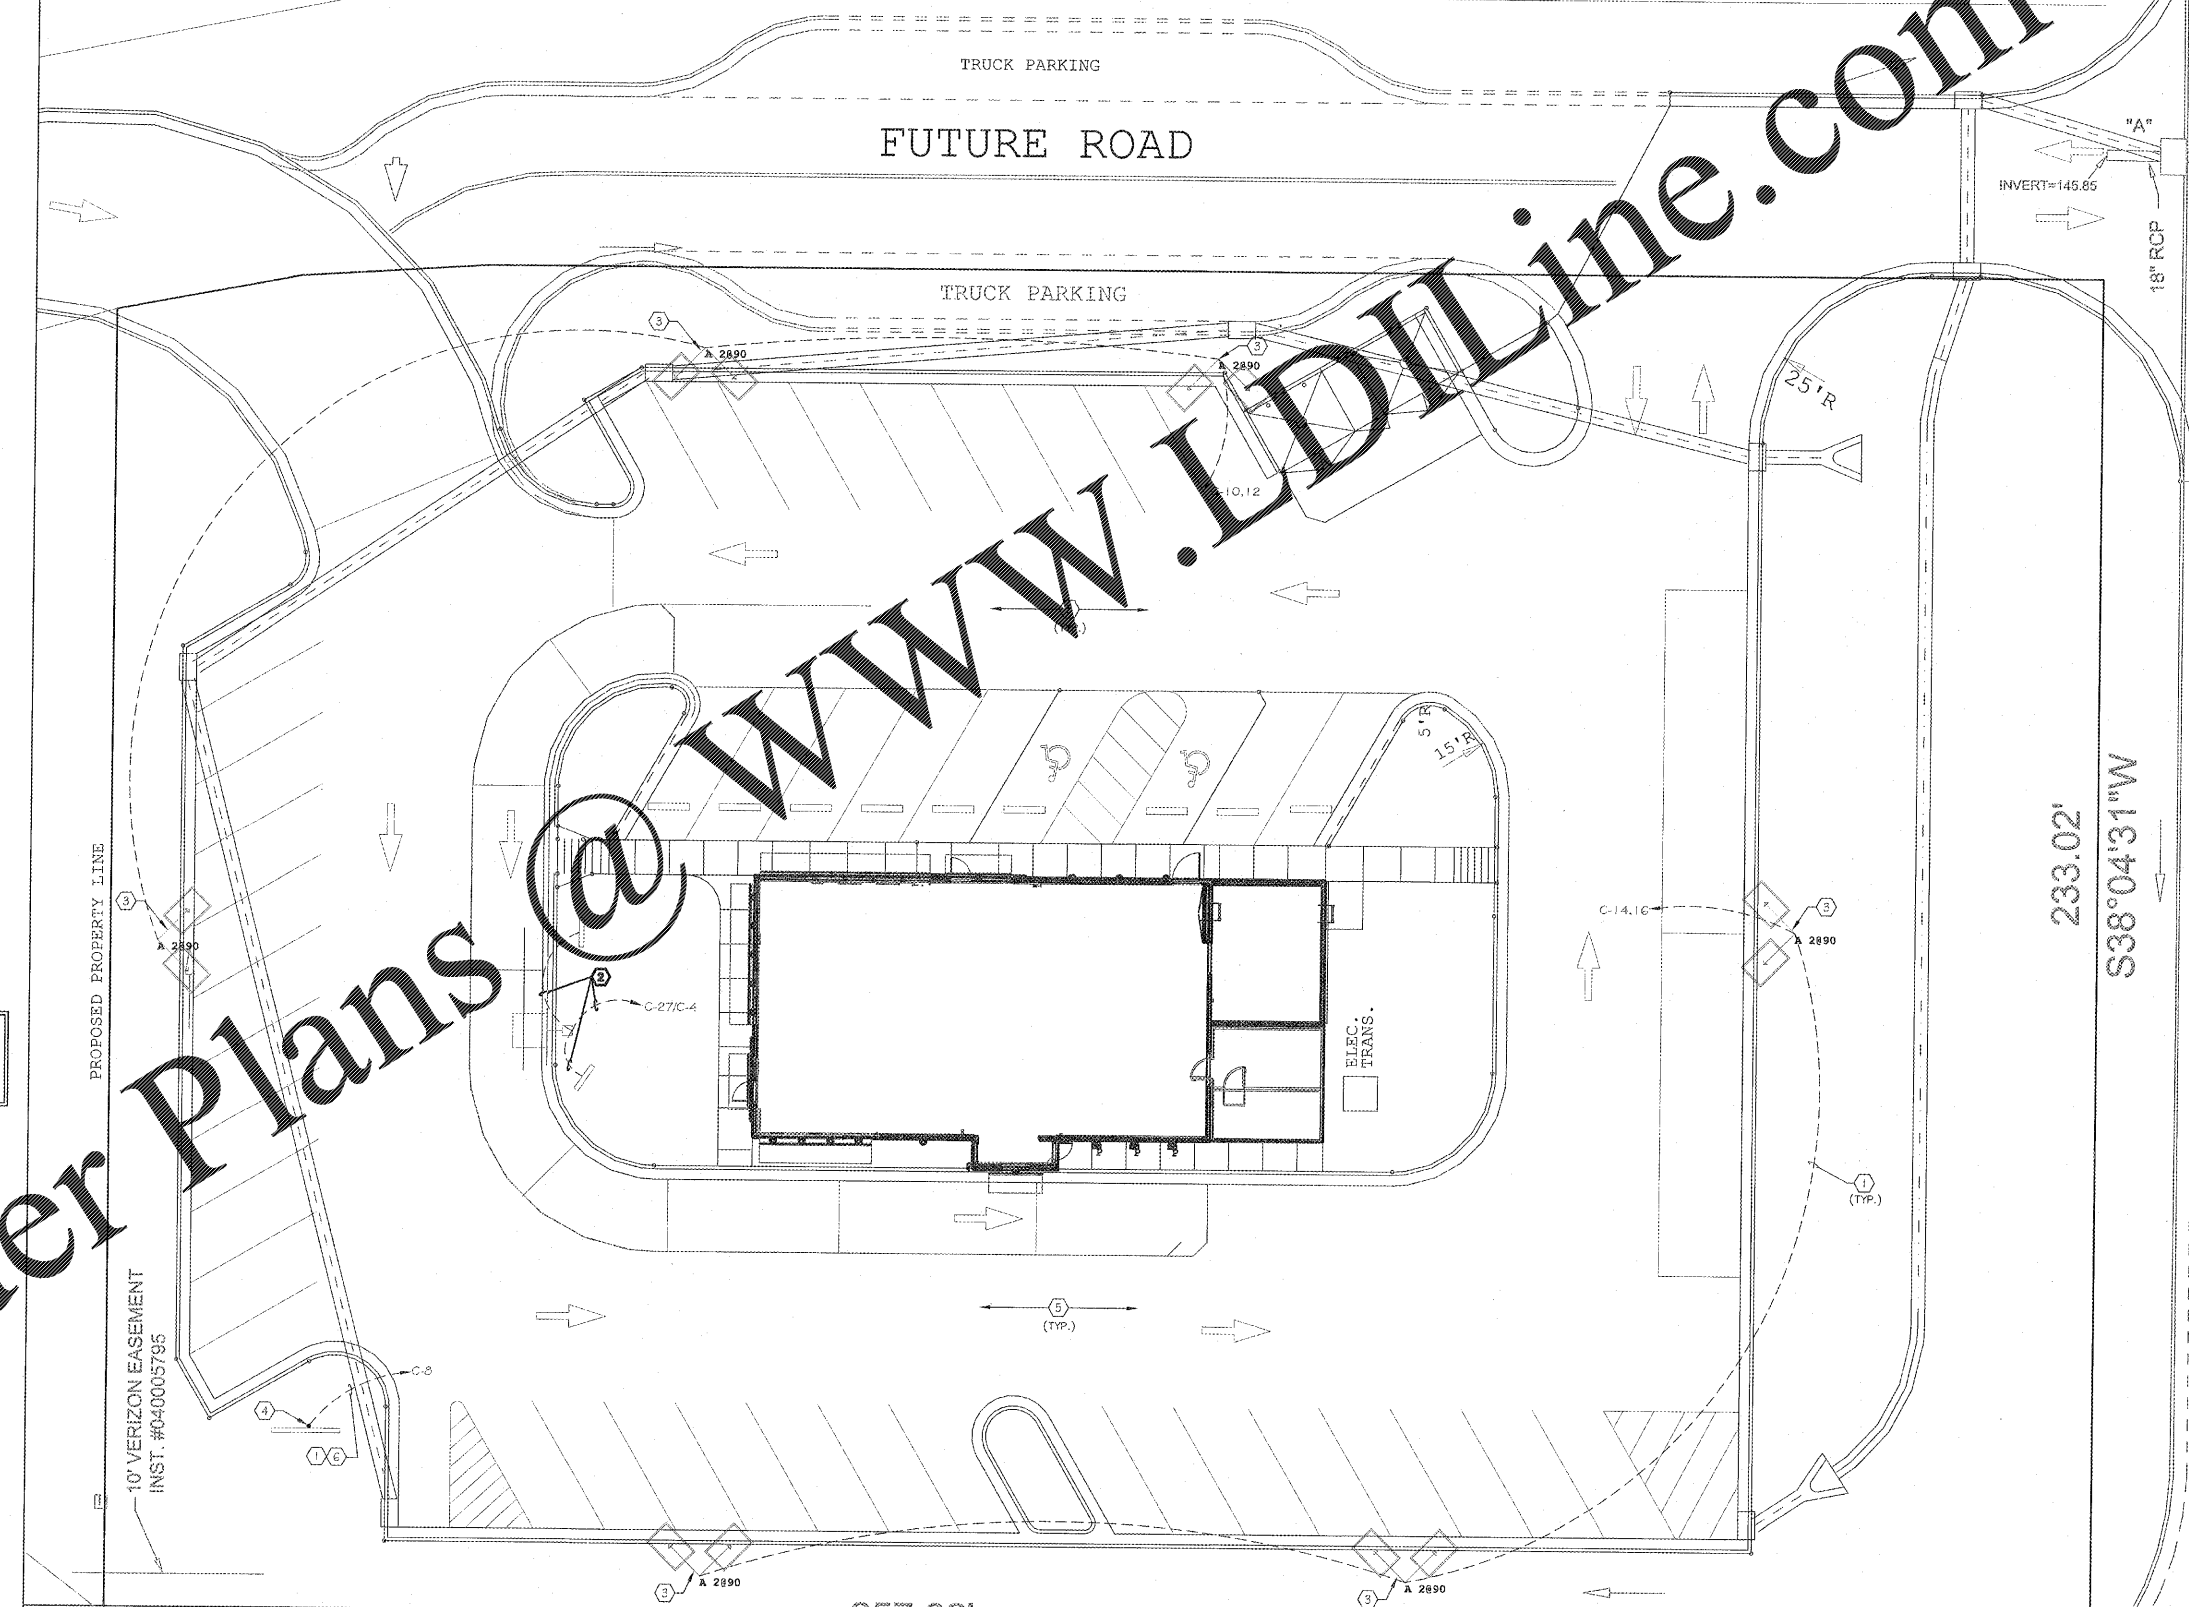

NOTE: SEE SHEETS CPI-1.0 THRU CPI-2.3 FOR CPI INFORMATION RELATED TO WIRING OF CONTROLS & ENERGY MANAGEMENT.

- SITE LIGHTING CODED NOTE**
- 1) ELECTRICAL CONTRACTOR SHALL PROVIDE ALL TRENCHING AND BACKFILLING AS REQUIRED TO BURY ALL SITE LIGHTING AND SIGN CIRCUITS. RUN #8 CONDUCTORS IN 1" PVC CONDUIT AT A MIN. DEPTH OF 24" BELOW GRADE WITH ELECTRICAL WARNING TAPE 6" ABOVE CONDUIT.
  - 2) FOR ADDITIONAL DRIVE THRU INFORMATION, SEE SHEET AS.1.
  - 3) POLE BASE FOR SITE LOT LIGHT, SEE DETAIL ON SHEET AS.1.
  - 4) POLE SIGN, CONSULT OWNER FOR VERIFICATION OF ELECTRICAL REQUIREMENTS.
  - 5) SEE CIVIL SHEETS FOR PHOTO METRIC STUDY OF THIS SITE PER LOT LIGHT FIXTURE SELECTIONS.
  - 6) #8, 1" (MINIMUM)
- NOTE:  
1) THIS SITE DRAWING IS FOR CIRCUITING PURPOSES ONLY. REFER TO CIVIL DRAWINGS FOR ACTUAL SIGN AND MENU BOARD LOCATIONS, SITE LIGHTING LAYOUT, FIXTURE TYPE AND PHOTOMETRICS.  
2) SEE CIVIL SITE PLAN FOR EXACT LOCATION OF YARD LIGHTS AND PRIME SIGNS. REFER TO PANEL SCHEDULES FOR CIRCUITS, E.C. SHALL VERIFY VOLTAGE DROP IS 3% OR LOWER. E.C. SHALL CONFIRM THAT TRENCHES PROVIDED FOR SITE LIGHTING, MEET DEPTH REQUIREMENTS OF NEC. DISCONNECT SWITCH FOR PRIME SIGN IS FURNISHED BY SIGN CONTRACTOR.

SITE LIGHTING PLAN

SCALE: 1"=20'-0" 1

NRD Project # 18228

**NRD** national restaurant designers  
ARCHITECTS & ENGINEERS  
1005 CARRINGTON HILL BLVD. SUITE 105  
MORRISVILLE, NORTH CAROLINA 27560  
PH: 919 544 7281 FAX: 919 544 3369  
A Division of LMHT Associates

Professional Engineer  
RESIDUAL ENGINEER  
CONTRACTOR  
COMMERCIAL ENGINEER  
MEMBER OF THE NORTH CAROLINA SOCIETY OF PROFESSIONAL ENGINEERS  
NOVEMBER 1988

**StarHarden**  
BINE WOOD PROTOTYPE REVERSE  
LARGE DINING ROOM - BN2016 LDR  
COUNTY DRIVE  
DISPUTANTA, VA 23842

OWNER  
**BN**  
BODDIE-NOELL  
ENTERPRISES, INC.  
P.O. BOX 1808  
ROCKY MOUNT, NC  
27802-1808  
(252) 837-2800

NO.	REVISIONS	DESCRIPTION	DATE

DRAWN BY: \_\_\_\_\_ CHECKED BY: \_\_\_\_\_

**ELECTRICAL  
SITE  
LIGHTING  
PLAN**

DATE: 9-4-2019

SHEET NUMBER:  
**E5**