



Order Plans @ [www.LDILine.com](http://www.LDILine.com)

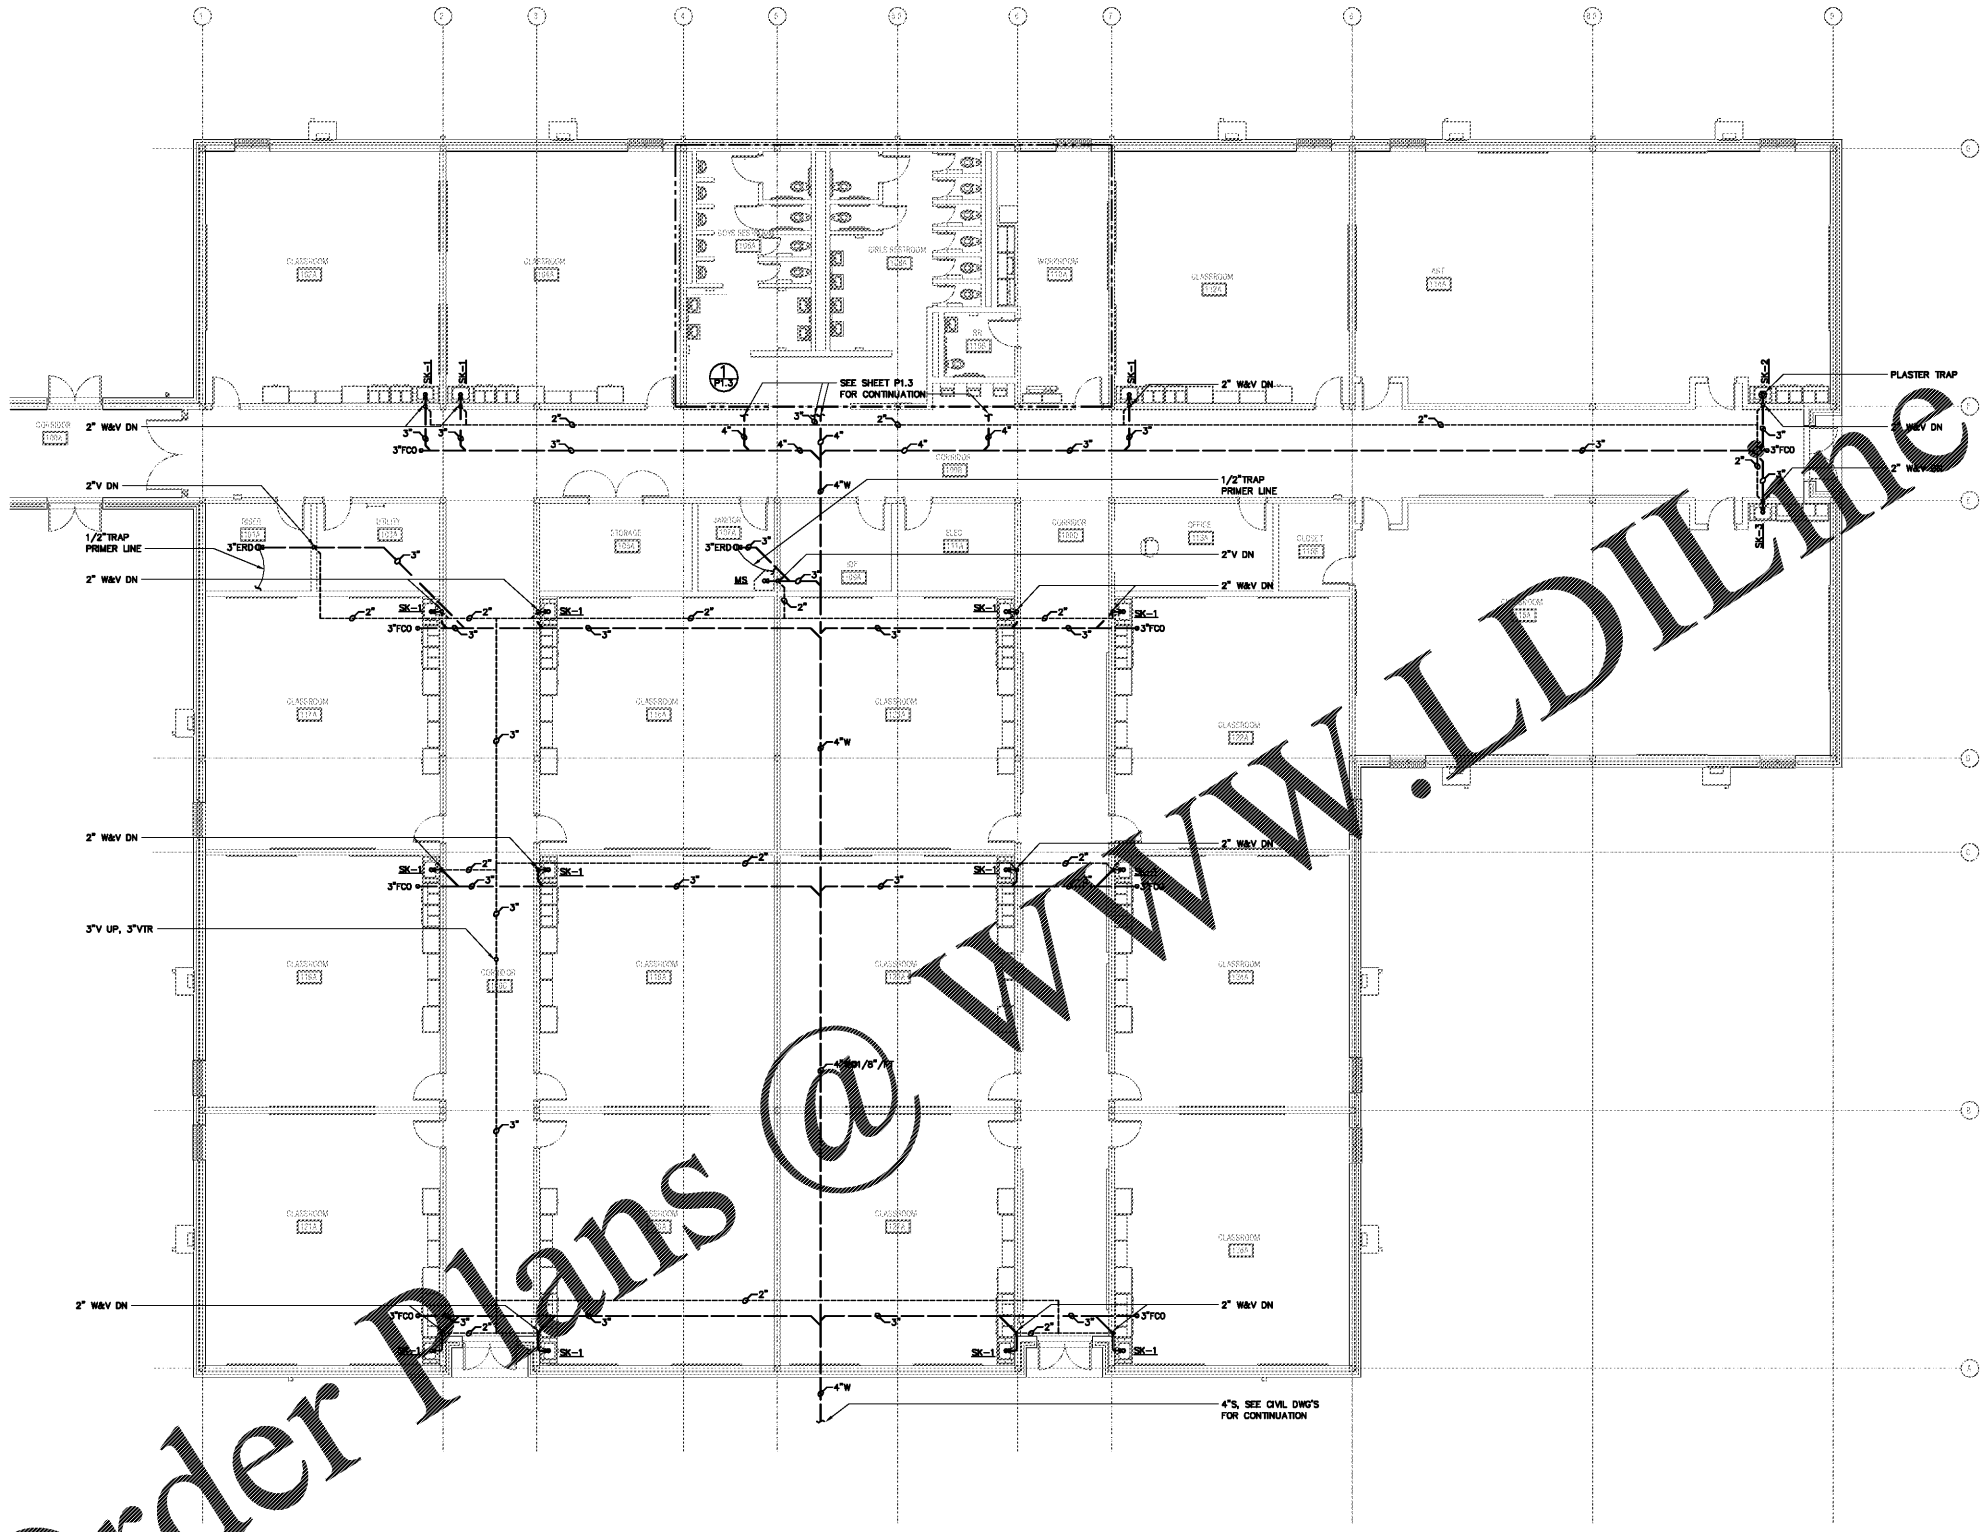

1 PLUMBING - S, W&V PIPING PLAN  
P1.1 SCALE: 1/8" = 1'-0"

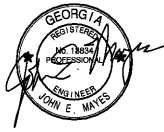

03-06-2020

REV	DESCRIPTION	DATE

RUSSOM ELEMENTARY SCHOOL  
 ADDITION  
 44 RUSSOM ELEMENTARY SCHOOL LANE  
 DALLAS, GA 30132  
 (FACILITY CODE: 710-0204)  
 PAULDING COUNTY SCHOOLS

PLUMBING -  
 S,W&V PIPING  
 PLAN

DATE: 03/06/2020  
 PROJECT NO.: 19117

P1.1