



Order Plans @ www.LDILine.com

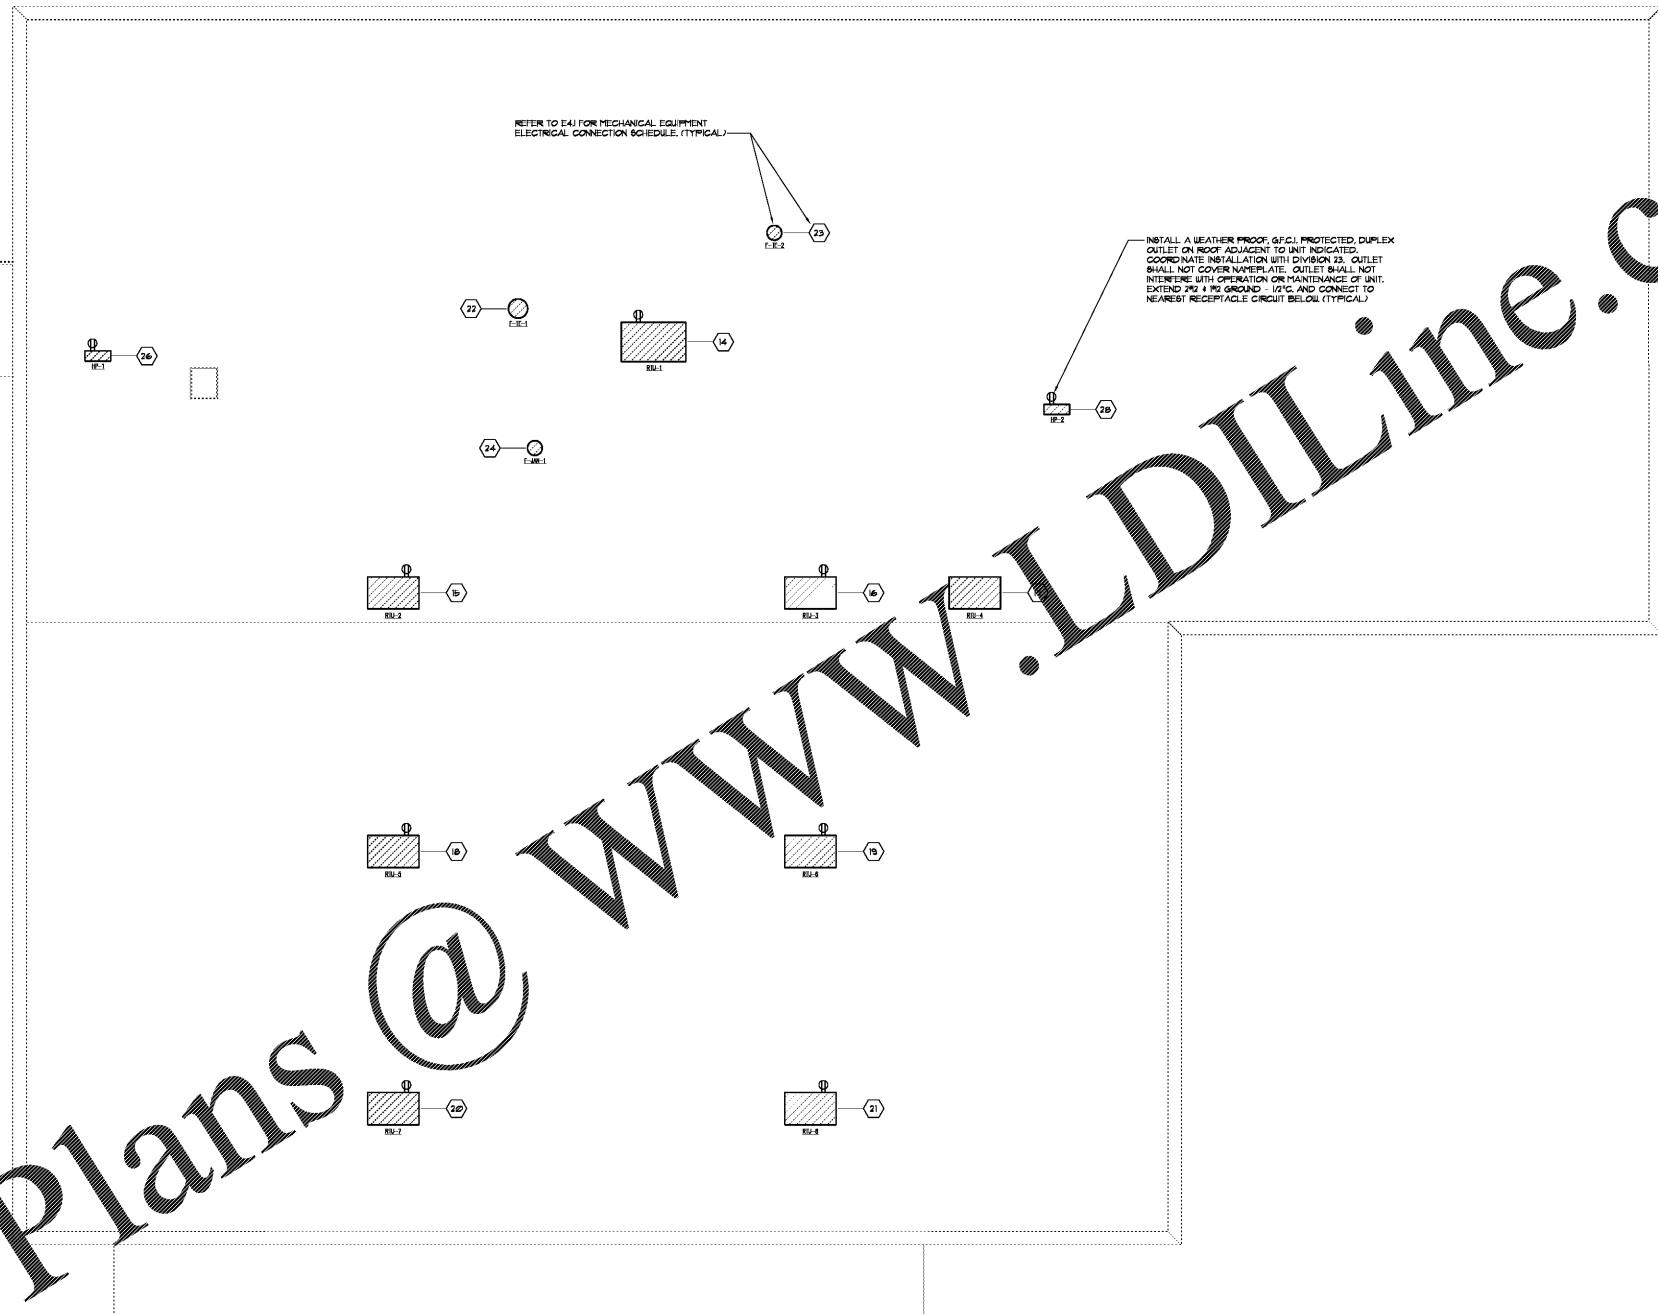

1 ROOF PLAN - ELECTRICAL
E1.2 SCALE: 1/8" = 1'-0"

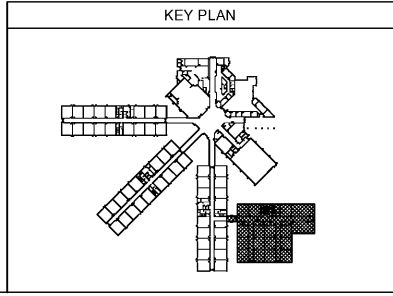

BAA
Breux & Associates
ARCHITECTS

6965 Shiloh Road East, Suite 200
Alpharetta, Georgia 30005 (678) 585-4508



MATHIS & ROBERTS CONSULTING ENGINEERS

3408 LINDSEY ROAD, SUITE 6
DALLAS, TEXAS 75248-1460
TELEPHONE 772-238-1460

NO.	DESCRIPTION	DATE

RUSSOM ELEMENTARY SCHOOL
ADDITION
44 RUSOM ELEMENTARY SCHOOL LANE
DALLAS, GA 30132
(FACILITY CODE: 710-0204)

PAULDING COUNTY SCHOOLS

ROOF PLAN - ELECTRICAL

DATE 03/06/2020
PROJECT NO. 19117

E1.2