



Order Plans @ www.dellme.com

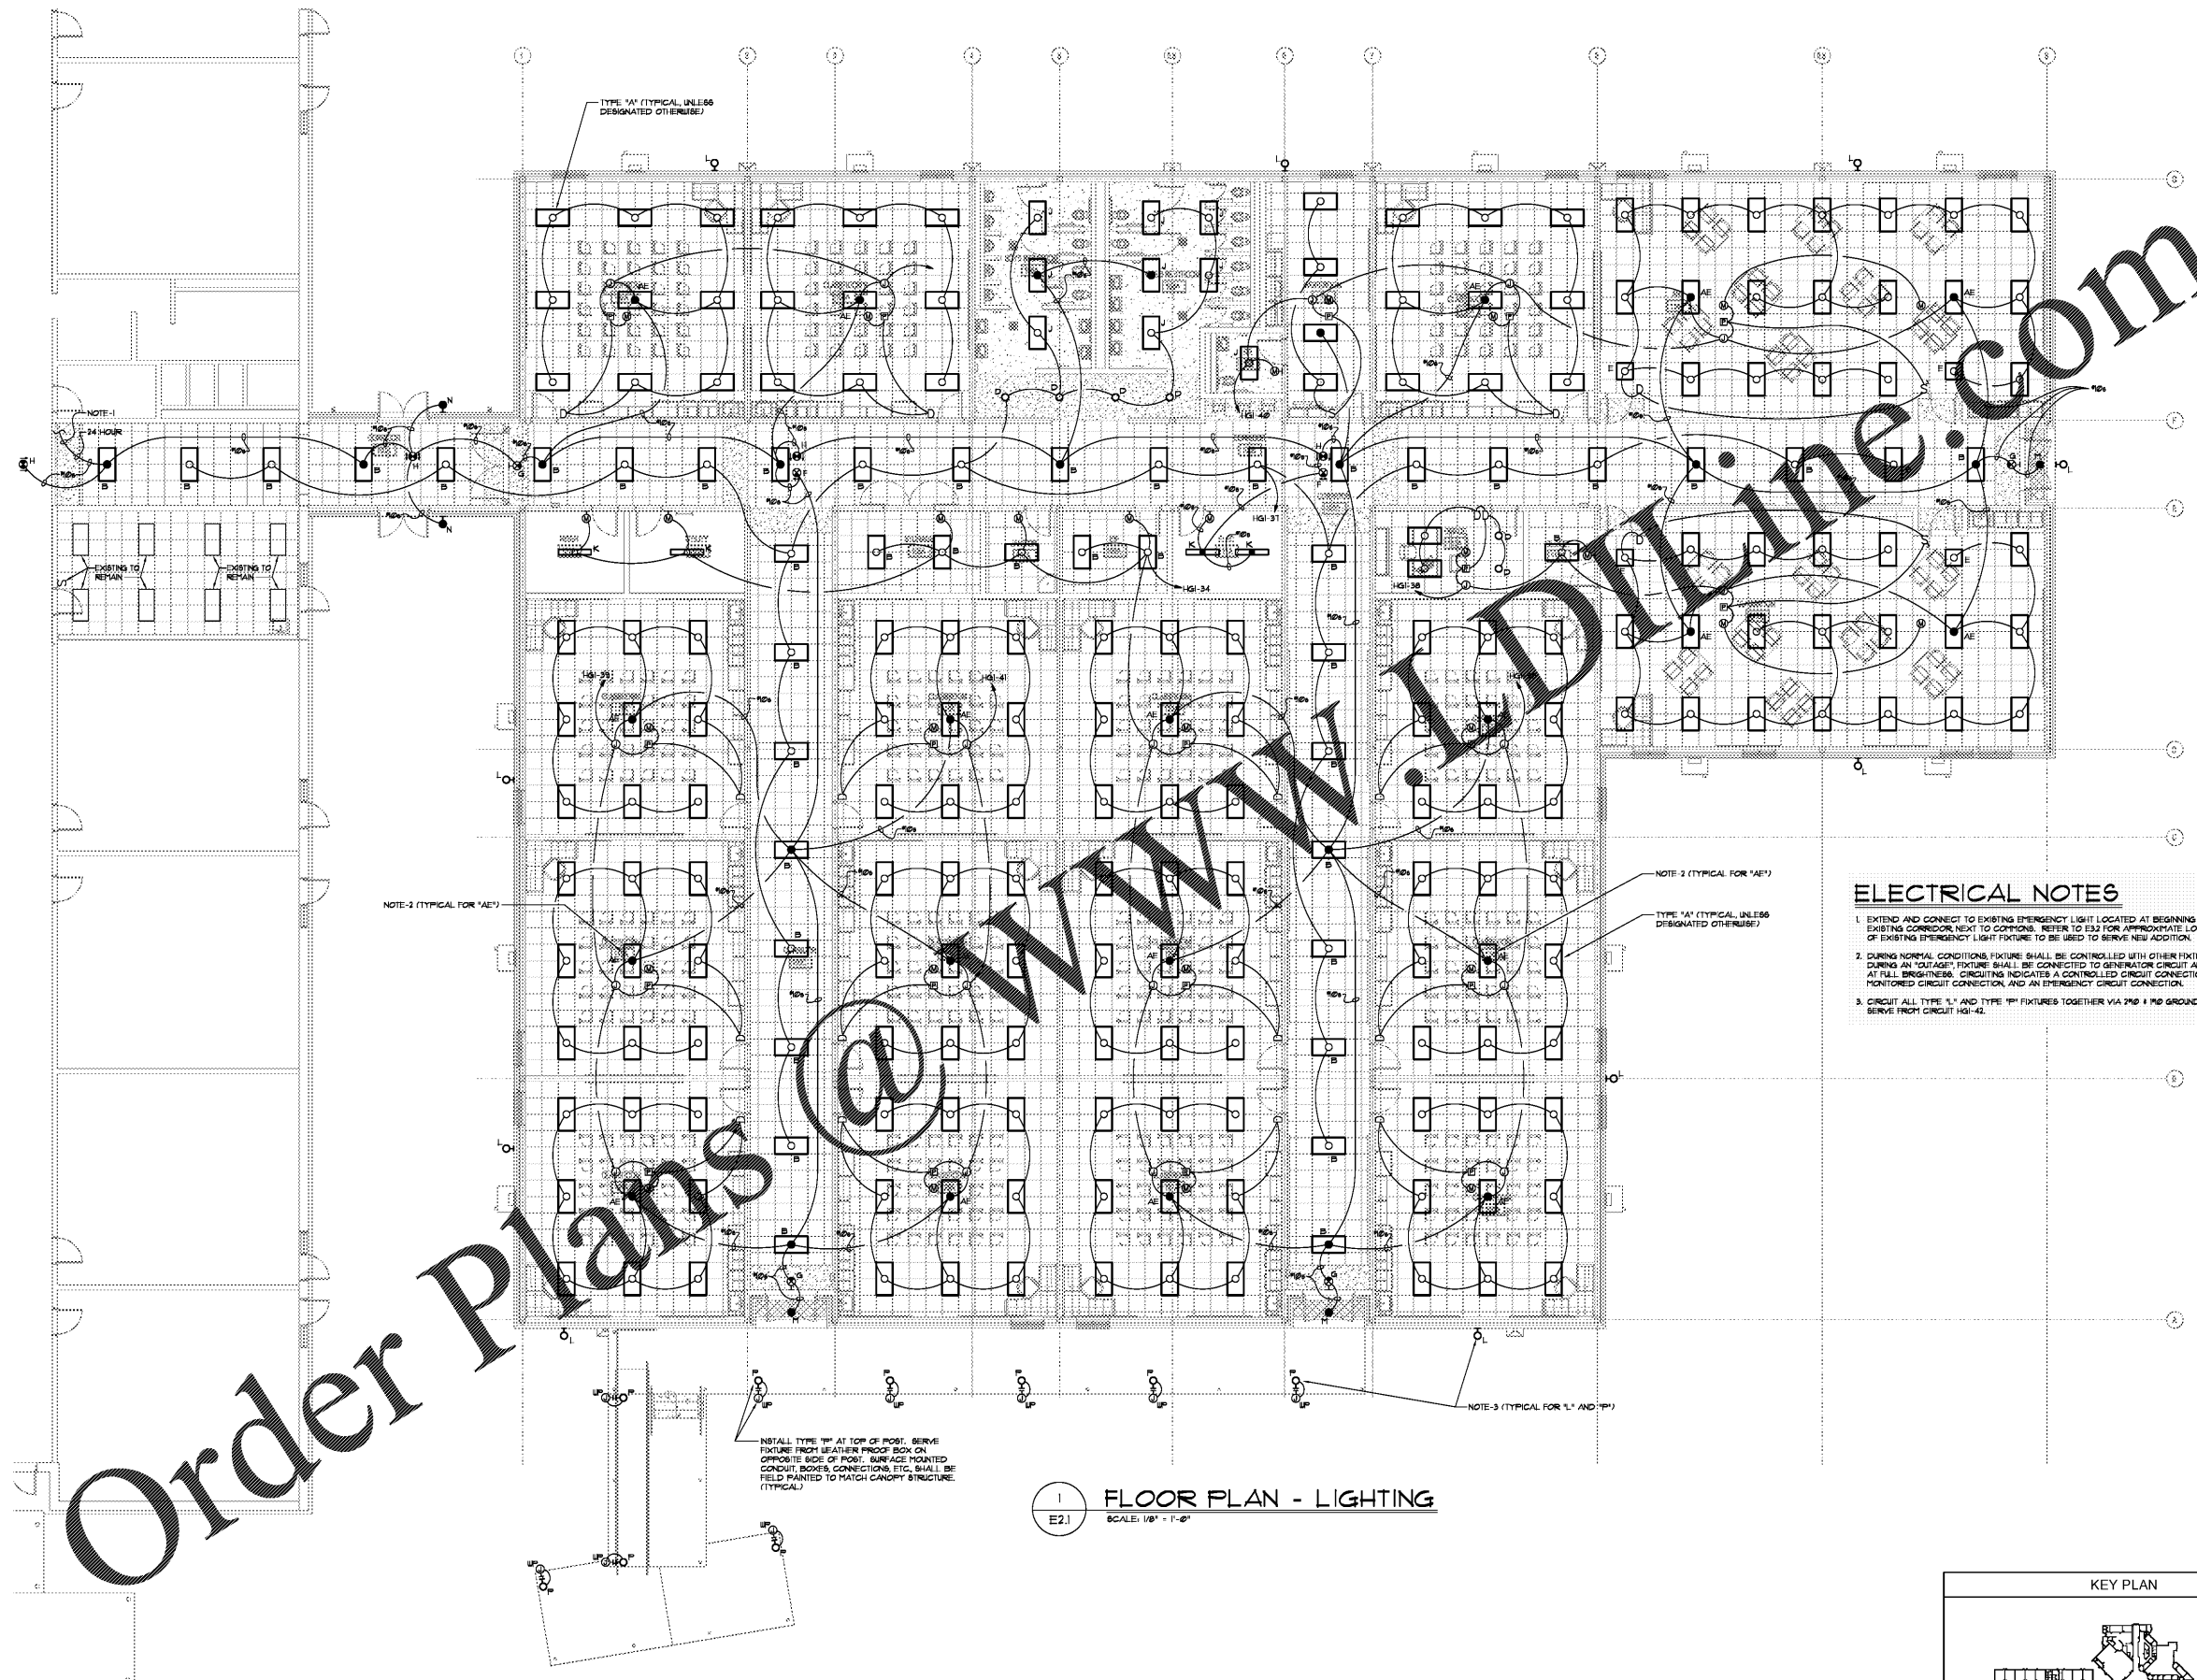

- ELECTRICAL NOTES**
1. EXTEND AND CONNECT TO EXISTING EMERGENCY LIGHT LOCATED AT BEGINNING OF EXISTING CORRIDOR NEXT TO COMMONS. REFER TO E32 FOR APPROXIMATE LOCATION OF EXISTING EMERGENCY LIGHT FIXTURE TO BE USED TO SERVE NEW ADDITION.
 2. DURING NORMAL CONDITIONS, FIXTURE SHALL BE CONTROLLED WITH OTHER FIXTURES. DURING AN OUTAGE, FIXTURE SHALL BE CONNECTED TO GENERATOR CIRCUIT AND BE AT FULL BRIGHTNESS. CIRCUITING INDICATES A CONTROLLED CIRCUIT CONNECTION, MONITORED CIRCUIT CONNECTION, AND AN EMERGENCY CIRCUIT CONNECTION.
 3. CIRCUIT ALL TYPE "L" AND TYPE "M" FIXTURES TOGETHER VIA #10 GROUND - 1/2". SERVE FROM CIRCUIT H&I-42.

1 FLOOR PLAN - LIGHTING
 E2.1 SCALE: 1/8" = 1'-0"

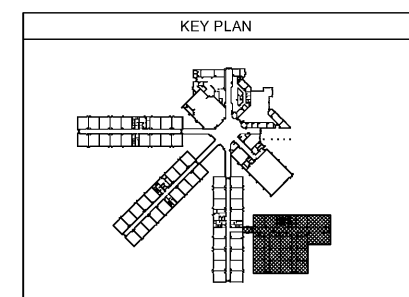

NO.	DESCRIPTION	DATE

RUSSOM ELEMENTARY SCHOOL
 ADDITION
 44 RUSOM ELEMENTARY SCHOOL LANE
 DALLAS, GA 30132
 (FACILITY CODE: 710-0204)
 PAULDING COUNTY SCHOOLS

FLOOR PLAN - LIGHTING

DATE 03/06/2020
 PROJECT NO. 19117

E2.1

BXA
 Breaux & Associates
 ARCHITECTS
 6965 Shiloh Road East, Suite 200
 Alpharetta, Georgia 30005 | (770) 385-4508



MATHIS & ROBERTS
 CONSULTING
 ENGINEERS
 3400 BELL ROAD, SUITE 6
 DALLAS, TX 75244
 TELEPHONE 772-238160