


Order Plans @ WWW.LDLINE.COM

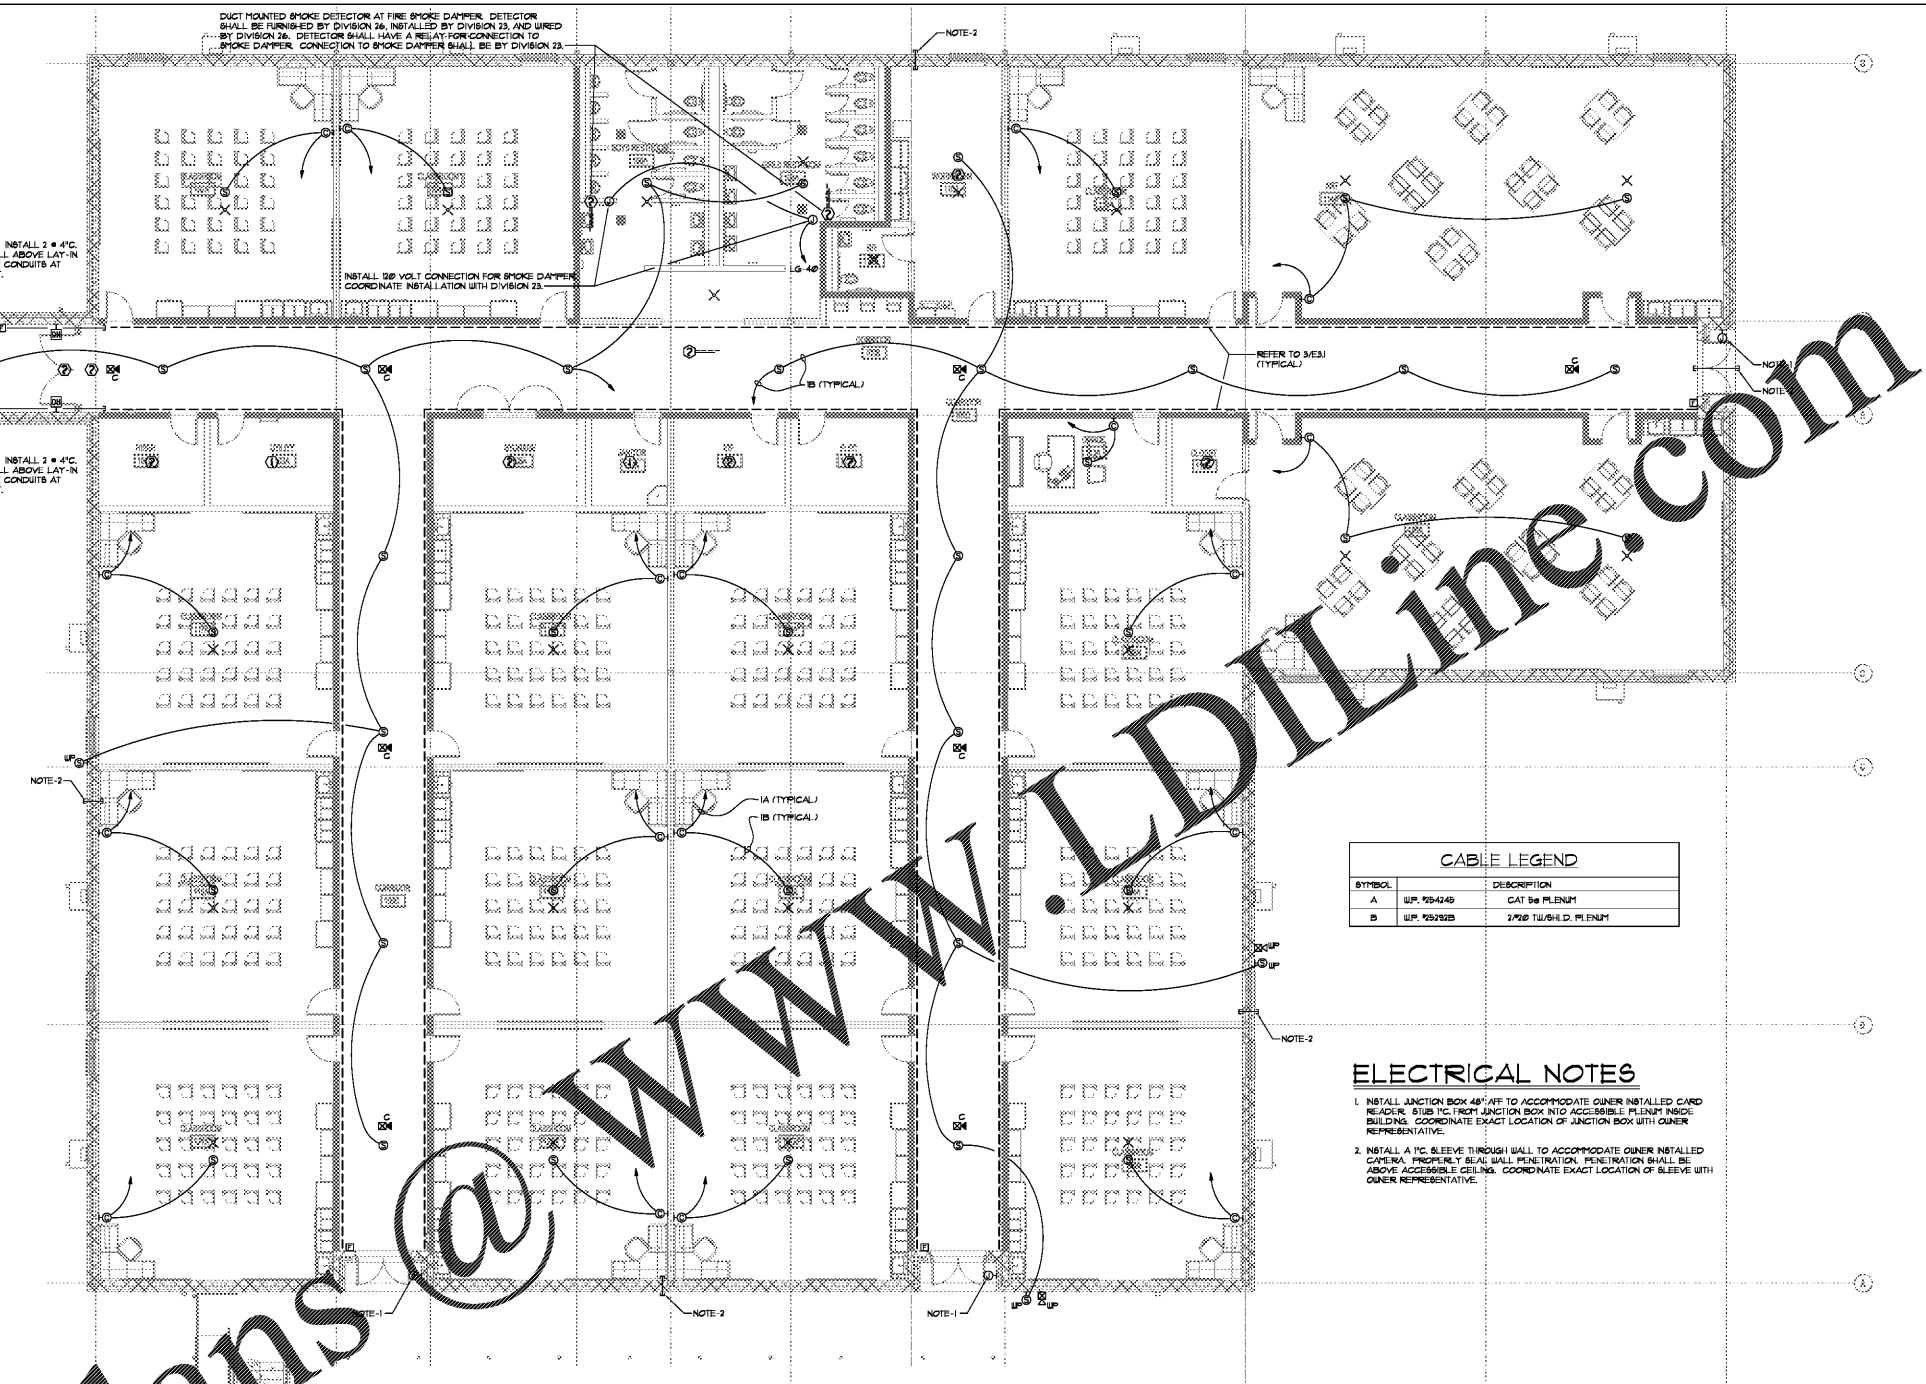




SYMBOL	DESCRIPTION
A	3/4" P. 95424B CAT 5e PLFNH
B	3/4" P. 95252B 2/50 T4/54LD PLFNH

- ELECTRICAL NOTES**
- INSTALL JUNCTION BOX 48" AFF TO ACCOMMODATE OWNER INSTALLED CARD READER. STUD TYP FROM JUNCTION BOX INTO ACCESSIBLE FLEINH INSIDE BUILDING. COORDINATE EXACT LOCATION OF JUNCTION BOX WITH OWNER REPRESENTATIVE.
 - INSTALL A T/C SLEEVE THROUGH WALL TO ACCOMMODATE OWNER INSTALLED CAMERA. PROPERLY SEAL WALL PENETRATION. PENETRATION SHALL BE ABOVE ACCESSIBLE CEILING. COORDINATE EXACT LOCATION OF SLEEVE WITH OWNER REPRESENTATIVE.

1 FLOOR PLAN - SYSTEMS
SCALE: 1/8" = 1'-0"

2 CONCRETE WALL PENETRATION DETAIL
NOT TO SCALE

3 J-HOOK DETAIL
NOT TO SCALE

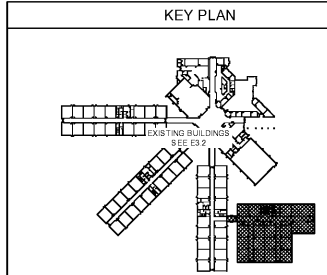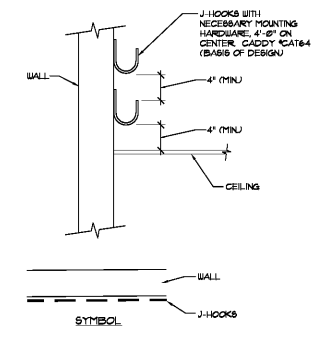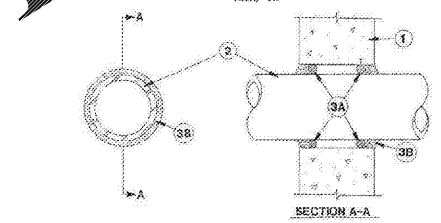

MATHIS & ROBERTS CONSULTING ENGINEERS
3400 ELLIOTT ROAD SUITE 6
DALLAS, TEXAS 75246
TELEPHONE 772-238-1460

ID	DESCRIPTION	DATE

RUSSOM ELEMENTARY SCHOOL ADDITION
44 RUSSOM ELEMENTARY SCHOOL LANE
DALLAS, GA 30132
(FACILITY CODE: 710-0204)
PAULDING COUNTY SCHOOLS

FLOOR PLAN - SYSTEMS

DATE 03/06/2020
PROJECT NO. 19117
E3.1