


5700 BUILDING: INTERIOR RENOVATION

951 EASTGATE LOOP CHATTANOOGA, TN 37411

PERMIT SET

PERMIT SET: 20 MAR 2020

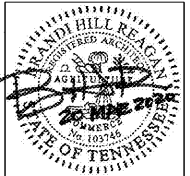

bloom
architecture
400 E. Main Street, #215 | Chattanooga, TN 37409
design@bloom.co | 423-505-1951


NOTES FOR ALTERNATES

PROVIDE ALTERNATE PRICING FOR THE FOLLOWING:

- ADD ALTERNATE #1:
SS-1 IN LIEU OF PL-2 AT COUNTERS NOTED IN THE INTERIOR ELEVATIONS, NAMELY CONFERENCE ROOM, BREAKROOM, AND CLASSROOM.

- ADD ALTERNATE #2:
PROVIDE ALTERNATE PRICING FROM D-1 TO D-3 DOORS AS NOTED IN THE DOOR SCHEDULE.

Order Plans @ WWW.LDILine.com

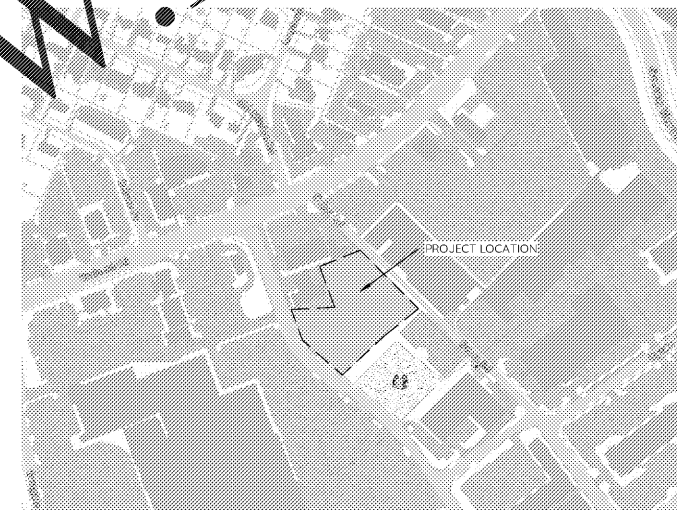

1 VICINITY MAP
1" = 300'-0"

DRAWING LIST	
SHEET NUMBER	SHEET NAME
A000	COVER
A001	ABBREVIATIONS + GENERAL NOTES
A002	CODE SUMMARY
A010	LIFE SAFETY PLAN
A011	ADA DETAILS
A100D	DEMOLITION PLANS
A101	OVERALL FLOOR PLAN
A102	OVERALL ROOF PLAN
A111	FLOOR PLAN - WEST SIDE
A112	FLOOR PLAN - EAST SIDE
A131	OVERALL CEILING PLAN
A141	CEILING PLAN - WEST SIDE
A142	CEILING PLAN - EAST SIDE
A401	RESTROOMS - PLANS + ELEV'S
A601	SCHEDULES - DOOR, WINDOW, WALL
A602	SCHEDULE - FINISH
A701	INTERIOR ELEVATIONS
M101	HVAC FLOOR PLAN
M102	HVAC SCHEDULES AND DETAILS
M103	HVAC DEMOLITION PLAN
E100	ELECTRICAL LEGENDS, NOTES, & SCHEDULES
E101	ELECTRICAL POWER & SYSTEMS / HVAC POWER PLAN
E102	ELECTRICAL LIGHTING/ FIRE ALARM PLAN
E103	ELECTRICAL PANELS, RISER DIAGRAM, & NOTES
P101	WASTE & VENT PIPING PLAN
P102	DOMESTIC WATER PIPING PLAN
P201	PLUMBING DETAILS & SCHEDULES

PROJECT INFORMATION			
PROJECT NAME	5700 BUILDING: INTERIOR RENOVATION	JURISDICTION	CITY OF CHATTANOOGA, TENNESSEE
PROJECT ADDRESS	951 EASTGATE LOOP CHATTANOOGA, TN 37411	GOVERNING CODES	2012 INTERNATIONAL BUILDING CODE; 2012 NATIONAL ELECTRIC CODE; 2012 INTERNATIONAL FIRE CODE; 2012 INTERNATIONAL MECHANICAL CODE; 2012 INTERNATIONAL FUEL GAS CODE; 2012 INTERNATIONAL PLUMBING CODE; 2012 INTERNATIONAL ENERGY CONSERVATION CODE; 2009 ANSI/ICC A117.1 ACCESSIBILITY CODE
CLIENT NAME	OBC PROPERTIES DELAWARE, LLC (MICHAEL FULLAM)	PROJECT SCOPE	PROJECT CONSISTS OF THE INTERIOR RENOVATION OF 9,550 SF WITHIN AN EXISTING BUILDING OF 26,900 SF FOR CHOICES PREGNANCY RESOURCE CENTER. RENOVATION TO INCLUDE THE ADDITION OF OFFICES, EXAM ROOMS, AND RESTROOMS.
CLIENT ADDRESS + PHONE	OBC PROPERTIES DELAWARE, LLC P.O. BOX 1298 CHATTANOOGA, TN 37401 423-605-0173 (MICHAEL FULLAM)		

DESIGN TEAM INFORMATION						
ARCHITECT	CIVIL ENGINEER	STRUCTURAL ENGINEER	MECH/ELEC/PLUM/FIRE PROTECTION ENGINEER	LANDSCAPE ARCHITECT	INTERIOR DESIGN	CONTRACTOR
BLOOM ARCHITECTURE LLC Brandon Hill Reagan brandon@designwithbloom.co 423-505-1951			CAMPBELL & ASSOCIATES Matt Williams mattw@cae-grs.com 423-267-9716			

5700 BUILDING: INTERIOR RENOVATION
951 EASTGATE LOOP CHATTANOOGA, TN 37411

No.	Description	Date

Project #: 19161
20 MAR 2020
COVER
A000

PERMIT SET