


**ELECTRICAL POWER & SYSTEMS PLAN**

SCALE: 1/8" = 1'-0"

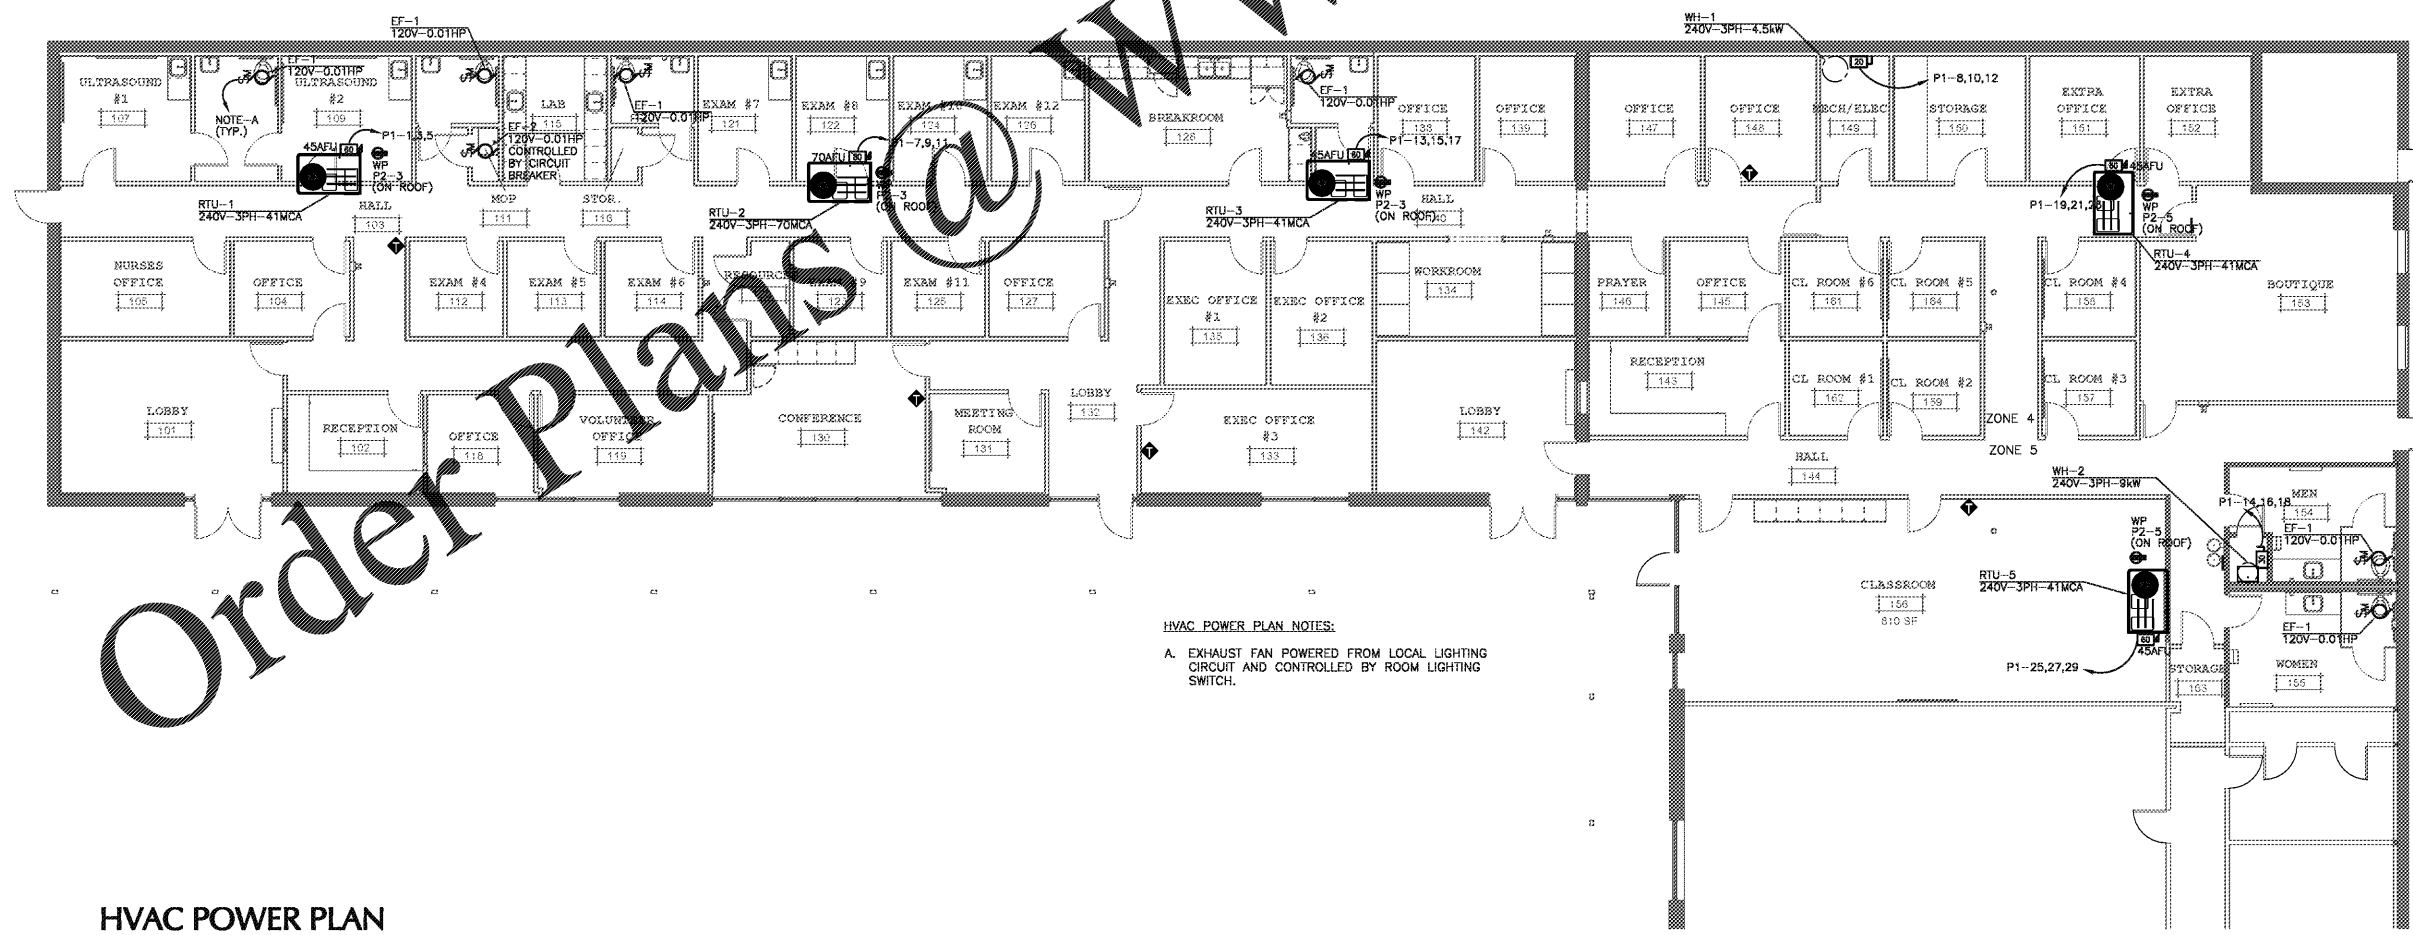

**HVAC POWER PLAN**

SCALE: 1/8" = 1'-0"



**bloom architecture**  
 400 E. Main Street, #215 Chattanooga, TN 37408  
 design@bloomarch.com | 423-503-4951

**5700 BUILDING: INTERIOR RENOVATION**  
 951 EASTGATE LOOP CHATTANOOGA, TN 37411

No.	Description	Date

PERMIT DOCUMENTS  
 Project # 19161  
 20 MAR 2020  
 ELECTRICAL POWER & HVAC SYSTEMS / HVAC POWER PLAN  
**E101**

C:\Users\abrown\OneDrive\Projects\1916 5700 Choices\02\_BIM\5700choices\_DD\21.vr