




bloom
architecture
400 E. Main Street, #215 | Chattanooga, TN 37408
design@bloom.co | 423-303-1951

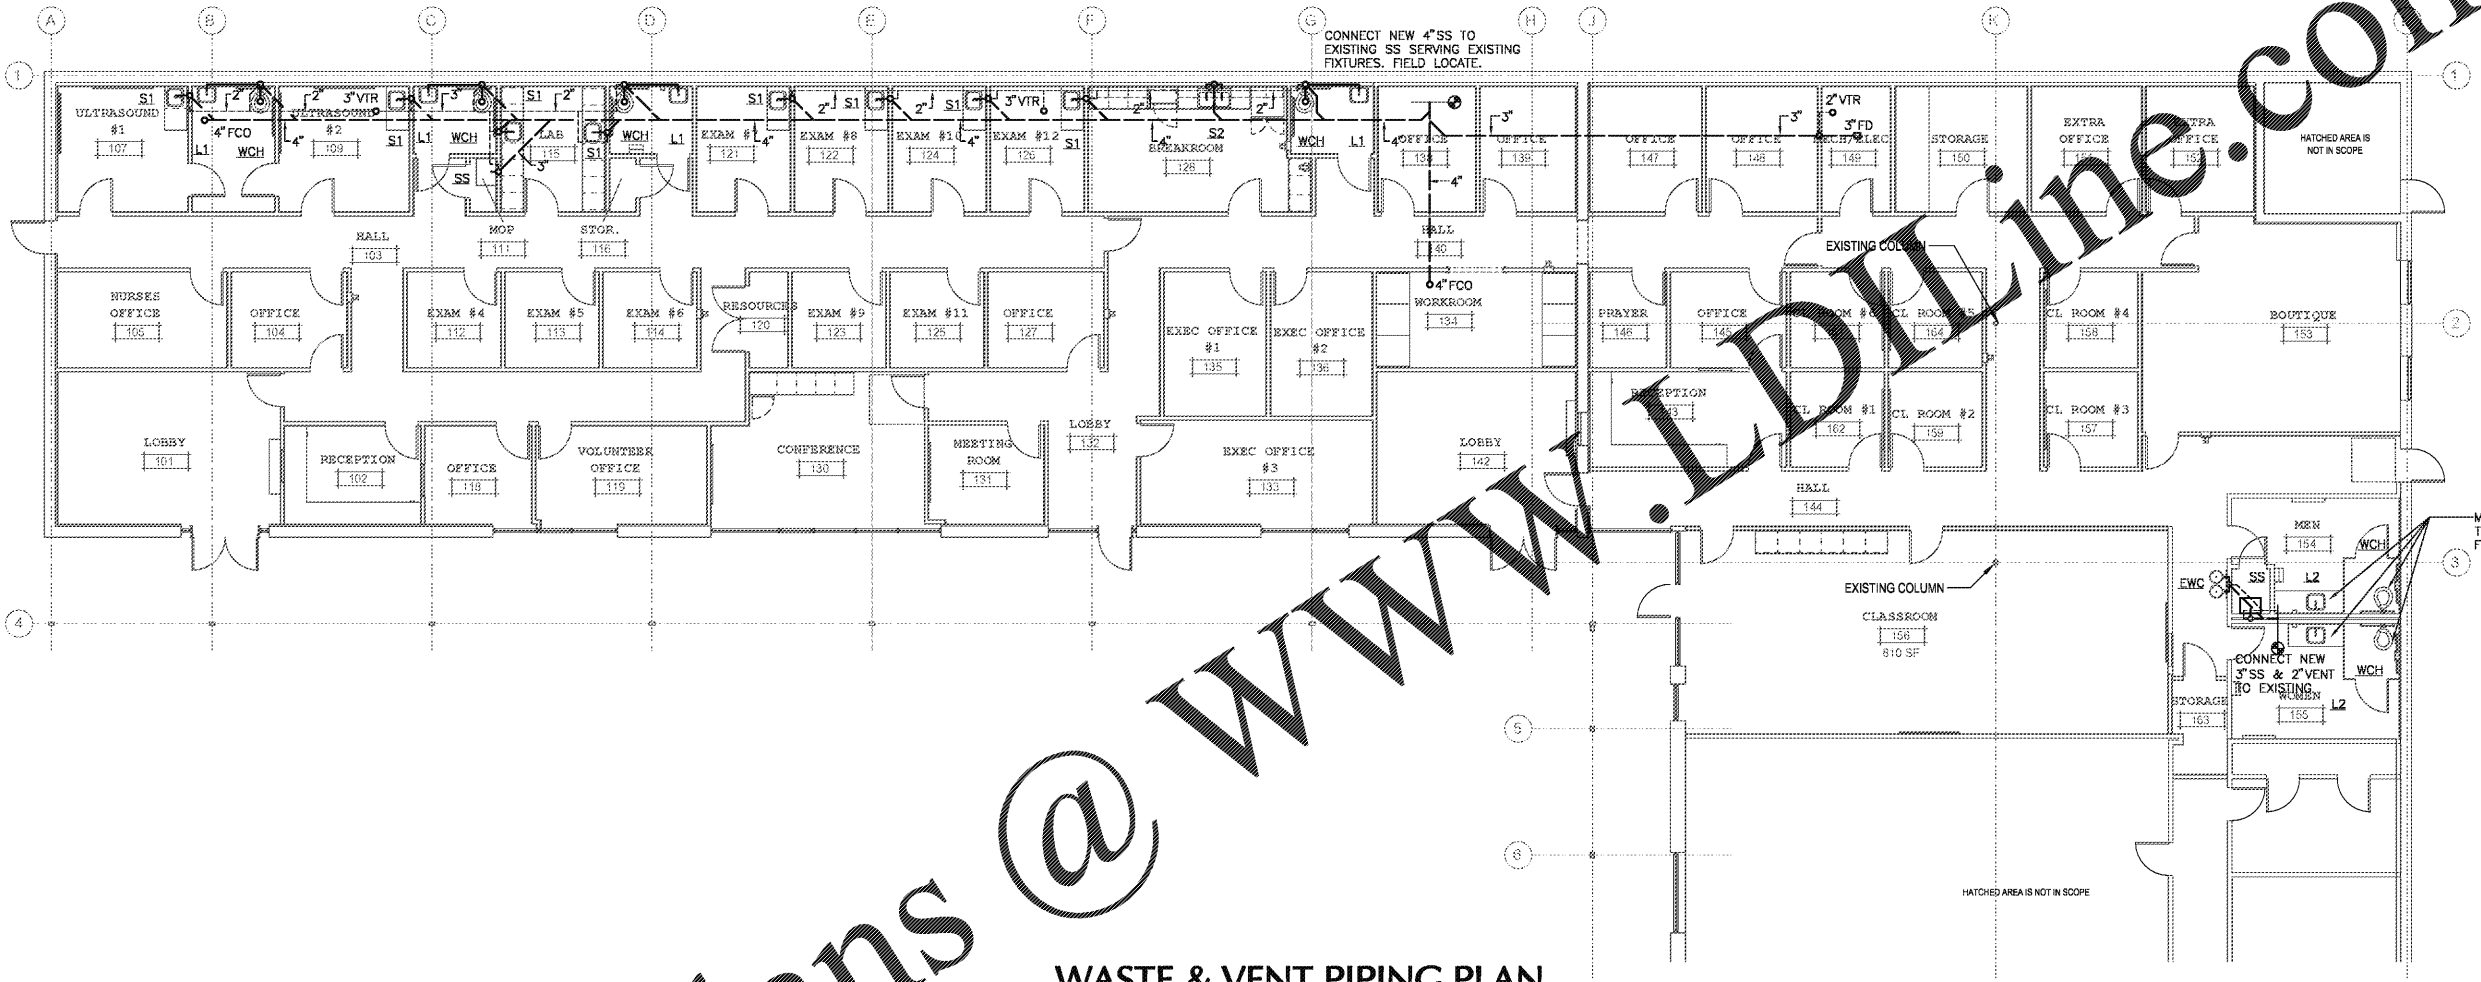

WASTE & VENT PIPING PLAN

SCALE: 1/8" = 1'-0"

Order Plans @ www.LDOnline.com

**5700 BUILDING: INTERIOR
RENOVATION**

951 EASTGATE LOOP CHATTANOOGA, TN 37411

No.	Description	Date

Project # 19161
20 MAR 2020
WASTE & VENT
PIPING PLAN

P101

PERMIT DOCUMENTS