


bloom
architecture
400 E. Main Street, #215 | Chattanooga, TN 37408
design@bloomco.com | 423-303-1951

**5700 BUILDING: INTERIOR
RENOVATION**
951 EASTGATE LOOP CHATTANOOGA, TN 37411

No.	Description	Date


PERMIT DOCUMENTS
Project # 19161
20 MAR 2020
DOMESTIC WATER PIPING PLAN
P102

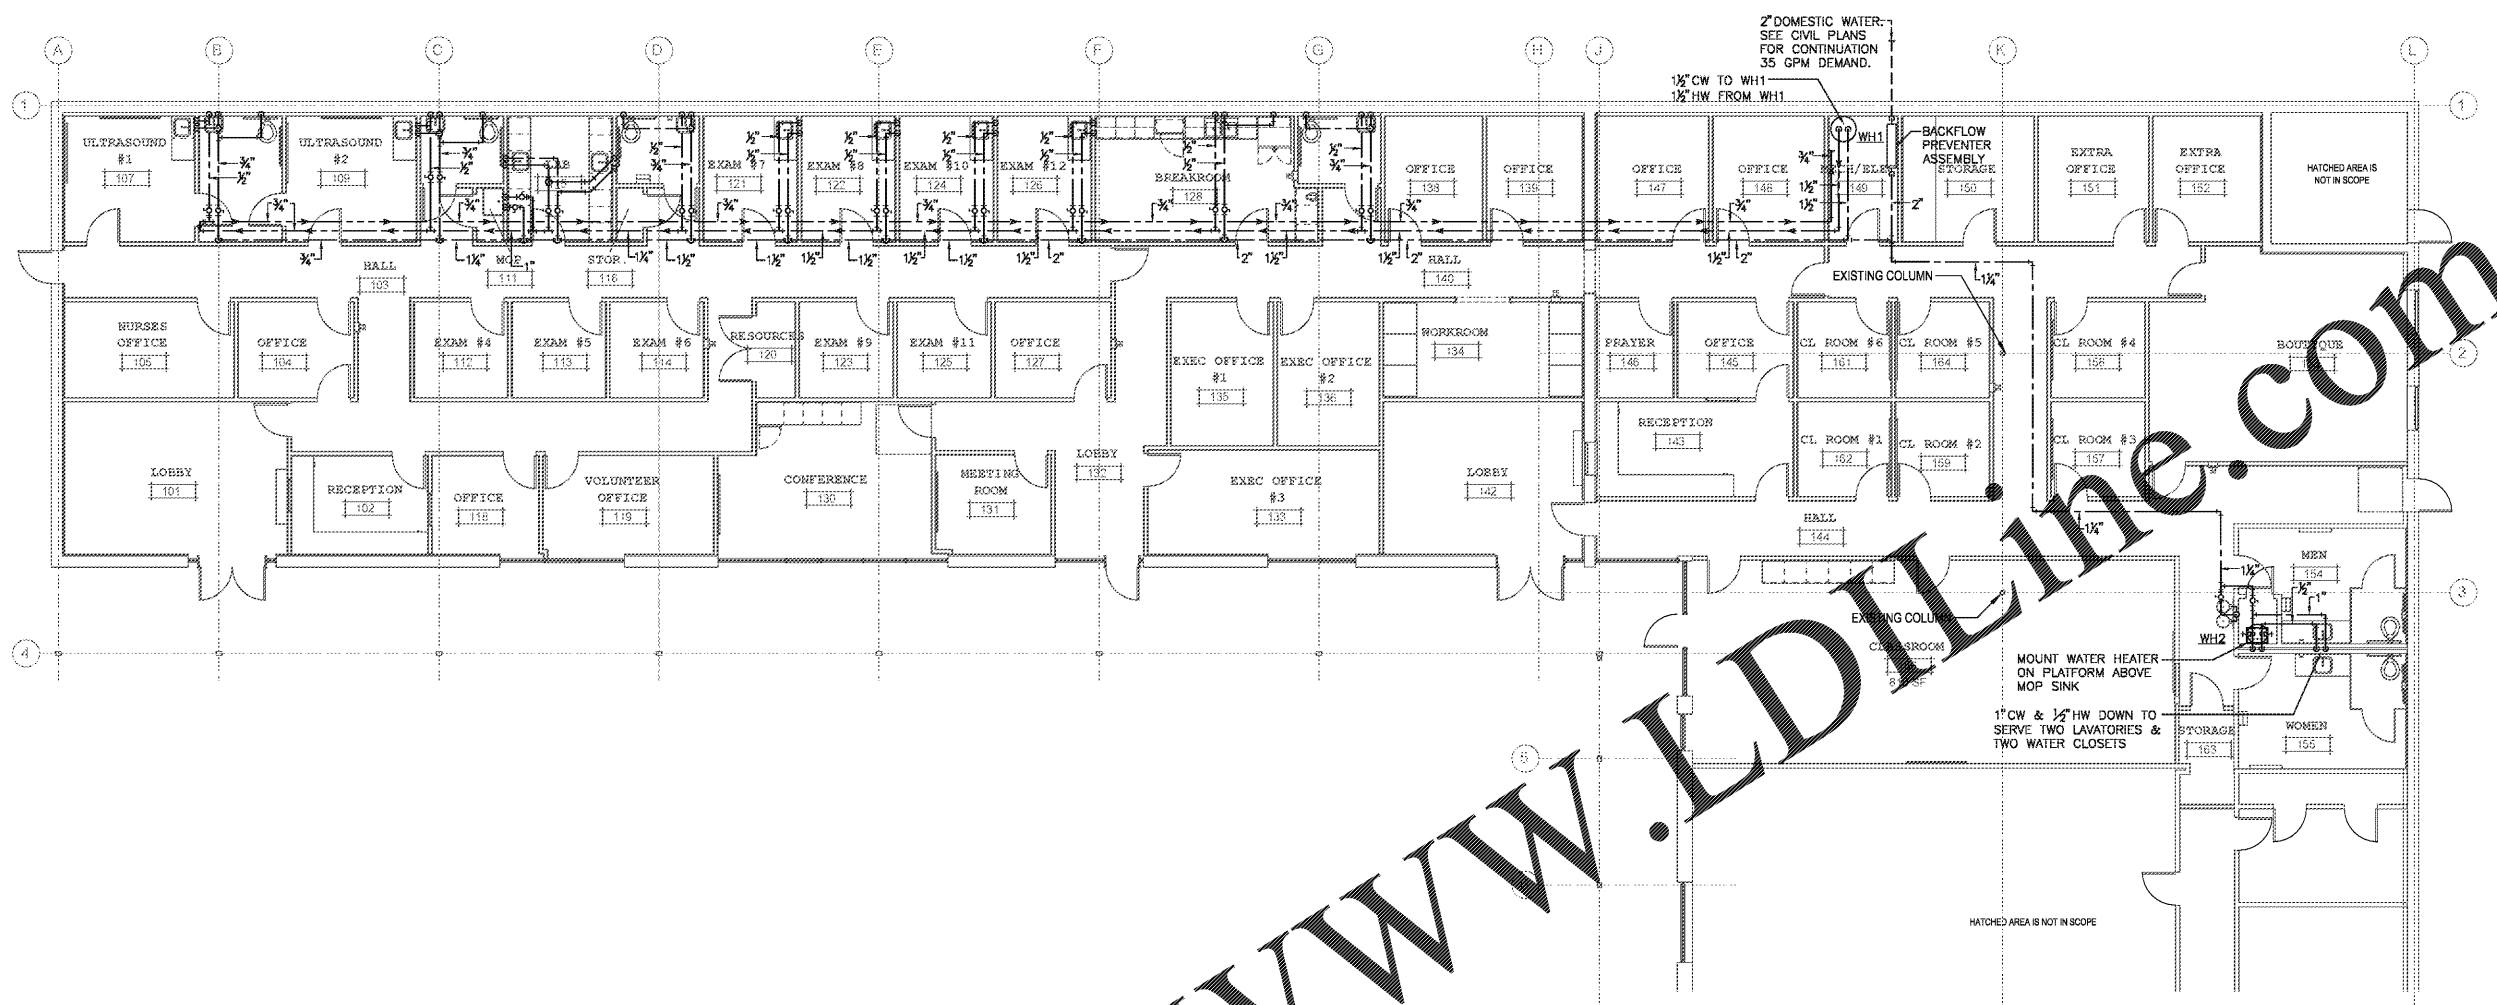

DOMESTIC WATER PIPING PLAN

SCALE: 1/8" = 1'

Order Plans @ www.LDOnline.com

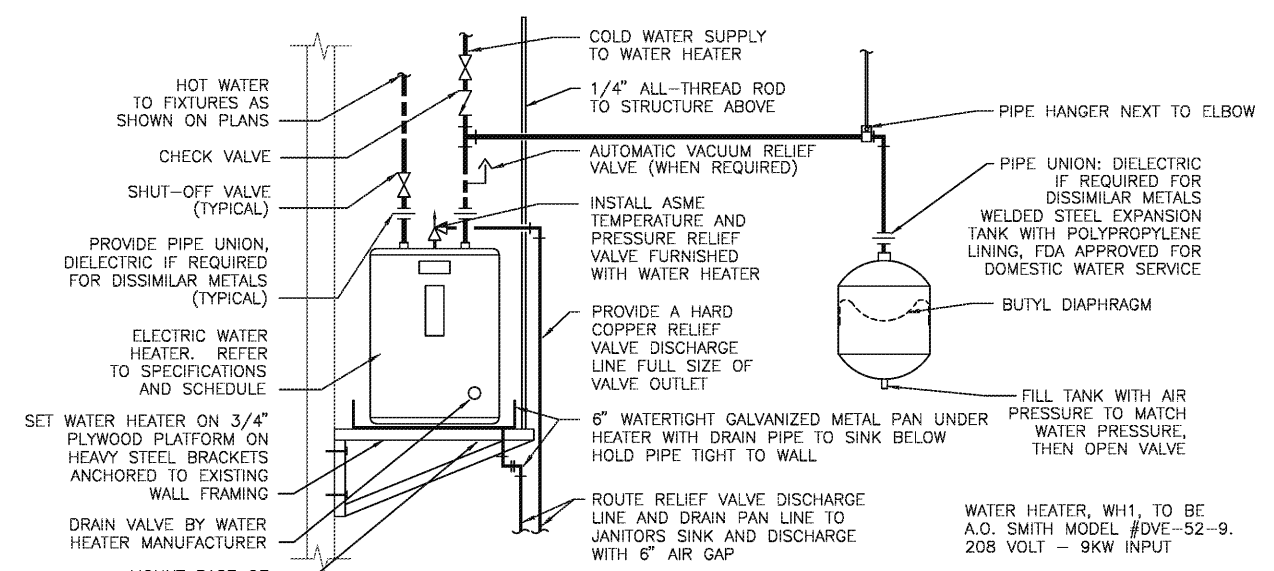

REFER TO SPECIFICATIONS, SCHEDULES AND NOTES FOR MORE INFORMATION. PIPING ARRANGEMENT SHOWN IS SCHEMATIC. VERIFY ALL CONNECTION SIZES AND LOCATIONS PER MANUFACTURERS REQUIREMENTS. ADJUST TO SUIT FIELD CONDITIONS. REFER TO FLOOR PLANS FOR PIPE SIZES. PROVIDE SEISMIC STRAP OR BRACING IF/AS REQUIRED BY LOCAL AUTHORITIES. PROVIDE HEAT TRAP AND AUTOMATIC VACUUM RELIEF VALVE WHEN REQUIRED BY LOCAL AUTHORITIES.

SHELF MOUNTED WATER HEATER
NOT TO SCALE

C:\Users\brand\Dropbox\3-Bloom\1-projects\19161\5700 Choices\02_BIM\5700choices DDV2.rvt