


Order plans @

WWW.LDILLINE.COM

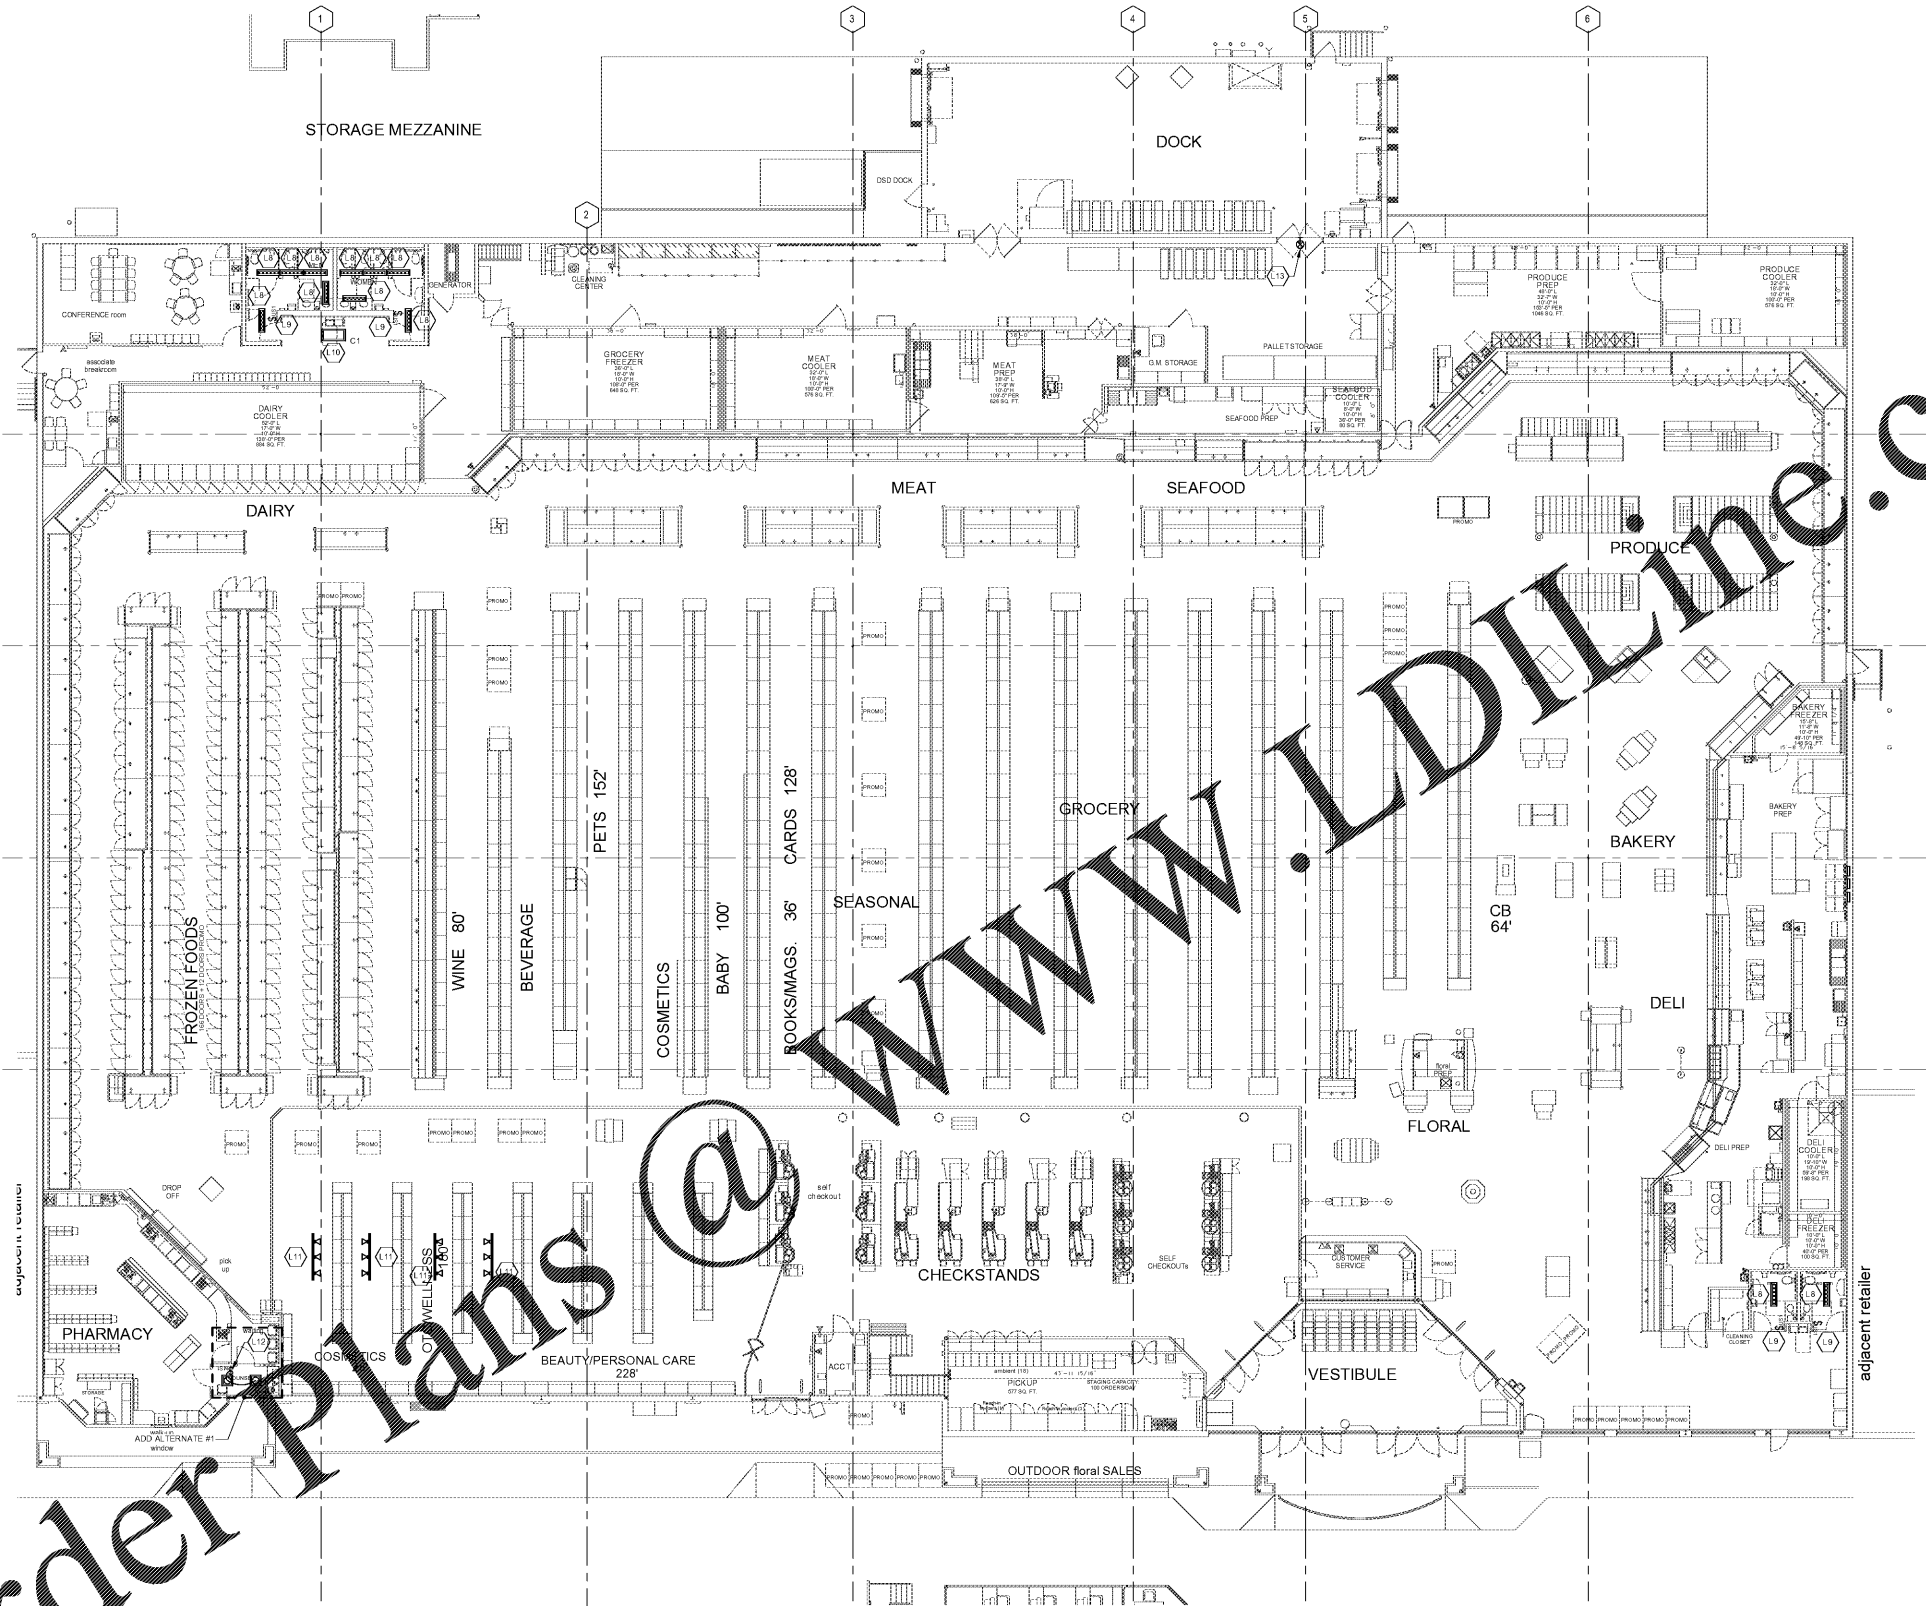

1 LIGHTING PLAN
 3/32" = 1'-0"

Key Value	Key Note Text
LB	CONNECT NEW LIGHTING FIXTURE TO EXISTING LIGHTING CIRCUIT
LR	NEW OCCUPANCY SENSOR FOR CONTROL OF RESTROOM LIGHTING AND EXHAUST FAN. SEE ESD-29 FOR WIRING INFORMATION
L33	INSTALL NEW LIGHT FIXTURE IN EXISTING GRID. CONNECT TO LIGHTING CIRCUIT SERVING THIS AREA
L11	EXISTING TRACK LIGHTS TO BE RELOCATED WITH TRELLIS. EXTEND CIRCUIT TO NEW LOCATION. COORDINATE LOCATION AND REQUIREMENTS WITH KROGER PROJECT MANAGER
L12	NEW MOTION SENSOR TO CONTROL EXISTING DOWN LIGHTS IN PHARMACY COUNSEL ROOM
L13	NEW PHOTOLUMINESCENT EXIT SIGN. COORDINATE REQUIREMENTS WITH KROGER PROJECT MANAGER

- NO SURFACE MOUNTED CONDUIT OR PIPING ALLOWED IN MEAT AND PRODUCE PREP ROOMS.
- REFER TO SHEET E01 FOR LEGENDS, NOTES, AND SCHEDULES.
- AT MECHANICAL CHASES AND STORES WITHOUT CEILING IN SALES AREA, GROUP VERTICAL PIPING (REFRIGERATION, ELECTRICAL CONDUIT AND MECHANICAL DROPS) NEARLY TOGETHER AS POSSIBLE AND PAINT TO MATCH STRUCTURAL COLUMNS.
- NO ELECTRICAL EQUIPMENT SHALL BE LOCATED UNDERNEATH THE SKYLIGHTS INCLUDING BUT NOT LIMITED TO CONDUIT, LIGHTS, CABLES FOR SIGNAGE, ETC.
- REFER TO ESD-50 FOR LED TRACK LIGHT AND MONDPOINT DETAIL.
- RUN CONDUITS ON TOP OF INSULATED ROOF PANEL. SUB THRU PANEL INTO FIXTURES FOR PREP ROOM LIGHTING.
- THE ONLY SURFACE MOUNTED CONDUIT PERMITTED IN THE DELI AND BAKERY PREP ROOMS SHALL BE ON THEIR COOLER AND FREEZER WALL AND CEILING.
- REFER TO ES SERIES SHEETS FOR ELECTRICAL STANDARD DETAILS (ESDs).
- ALL CONDUITS IN SALES AREA FROM ROOF TO LOW WALLS OR EQUIPMENT SHALL BE COORDINATED AND GROUPED TOGETHER WITH OTHER MECHANICAL CONDUITS.

ROBERTSON LOJA ROOF ARCHITECTS & ENGINEERS
 3460 Preston Ridge Road - Suite 275 - Alpharetta, GA 30005
 770.674.2007 www.rlr.com



Kroger GA-464
 4015 W. Peachtree Dunwoody Rd.
 Atlanta, Georgia 30126
The Kroger Company
 2175 Park Lake Drive, Atlanta, GA

REVISIONS

NO.	DESCRIPTION

LIGHTING PLAN

DATE: 02-12-20

PROJECT NUMBER: 20-107

SHEET NUMBER: **E1.1**