


LIGHT FIXTURE SCHEDULE									
TYPE	MANUF.	CATALOG No.	MOUNTING	LAMPS		VOLTAGE	INPUT W	REMARKS	NOTES
				#	TYPE				
A1,A1E	LITHONIA	EPANL 2X4 3000LM 80CRI 49K MIN1 ZT MVOLT	RECESSED	-	LED	120/277	27.4	2'x4' LED RECESSED TROFFER. EMERGENCY BATTERY BACKUP FOR A1E	-
B1,B1E	LITHONIA	EPANL 2X2 2000LM 80CRI 49K MIN1 ZT MVOLT	RECESSED	-	LED	120/277	19.6	2'x2' LED RECESSED TROFFER. EMERGENCY BATTERY BACKUP FOR B1E	-
C1	LITHONIA	CDS L96 MVOLT DM 40K 80CRI WH	SURFACE	-	LED	120	73	96" APERTURE LED RECESSED LINEAR FIXTURE.	-
D1, D1E	LITHONIA	LDN6 40'20' L06 AR LS MVOLT EZ1 (EL)	RECESSED	-	LED	120/277	22.5	8" LEG DOWNLIGHT. EMERGENCY BATTERY BACKUP FOR D1E	-
D2, D2E	LITHONIA	LDN6 40'15' L06 AR LS MVOLT EZ1 (EL)	RECESSED	-	LED	120/277	17.5	8" LEG DOWNLIGHT. EMERGENCY BATTERY BACKUP FOR D2E	-
D3, D3E	LITHONIA	LDN4 40'05' L04 AR LS MVOLT EZ1 (EL)	RECESSED	-	LED	120/277	5.8	4" LEG DOWNLIGHT. EMERGENCY BATTERY BACKUP FOR D3E	-
P1	OWNER PROVIDED / CONTRACTOR INSTALLED		PENDANT	-	-	120	-	DECORATIVE LED PENDANT LIGHT. \$500.00 ALLOWANCE. RETURN ANY CREDIT BACK TO OWNER.	-
P2	OWNER PROVIDED / CONTRACTOR INSTALLED		PENDANT	-	-	120	-	DECORATIVE LED PENDANT LIGHT. \$200.00 ALLOWANCE. RETURN ANY CREDIT BACK TO OWNER.	-
P3	OWNER PROVIDED / CONTRACTOR INSTALLED		PENDANT	-	-	120	-	DECORATIVE LED PENDANT LIGHT. \$500.00 ALLOWANCE. RETURN ANY CREDIT BACK TO OWNER.	-
U1	LITHONIA	UCEL 24IN 40K 80CRI WH	SURFACE	-	LED	120	11	24" LED UNDERCABINET LIGHT.	-
V1	LITHONIA	FMVCSL 24IN MVOLT 30K 80CRI XX	WALL	-	LED	120/277	18	24" LED VANITY. COORDINATE FINISH WITH ARCHITECT.	-
X1	LITHONIA	LQM S W 3 R 120/277 EL N SD	WALL / CEILING	-	LED	120/277	-	LED EXIT SIGN WITH EMERGENCY BATTERY BACKUP AND SELF-DIAGNOSTICS	-

* PROVIDE EMERGENCY BATTERY OPTION FOR ALL "E" SUFFIXED FIXTURES

Low Voltage Lighting Control Device Schedule			
Mark	Manuf.	Model	Description
SW1	nLight	nPODM	SINGLE CHANNEL ON/OFF ONLY WALL SWITCH. VERIFY FINISH WITH ARCHITECT.
SW2	nLight	nPODM DX	SINGLE CHANNEL ON/OFF + DIMMING WALL SWITCH. VERIFY FINISH WITH ARCHITECT.
SW3	nLight	nWSXLV DX	PIR OCCUPANCY SENSOR SWITCH WITH DIMMING. SET FOR MANUAL ON/AUTO-OFF OPERATION. VERIFY FINISH WITH ARCHITECT.
SW4	nLight	nWSXLV	PIR OCCUPANCY SENSOR SWITCH. SET FOR MANUAL ON/AUTO-OFF OPERATION. VERIFY FINISH WITH ARCHITECT.
SW5	nLight	nPODM 2P DX	TWO CHANNEL ON/OFF + DIMMING WALL SWITCH. VERIFY FINISH WITH ARCHITECT.
SW6	nLight	nPODM 2P	TWO CHANNEL ON/OFF ONLY WALL SWITCH. VERIFY FINISH WITH ARCHITECT.
SW7	nLight	nWSXLV	OCCUPANCY WALL SWITCH WITH FAN CONTROL. VERIFY FINISH WITH ARCHITECT.
OC1	Sensor Sw	Select Model	#N/A

PROVIDE ALL LOW VOLTAGE WIRING, ACCESSORIES, AND HARDWARE FOR A COMPLETE AND OPERABLE SYSTEM. BASIC DESIGN LIGHT CONTROLS ACCEPTABLE EQUAL: SENSOR SWITCH, WATTSTOPPER, HUBBLE, EATON

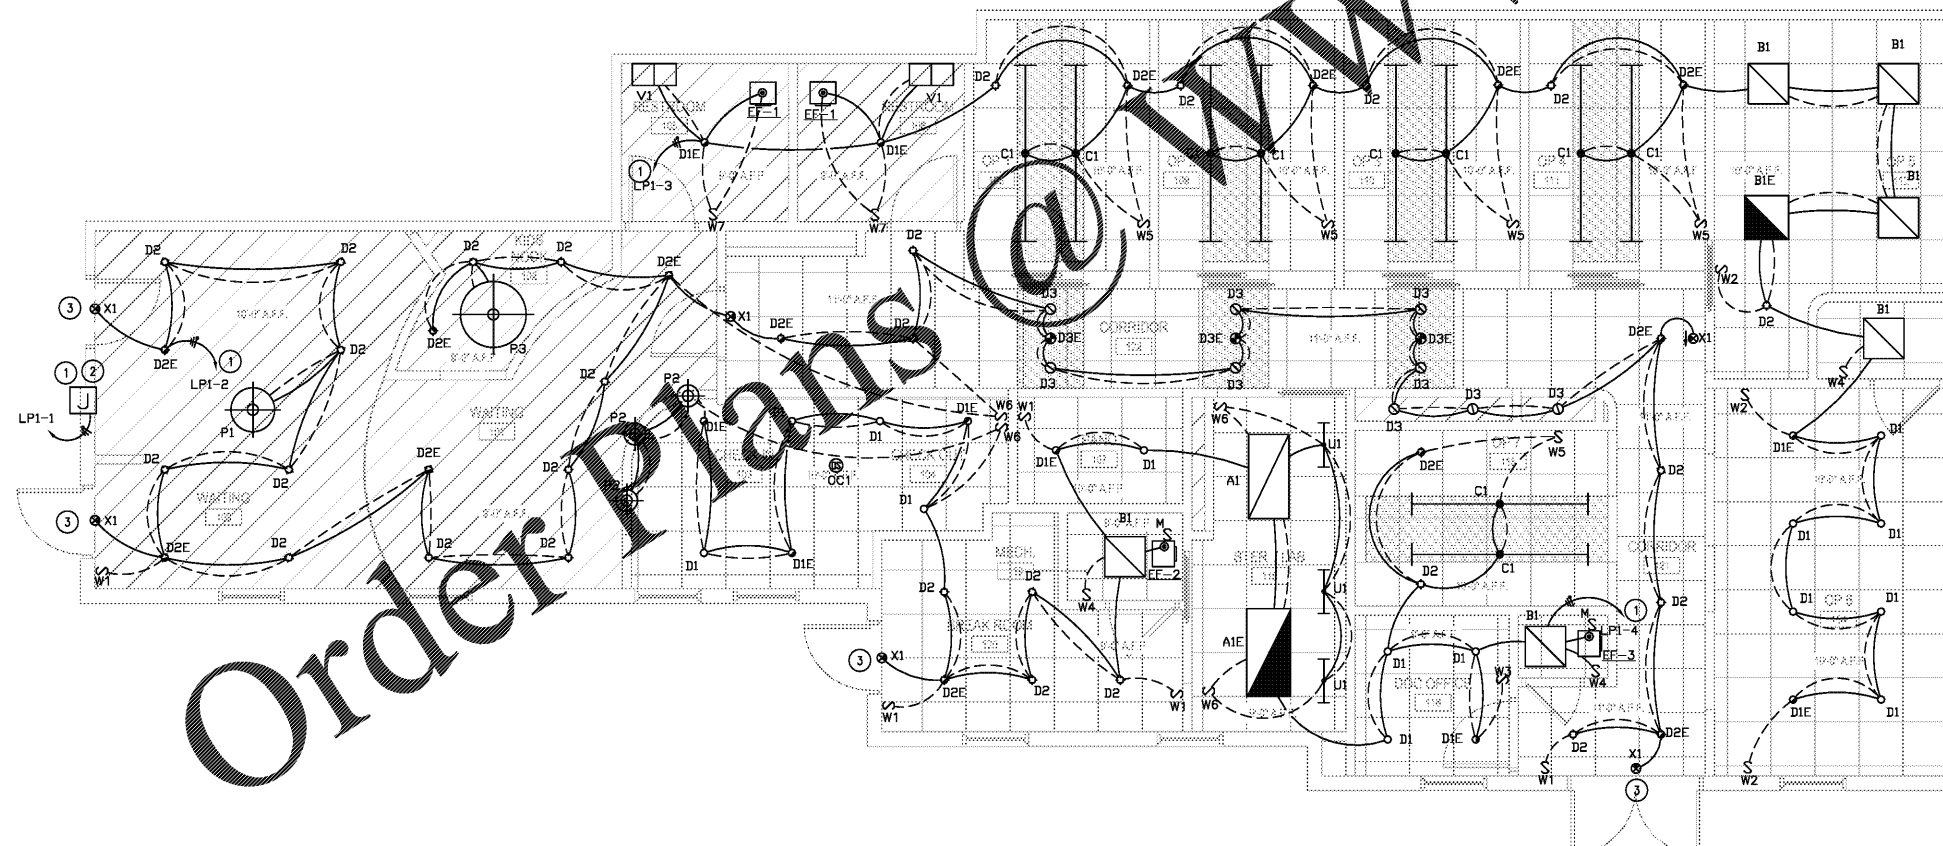


- Ⓢ ELECTRICAL KEYED NOTES:**
- ROUTE CIRCUIT THROUGH LIGHTING CONTROL PANEL.
 - PROVIDE JUNCTION BOX FOR TENANT SIGN. COORDINATE EXACT MOUNTING LOCATION WITH OWNER PRIOR TO ROUGH-IN.
 - ALL EMERGENCY EGRESS LIGHTING EXISTING TO REMAIN.

Order Plans

1 LIGHTING PLAN
1/4" = 1'-0"




8000 IH-10, FRONTAGE RD., STE 300
SAN ANTONIO, TX 78230
210-899-4500

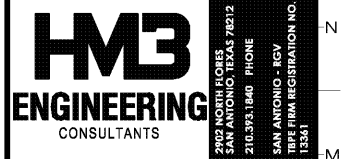

2102 NORTH FLORES
SAN ANTONIO, TEXAS 78212
210-393-1840 PHONE
SAN ANTONIO - IGW
TX REGISTRATION NO.
15341

**DENTAL OFFICES OF
DR. FREITAS & DR. SOUZA**

17901 PINES BLVD. SUITE 202, PEMBROKE PINES, FL 33029

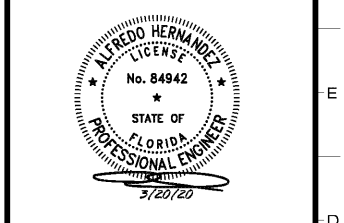

ISSUE		
NO.	DATE	DESCRIPTION
1	03-20-2020	PERMIT DOCUMENTS

Project No. HM3 PROJ #20055 Date: 03/20/20
Sheet Title: **ELECTRICAL PLAN**
Page No. **E100**