


SCOPE DOCUMENTS

The Construction Documents have not been completed therefore this drawing may be incomplete or not coordinated. The documents issued indicate the general scope of the Project. The Contractor is responsible for complete and coordinated pricing and Work, and shall include all items necessary for the proper execution and completion of the Project, whether indicated or not. All components of the Project shall comply with any and all requirements of national, state, and local codes. The Contractor shall inform the Owner and Architect of any omissions, inaccuracies or errors in the information provided. If no notice is given and any omissions, inaccuracies or errors are discovered, the Architect's decision on items of Work included in the scope shall be binding on the Contractor, when consistent with the general scope and quality of the Project.

ISSUANCES

No.	Drawing Issue Description	Date

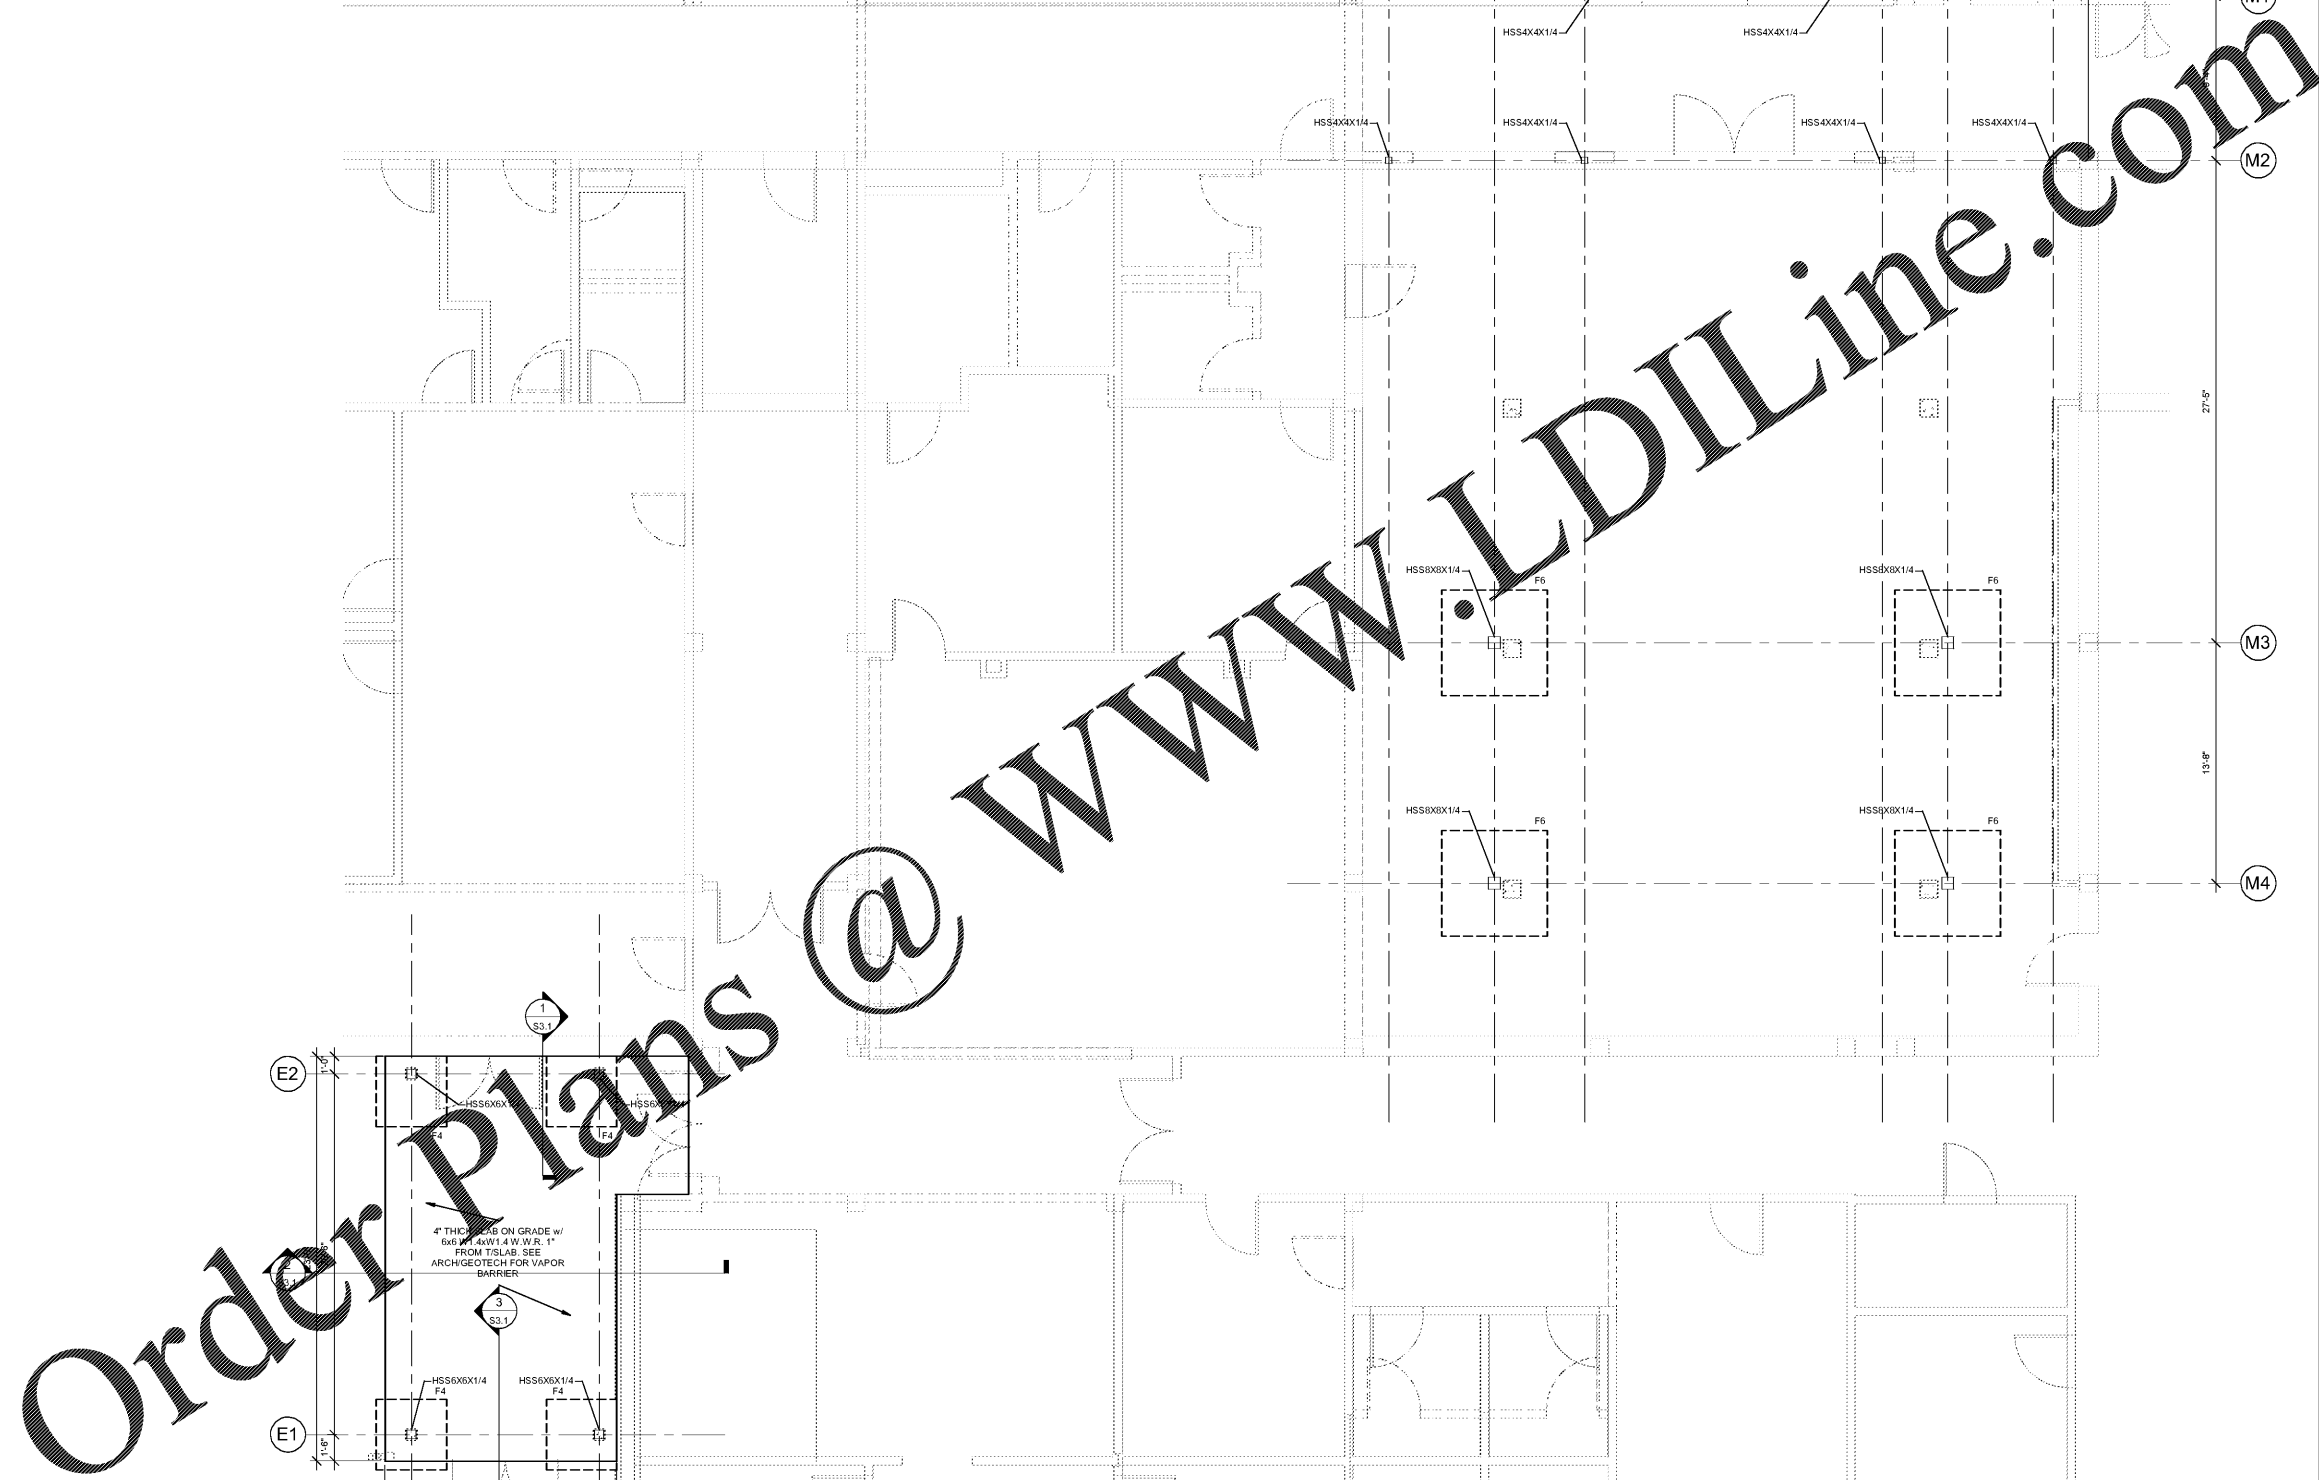

- FOUNDATION PLAN NOTES:**
1. TOP OF INTERIOR FOOTINGS SHALL BE (0'-0") BELOW F.F.E. UNO.
 2. TOP OF EXTERIOR FOOTINGS SHALL BE (1'-4") BELOW F.F.E. UNO.
 3. CONTRACTOR SHALL COORDINATE FOOTING ELEVATIONS w/ MECHANICAL/PLUMBING DRAWINGS TO AVOID INTERFERENCE WITH UNDERGROUND PIPING. SEE FOOTINGS AS REQUIRED PER TYPICAL DETAILS.
 4. SEE CIVIL/ARCHITECTURAL FOR EXTERIOR SLAB-ON-GRADE.
 5. † INDICATES STEP IN FOOTING.

FOUNDATION SCHEDULE

MARK	LENGTH	WIDTH	THICKNESS	REINFORCEMENT
F4	4'-0"	4'-0"	1'-4"	(5) #5 E.W.
F4.5	4'-6"	4'-6"	1'-4"	(6) #5 E.W.
F5	5'-0"	5'-0"	1'-4"	(6) #5 E.W.
F6	6'-0"	6'-0"	1'-4"	(7) #5 E.W.
F6.5	6'-6"	6'-6"	1'-4"	(8) #5 E.W.

1 FOUNDATION PLAN - Media Center
 S1.1 SCALE: 1/4" = 1'-0"

PROJECT NUMBER: 1202 PROJECT NAME: TEMPLATE TESTING
 SHEET NUMBER: S1.1 MEDIA CENTER FOUNDATION
 C:\Users\cbryant\Documents\BAMO - Struct - 2019_cbyant\WKR62.rvt
 3/19/2020 7:02:46 PM

Order Plans @ www.LDILine.com

BARACK & MICHELLE OBAMA
 ACADEMY

970 Martin St SE, Atlanta, GA 30315
 ATLANTA PUBLIC SCHOOLS

MEDIA CENTER FOUNDATION

Designer: 12719
 Principal/Checker: 03/16/20
 Approver: Date
 Checker: Date
 Project Engineer: Date
 Author: Date
 Staff Engineer: Date

S1.1