



COOPER CARRY
THE CENTER FOR CONNECTIVE ARCHITECTURE

191 Peachtree Street NE
Suite 2400
Atlanta, GA 30303-1770
(404) 237-2000
coopercarry.com

 
00119 COOPER CARRY

SCOPE DOCUMENTS

The Contract Documents Issued for (Conceptual Design, Schematic Design, Design Development, Partial Construction Documents or Other Issuance up to Issued for Construction) are intended to be at that level of development and as such, may be neither complete nor coordinated. The (Construction Manager, Contractor, Design/Builder) is responsible for complete and coordinated pricing (and execution) of the Work, and shall include items necessary for the proper execution and completion of the Work, as shown, specified, reasonably inferred or required for a complete Project. For Work of obligated design, systems, assemblies, components and materials shall comply with national, state and local code requirements. The (Construction Manager, Contractor, Design/Builder) shall inform the Owner and Architect, in timely fashion, of any discovered omissions, inconsistencies or errors in the Contract Documents.

ISSUANCES		
No.	Drawing Issue Description	Date
1	DESIGN DEVELOPMENT	3/18/20

GADOE CODE: 5066
FTE - 450
EXISTING IU - 38
PROPOSED IU - 33



BARACK & MICHELLE OBAMA ACADEMY




970 Martin St SE, Atlanta, GA 30315
ATLANTA PUBLIC SCHOOLS

1ST FLOOR DEMOLITION REFLECTED CEILING PLAN - AREA B

ROBERT A. JUST Principal/Designer	20190109
S. TARGHAN Project Manager	03/18/20
B. FERREN Project Architect	
G. HAHN / V. MOGWANJA Staff Architect	
B. FERREN / G. HAHN Interior Design	

A1.59

NOT ISSUED FOR CONSTRUCTION

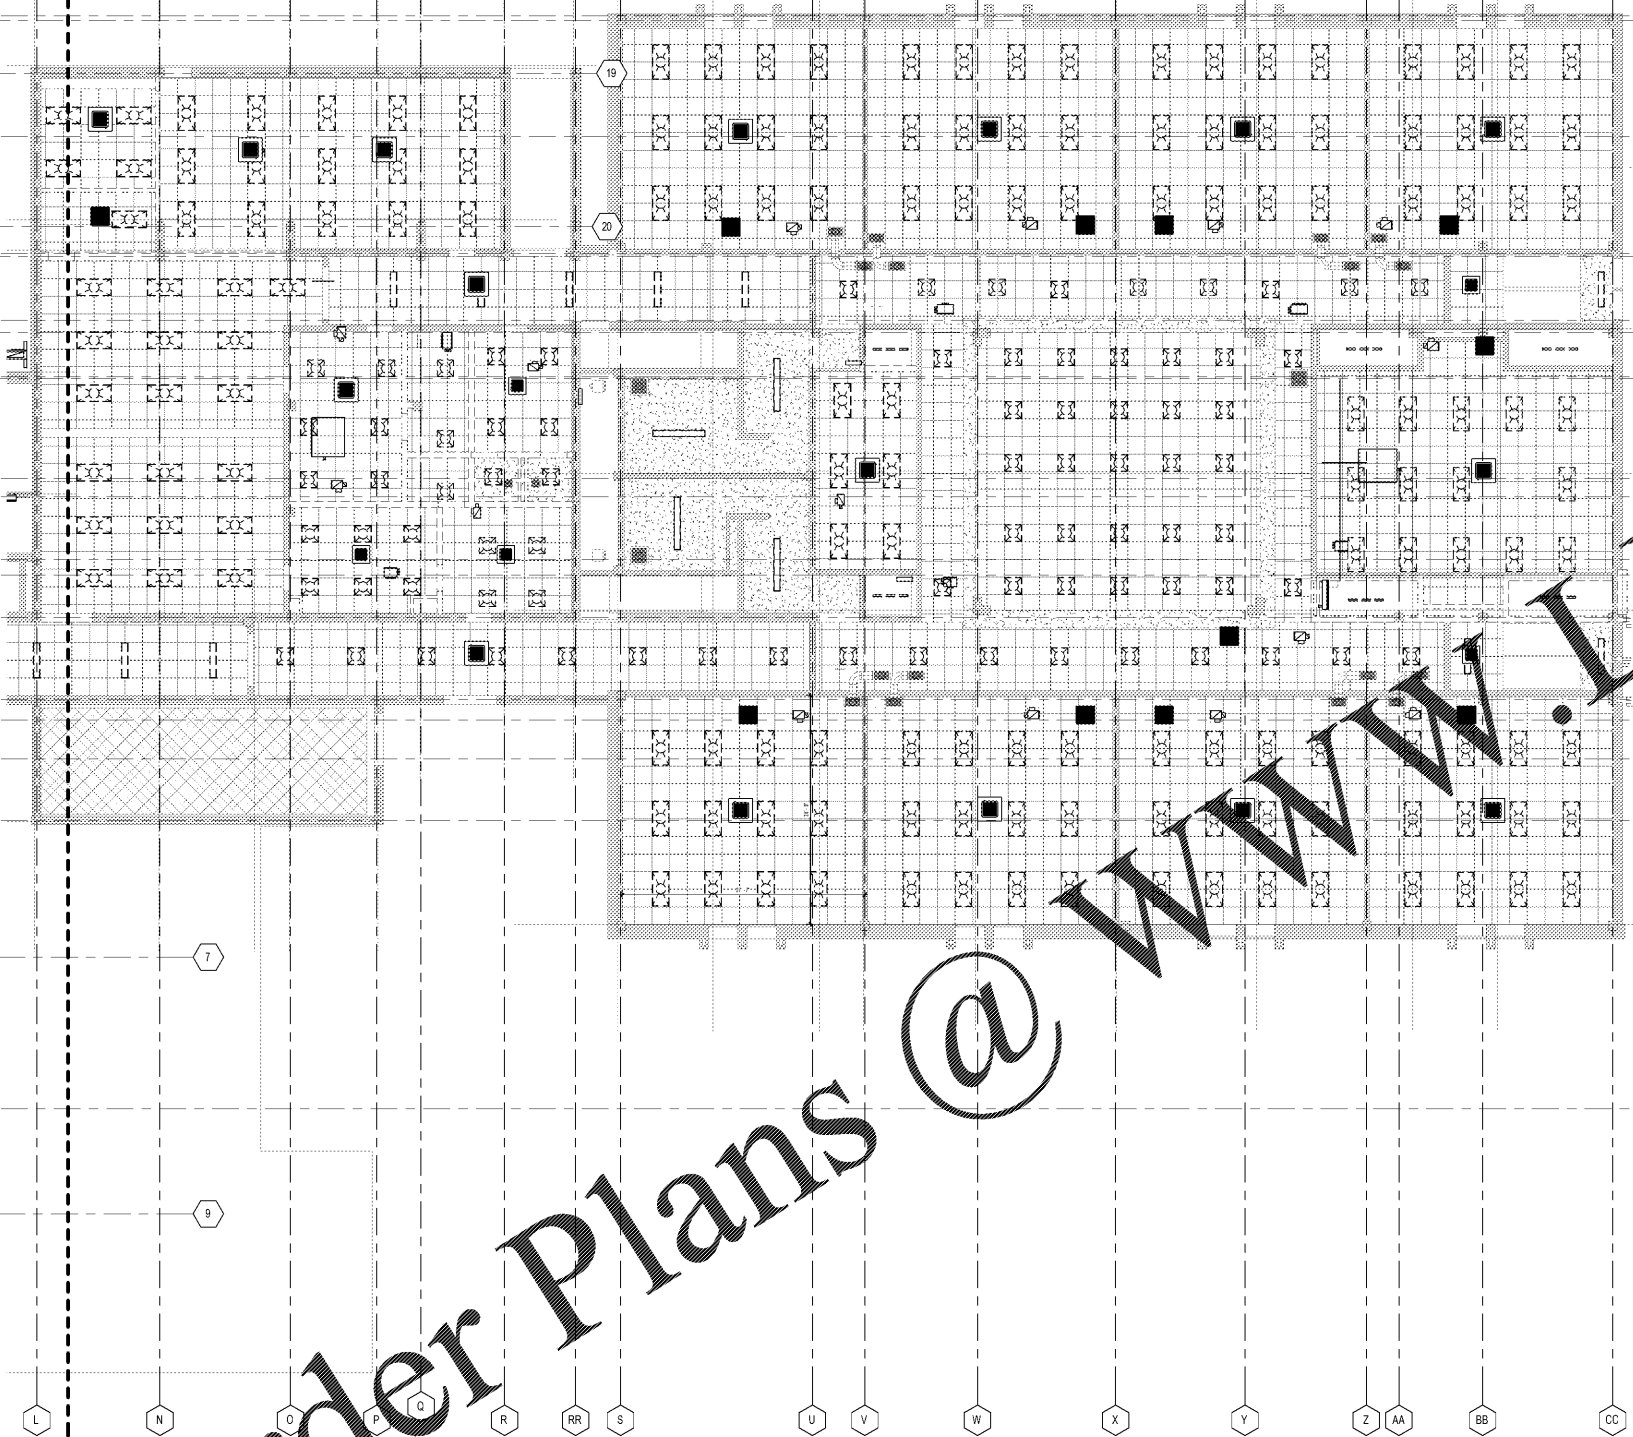

1 1ST FLOOR DEMOLISHED REFLECTED CEILING PLAN - AREA B
SCALE: 1/8" = 1'-0"

RCP LEGEND			
LIGHT FIXTURES			
	SURFACE MOUNTED FIXTURE		STRIP FLUORESCENT FIXTURE
	EXIT SIGN WALL MOUNTED		TRACK LIGHTING
	2x4 EMERGENCY FIXTURE, PARABOLIC LENS		WALL MOUNTED FIXTURE, SCOSNCE
	2x2 EMERGENCY FIXTURE, PARABOLIC LENS		WALL MOUNTED FIXTURE, LINEAR
	2x4 LAY-IN FIXTURE, PARABOLIC LENS		POLE MOUNTED LIGHT FIXTURE
	2x2 LAY-IN FIXTURE, PARABOLIC LENS		2x4 EMERGENCY FIXTURE, ACRYLIC LENS
	2x4 LAY-IN FIXTURE, ACRYLIC LENS		POLE MOUNTED LIGHT FIXTURE
	2x2 LAY-IN FIXTURE, ACRYLIC LENS		EXIT SIGN CEILING MOUNTED
			RECESSED DOWN LIGHT - DIRECTIONAL
		MECHANICAL FIXTURES	
			PENDANT MOUNTED FIXTURE
			CEILING FAN
			2x2 EMERGENCY FIXTURE, ACRYLIC LENS
			RECESSED DOWN LIGHT - ROUND
			ACCESS PANEL
			RETURN AIR DIFFUSER
			SUPPLY AIR DIFFUSER
			LINEAR SLOT DIFFUSER

PROJECT NUMBER: 20190109 PROJECT NAME: BARACK & MICHELLE OBAMA ACADEMY
DATE: 03/18/2020 02:13:57 vvt
3/17/2020 6:44:16 PM

Order Plans @ WWW.LDILine.com