

 


**SCOPE DOCUMENTS**

The Contract Documents Issued for [Conceptual Design, Schematic Design, Design Development, Partial Construction Documents or Other Issuance up to Issued for Construction] are intended to be at that level of development and as such, may be neither complete nor coordinated. The [Construction Manager, Contractor, Design/Builder] is responsible for complete and coordinated pricing [and execution] of the Work, and shall include items necessary for the proper execution and completion of the Work, as shown, specified, reasonably inferred or required for a complete Project. For Work of obligated design, systems, assemblies, components and materials shall comply with national, state and local code requirements. The [Construction Manager, Contractor, Design/Builder] shall inform the Owner and Architect, in timely fashion, of any discovered omissions, inconsistencies or errors in the Contract Documents.

ISSUANCES		
No.	Drawing Issue Description	Date
1	DESIGN DEVELOPMENT	3/18/20

GADOE CODE: 5066  
FTE - 450  
EXISTING IU - 38  
PROPOSED IU - 33



**BARACK & MICHELLE OBAMA ACADEMY**





970 Martin St SE, Atlanta, GA 30315  
ATLANTA PUBLIC SCHOOLS

**2ND FLOOR DEMOLITION  
REFLECTED CEILING PLAN -  
AREA A**


Principal Architect	ROBERT A. JUST	20190109
Project Manager	S. TARRIHAN	03/18/20
Project Manager	B. FERREN	DATE
Project Architect	G. HAHN / V. MOGWANJA	
Staff Architect	B. FERREN / G. HAHN	
Interior Design		

**A1.61**

RCP LEGEND			
<b>LIGHT FIXTURES</b>			
	SURFACE MOUNTED FIXTURE		STRIP FLUORESCENT FIXTURE
	EXIT SIGN WALL MOUNTED		TRACK LIGHTING
	24 EMERGENCY FIXTURE, PARABOLIC LENS		WALL MOUNTED FIXTURE, SCONCE
	22 EMERGENCY FIXTURE, PARABOLIC LENS		WALL MOUNTED FIXTURE, LINEAR
	24 LAY-IN FIXTURE, PARABOLIC LENS		POLE MOUNTED LIGHT FIXTURE
	22 LAY-IN FIXTURE, PARABOLIC LENS		24 EMERGENCY FIXTURE, ACRYLIC LENS
	24 LAY-IN FIXTURE, ACRYLIC LENS		POLE MOUNTED LIGHT FIXTURE
	22 LAY-IN FIXTURE, ACRYLIC LENS		EXIT SIGN CEILING MOUNTED
			RECESSED DOWNLIGHT - DIRECTIONAL
			<b>MECHANICAL FIXTURES</b>
			ACCESS PANEL
			RETURN AIR DIFFUSER
			SUPPLY AIR DIFFUSER
			LINEAR SLOT DIFFUSER

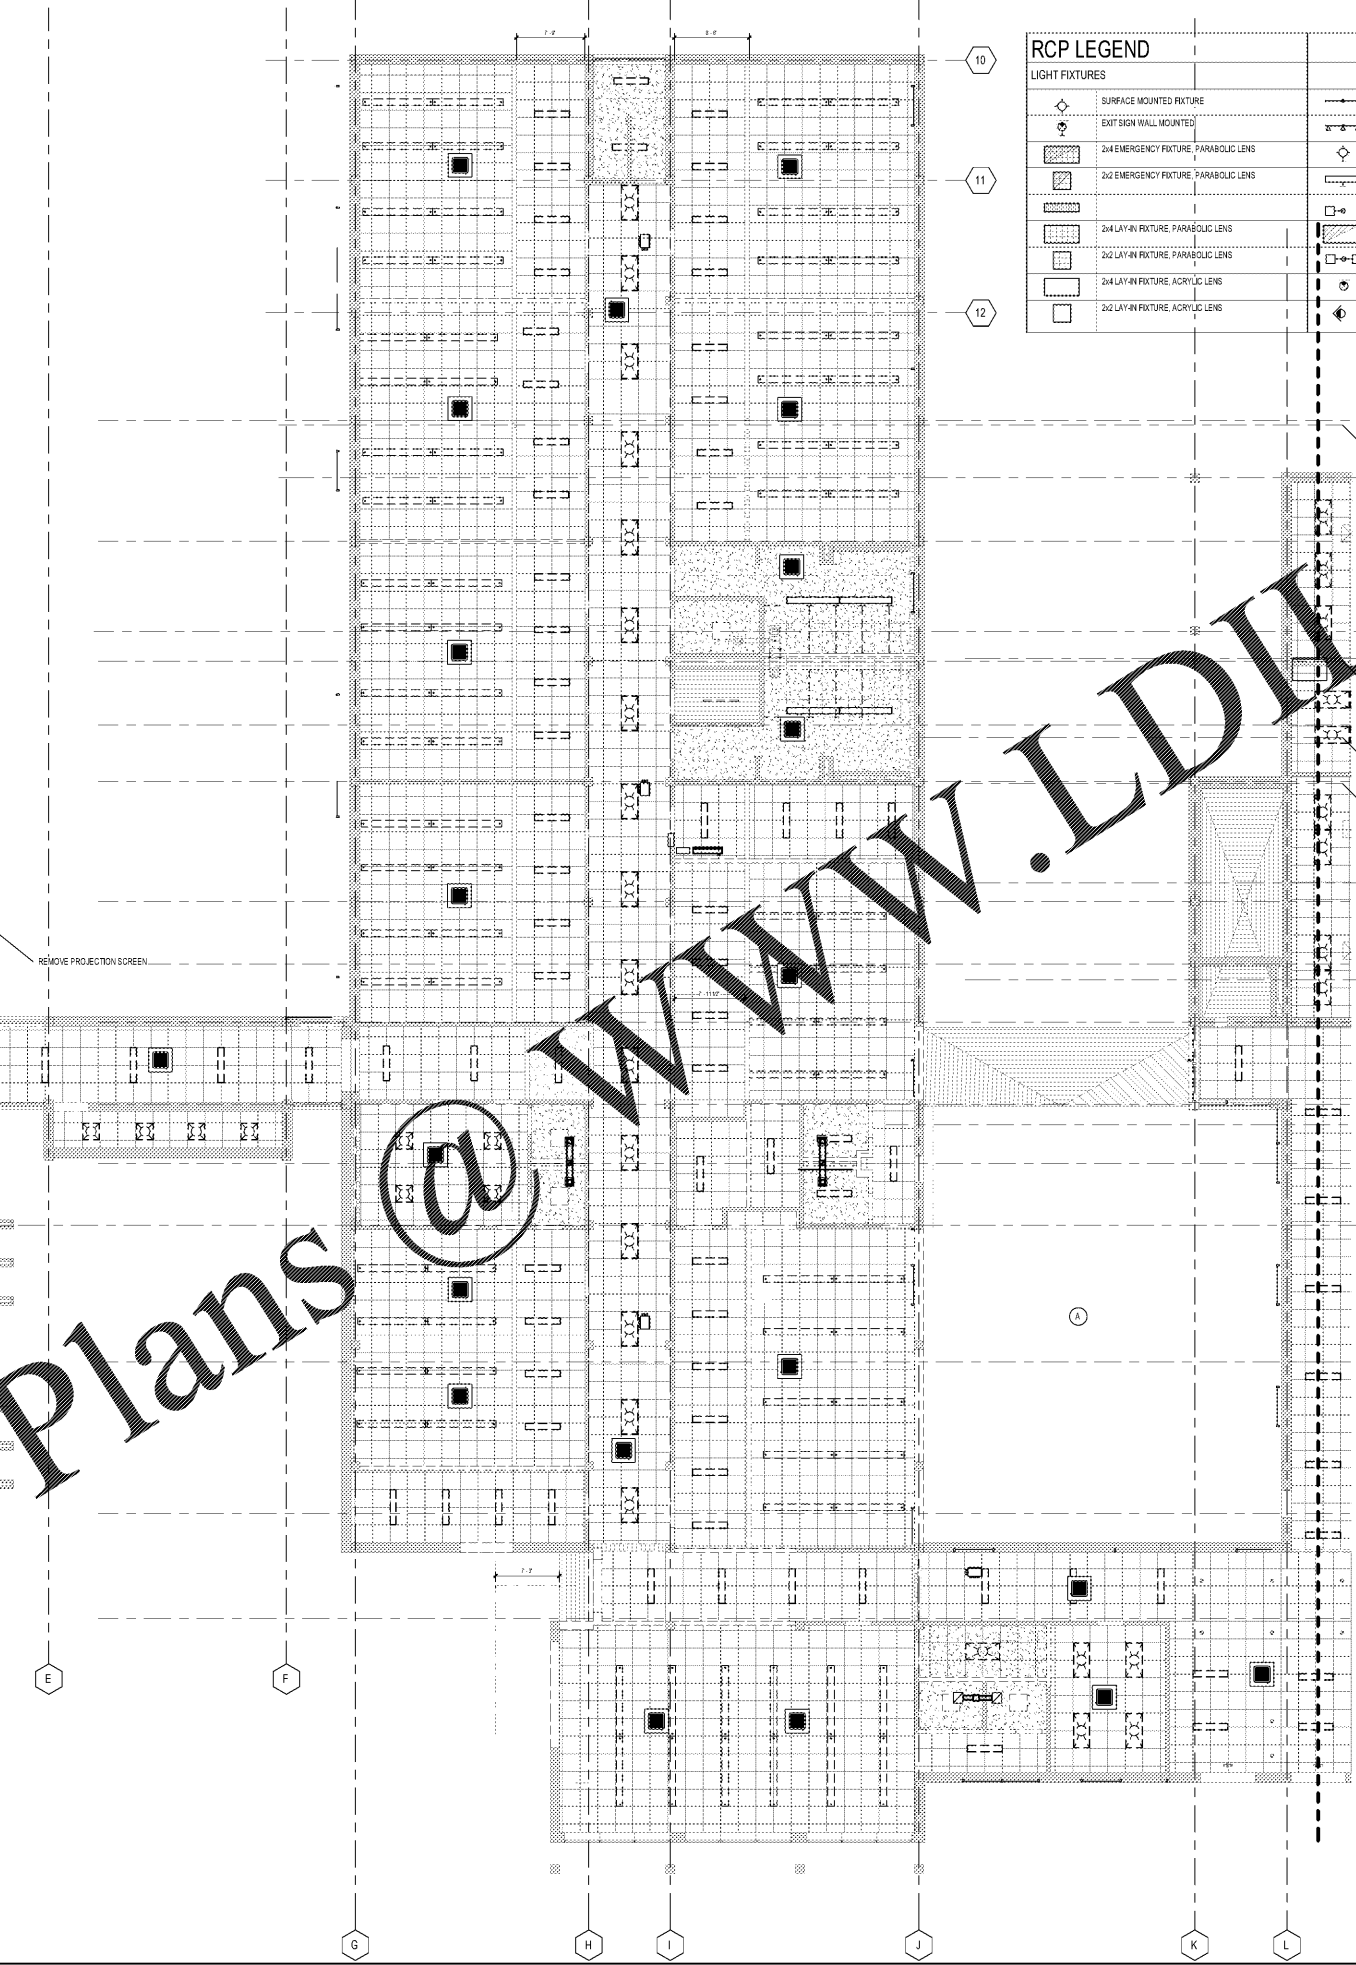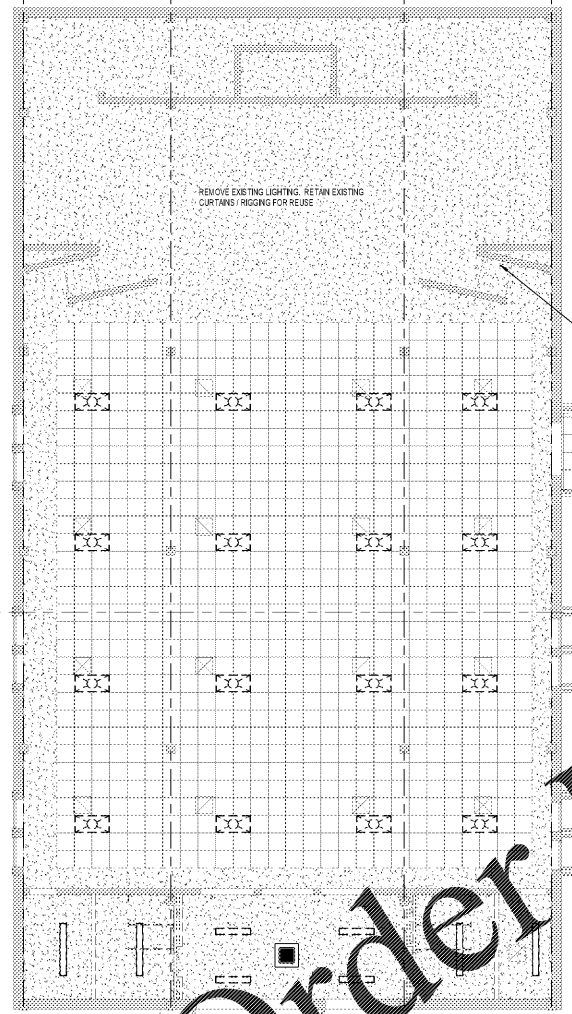

 **1** 2ND FLOOR DEMOLISHED REFLECTED CEILING PLAN - AREA A  
A1.61 SCALE: 1/8" = 1'-0"



PROJECT NUMBER: 20190109 PROJECT NAME: BARACK & MICHELLE OBAMA ACADEMY  
DATE: 02/13/2020 02:13:37 vvt  
3/17/2020 6:44:23 PM

Order Plans @ [WWW.LDLINE.COM](http://WWW.LDLINE.COM)