



00118 COOPER CARRY

SCOPE DOCUMENTS

The Contract Documents Issued for [Conceptual Design, Schematic Design, Design Development, Partial Construction Documents or Other Issuance up to Issued for Construction] are intended to be at that level of development and as such, may be neither complete nor coordinated. The [Construction Manager, Contractor, Design/Builder] is responsible for complete and coordinated pricing [and execution] of the Work, and shall include items necessary for the proper execution and completion of the Work, as shown, specified, reasonably inferred or required for a complete Project. For Work of designed design, systems, assemblies, components and materials shall comply with national, state and local code requirements. The [Construction Manager, Contractor, Design/Builder] shall inform the Owner and Architect, in timely fashion, of any discovered omissions, inconsistencies or errors in the Contract Documents.

ISSUANCES		
No.	Drawing Issue Description	Date
1	DESIGN DEVELOPMENT	3/18/20

GADOE CODE: 5066
FTE - 450
EXISTING IU - 38
PROPOSED IU - 33

BARACK & MICHELLE OBAMA ACADEMY




970 Martin St SE, Atlanta, GA 30315
ATLANTA PUBLIC SCHOOLS
VERTICAL CIRCULATION


ROBERT A. JUST	20190109
Principal/Designer	Project No.
S. TARGHAN	03/18/20
Project Manager	Date
B. FERREN	
Project Architect	
K. HARRIS	
Staff Architect	
B. FERREN / G. HAHN	
Interior Design	

A7.13


NOT ISSUED FOR CONSTRUCTION

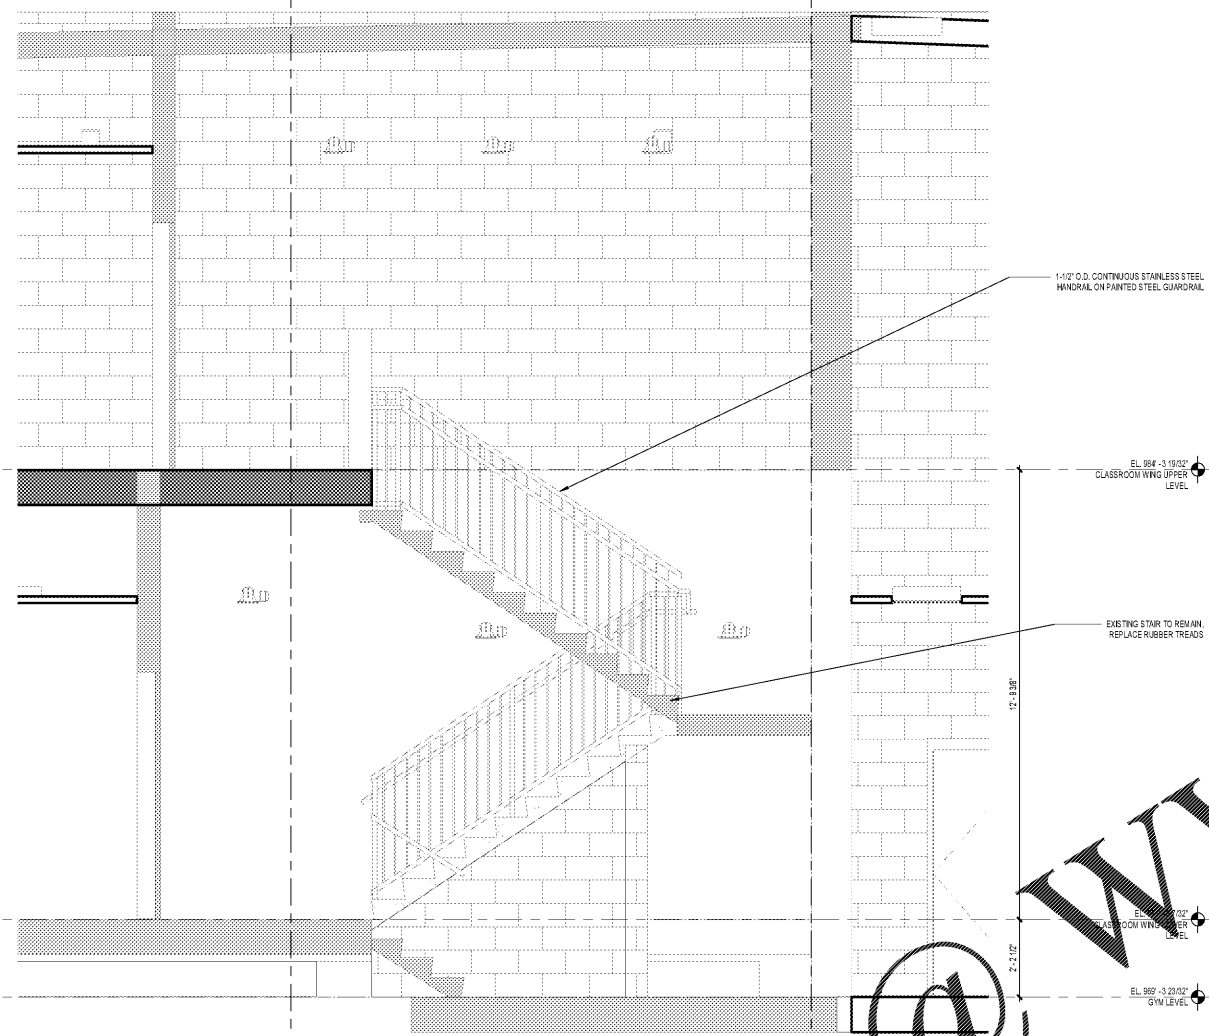


6 SECTION - STAIR 1121
A7.13 SCALE: 1/2" = 1'-0"

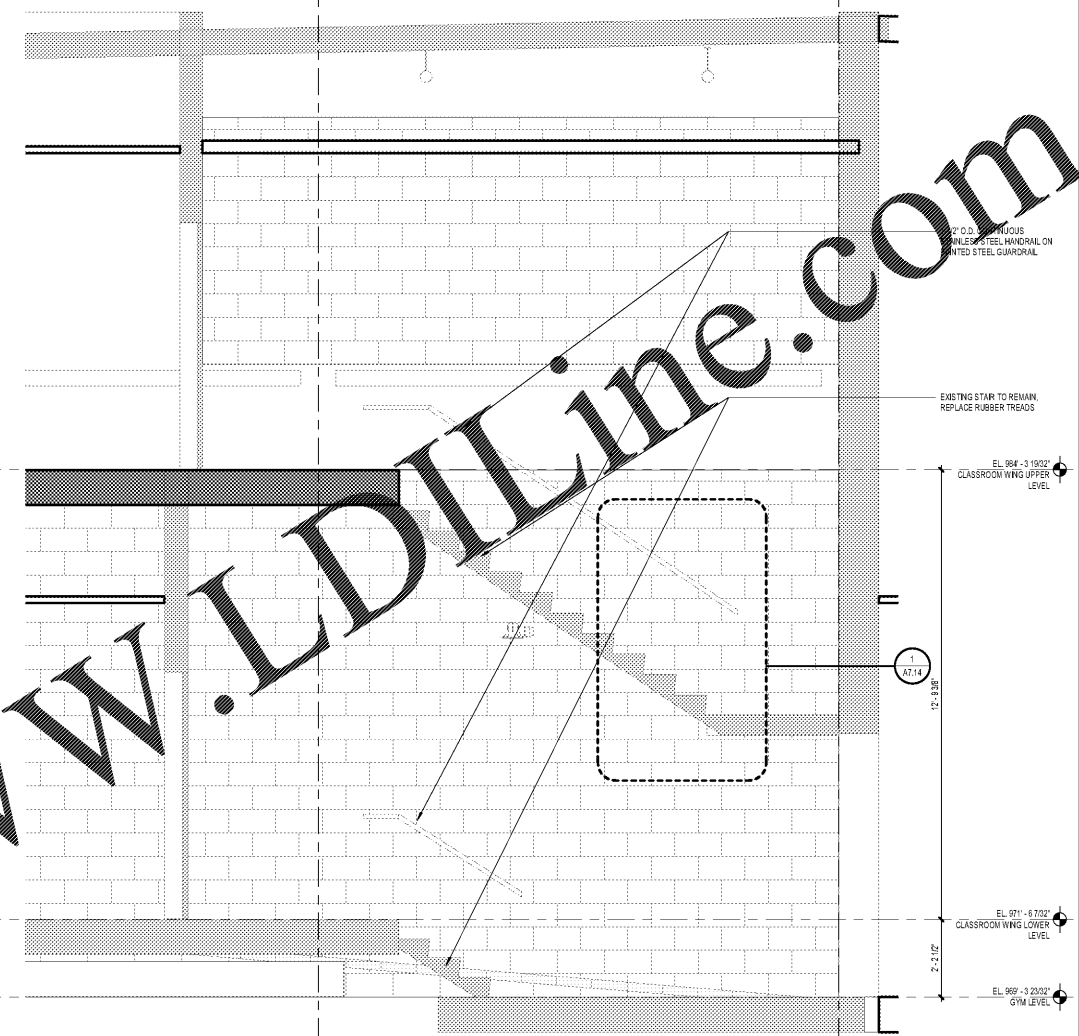

4 SECTION - STAIR 1122
A7.13 SCALE: 1/2" = 1'-0"

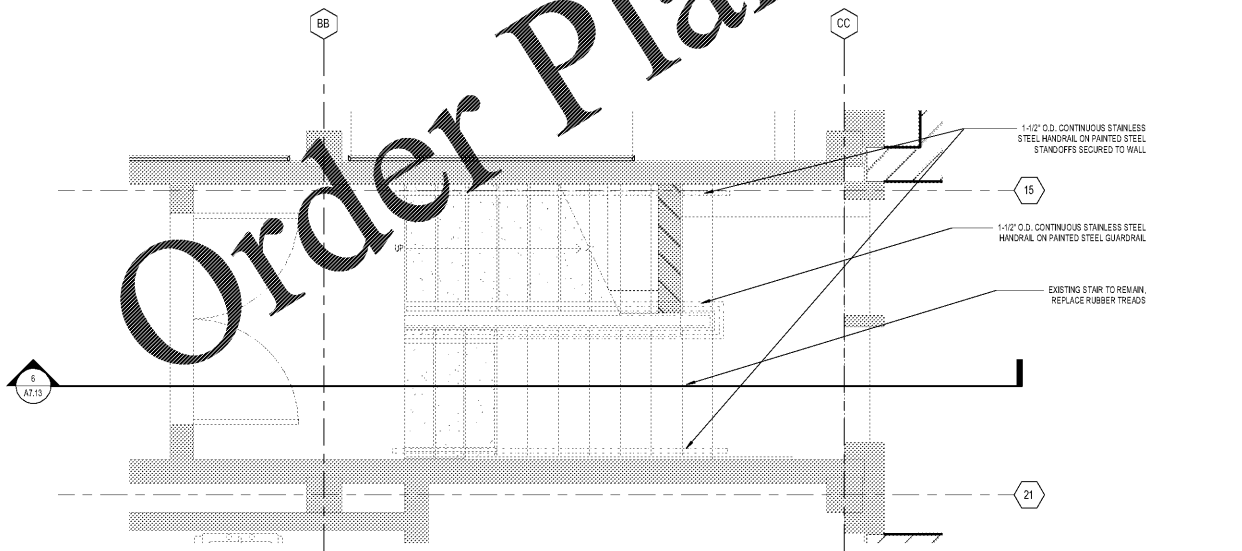

1 ENLARGED FLOOR PLAN - STAIR 1121
A7.13 SCALE: 1/2" = 1'-0"

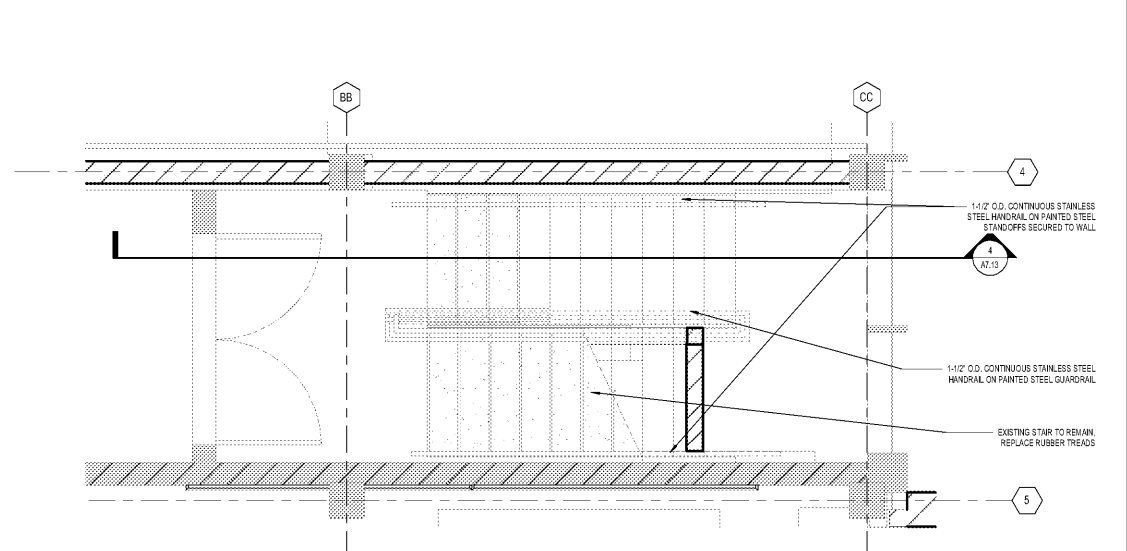

2 ENLARGED FLOOR PLAN - STAIR 1122
A7.13 SCALE: 1/2" = 1'-0"

Order Plans @

WWW.LDILine.com

PROJECT NUMBER: 20190109 PROJECT NAME: BARACK & MICHELLE OBAMA ACADEMY
DATE: 02/13/2020 DRAWING TITLE: VERTICAL CIRCULATION - STAIRS
3/17/2020 6:51:14 PM