



**SCOPE DOCUMENTS**

The Contract Documents issued for (Conceptual Design, Schematic Design, Design Development, Partial Construction Documents or Other Issuance up to Issued for Construction) are intended to be at that level of

(Construction Manager, Contractor, Design/Builder) is responsible for complete and coordinated pricing (and execution) of the Work, and shall include items necessary for the proper execution and completion of the Work, as shown, specified, reasonably inferred or required for a complete components and materials shall comply with national, state and local code shall inform the Owner and Architect, in timely fashion, of any discovered omissions, inconsistencies or errors in the Contract Documents.

ISSUANCES		
No.	Drawing Issue Description	Date
1	DDC SUBMISSION	11/14/19
2	DESIGN DEVELOPMENT	3/18/20

FTE - 450  
EXISTING IU - 38  
PROPOSED IU - 33

**BARACK & MICHELLE OBAMA  
ACADEMY**



970 Martin St SE, Atlanta, GA 30315

**ATLANTA PUBLIC SCHOOLS**  
**1ST FLOOR PLUMBING  
DEMOLITION PLAN - DRAIN - AREA A**


AG	20190109
Prepared By	THW
Project Manager	THW
Project Architect	B. FERREN / J. KLEIN
Scale	1" = 1'-0"
Date	03/18/20
Sheet	P1.12

**GENERAL NOTES**

1. SEE PD.01 FOR PLUMBING GENERAL NOTES.

**KEY NOTES**

- ① REMOVE EXISTING PLUMBING FIXTURE. EXISTING PLUMBING PIPING SHALL REMAIN AND BE REUSED BY NEW FIXTURE AT THE SAME LOCATION.
- ② REMOVE EXISTING PLUMBING FIXTURE. CAP ASSOCIATED PLUMBING PIPING IN CONCEALED LOCATION.
- ③ EXISTING PLUMBING FIXTURE SHALL REMAIN.
- ④ REMOVE EXISTING FLOOR DRAIN. ASSOCIATED PIPING SHALL REMAIN AND BE REUSED BY NEW FLOOR DRAIN AT THE SAME LOCATION.

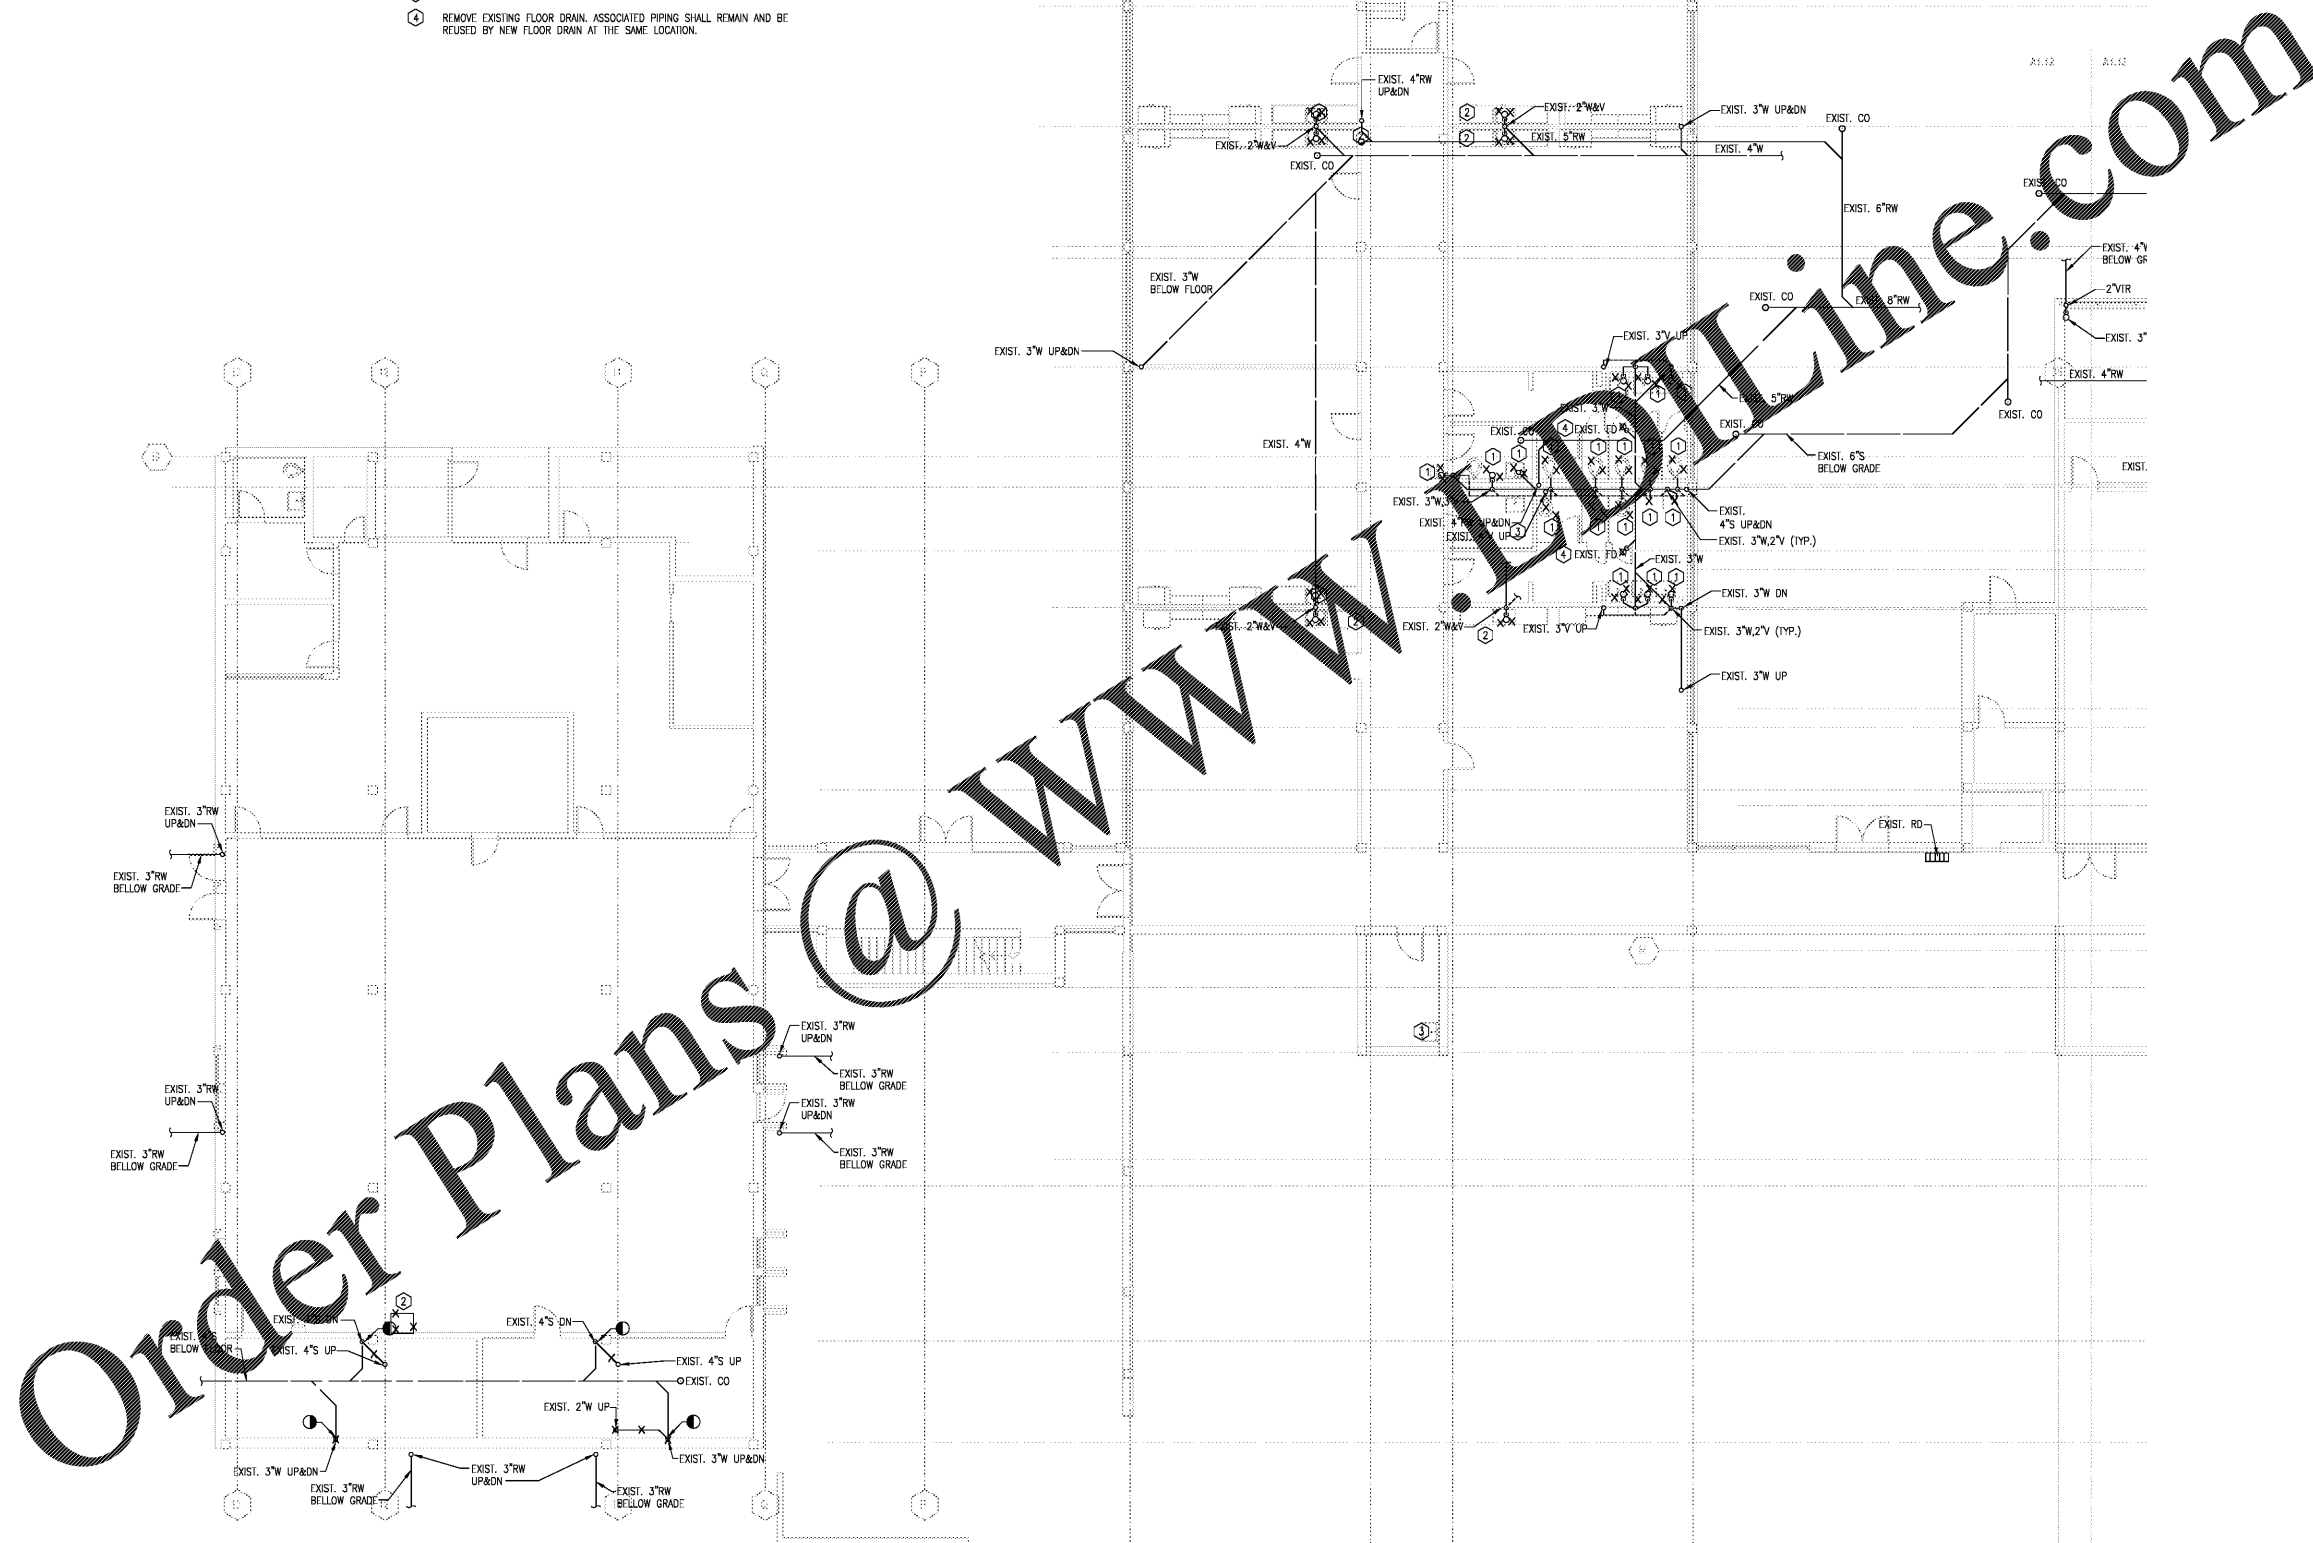

**1ST FLOOR PLUMBING DEMOLITION PLAN - DRAIN - AREA A**  
SCALE: 1/8" = 1'-0"



**Johnson, Spellman  
& Associates, Inc.**  
2050 Peachtree Dunwoody, Suite 1501  
Peachtree Corners, GA 30092  
770-447-0950 www.jsa-inc.com

Order Plans @ [www.dolline.com](http://www.dolline.com)

www.dolline.com