

GENERAL NOTES
1. SEE P.0.01 FOR PLUMBING GENERAL NOTES.

©2018 COOPER CARRY

SCOPE DOCUMENTS

The Contract Documents Issued for (Conceptual Design, Schematic Design, Design Development, Permit Construction Documents or Final Construction Documents) are intended to be at that level of (Construction Manager, Contractor, Design/Builder) is responsible for complete and coordinated pricing (and execution) of the Work, and shall include items necessary for the proper execution and completion of the Work, as shown, specified, reasonably inferred or required for a complete components and materials shall comply with national, state and local code shall inform the Owner and Architect, in timely fashion, of any discovered omissions, inconsistencies or errors in the Contract Documents.

ISSUANCES		
No.	Drawing Issue Description	Date
1	DDC SUBMISSION	11/14/19
2	DESIGN DEVELOPMENT	3/18/20

FTE - 450
EXISTING IU - 38
PROPOSED IU - 33

BARACK & MICHELLE OBAMA ACADEMY




970 Martin St SE, Atlanta, GA 30315

ATLANTA PUBLIC SCHOOLS

**2ND FLOOR PLUMBING
NEW WORK PLAN - SUPPLY
AREA A**

AG	20190109
THW	03/18/20
THW	
THW	
THW	
THW	
THW	
THW	

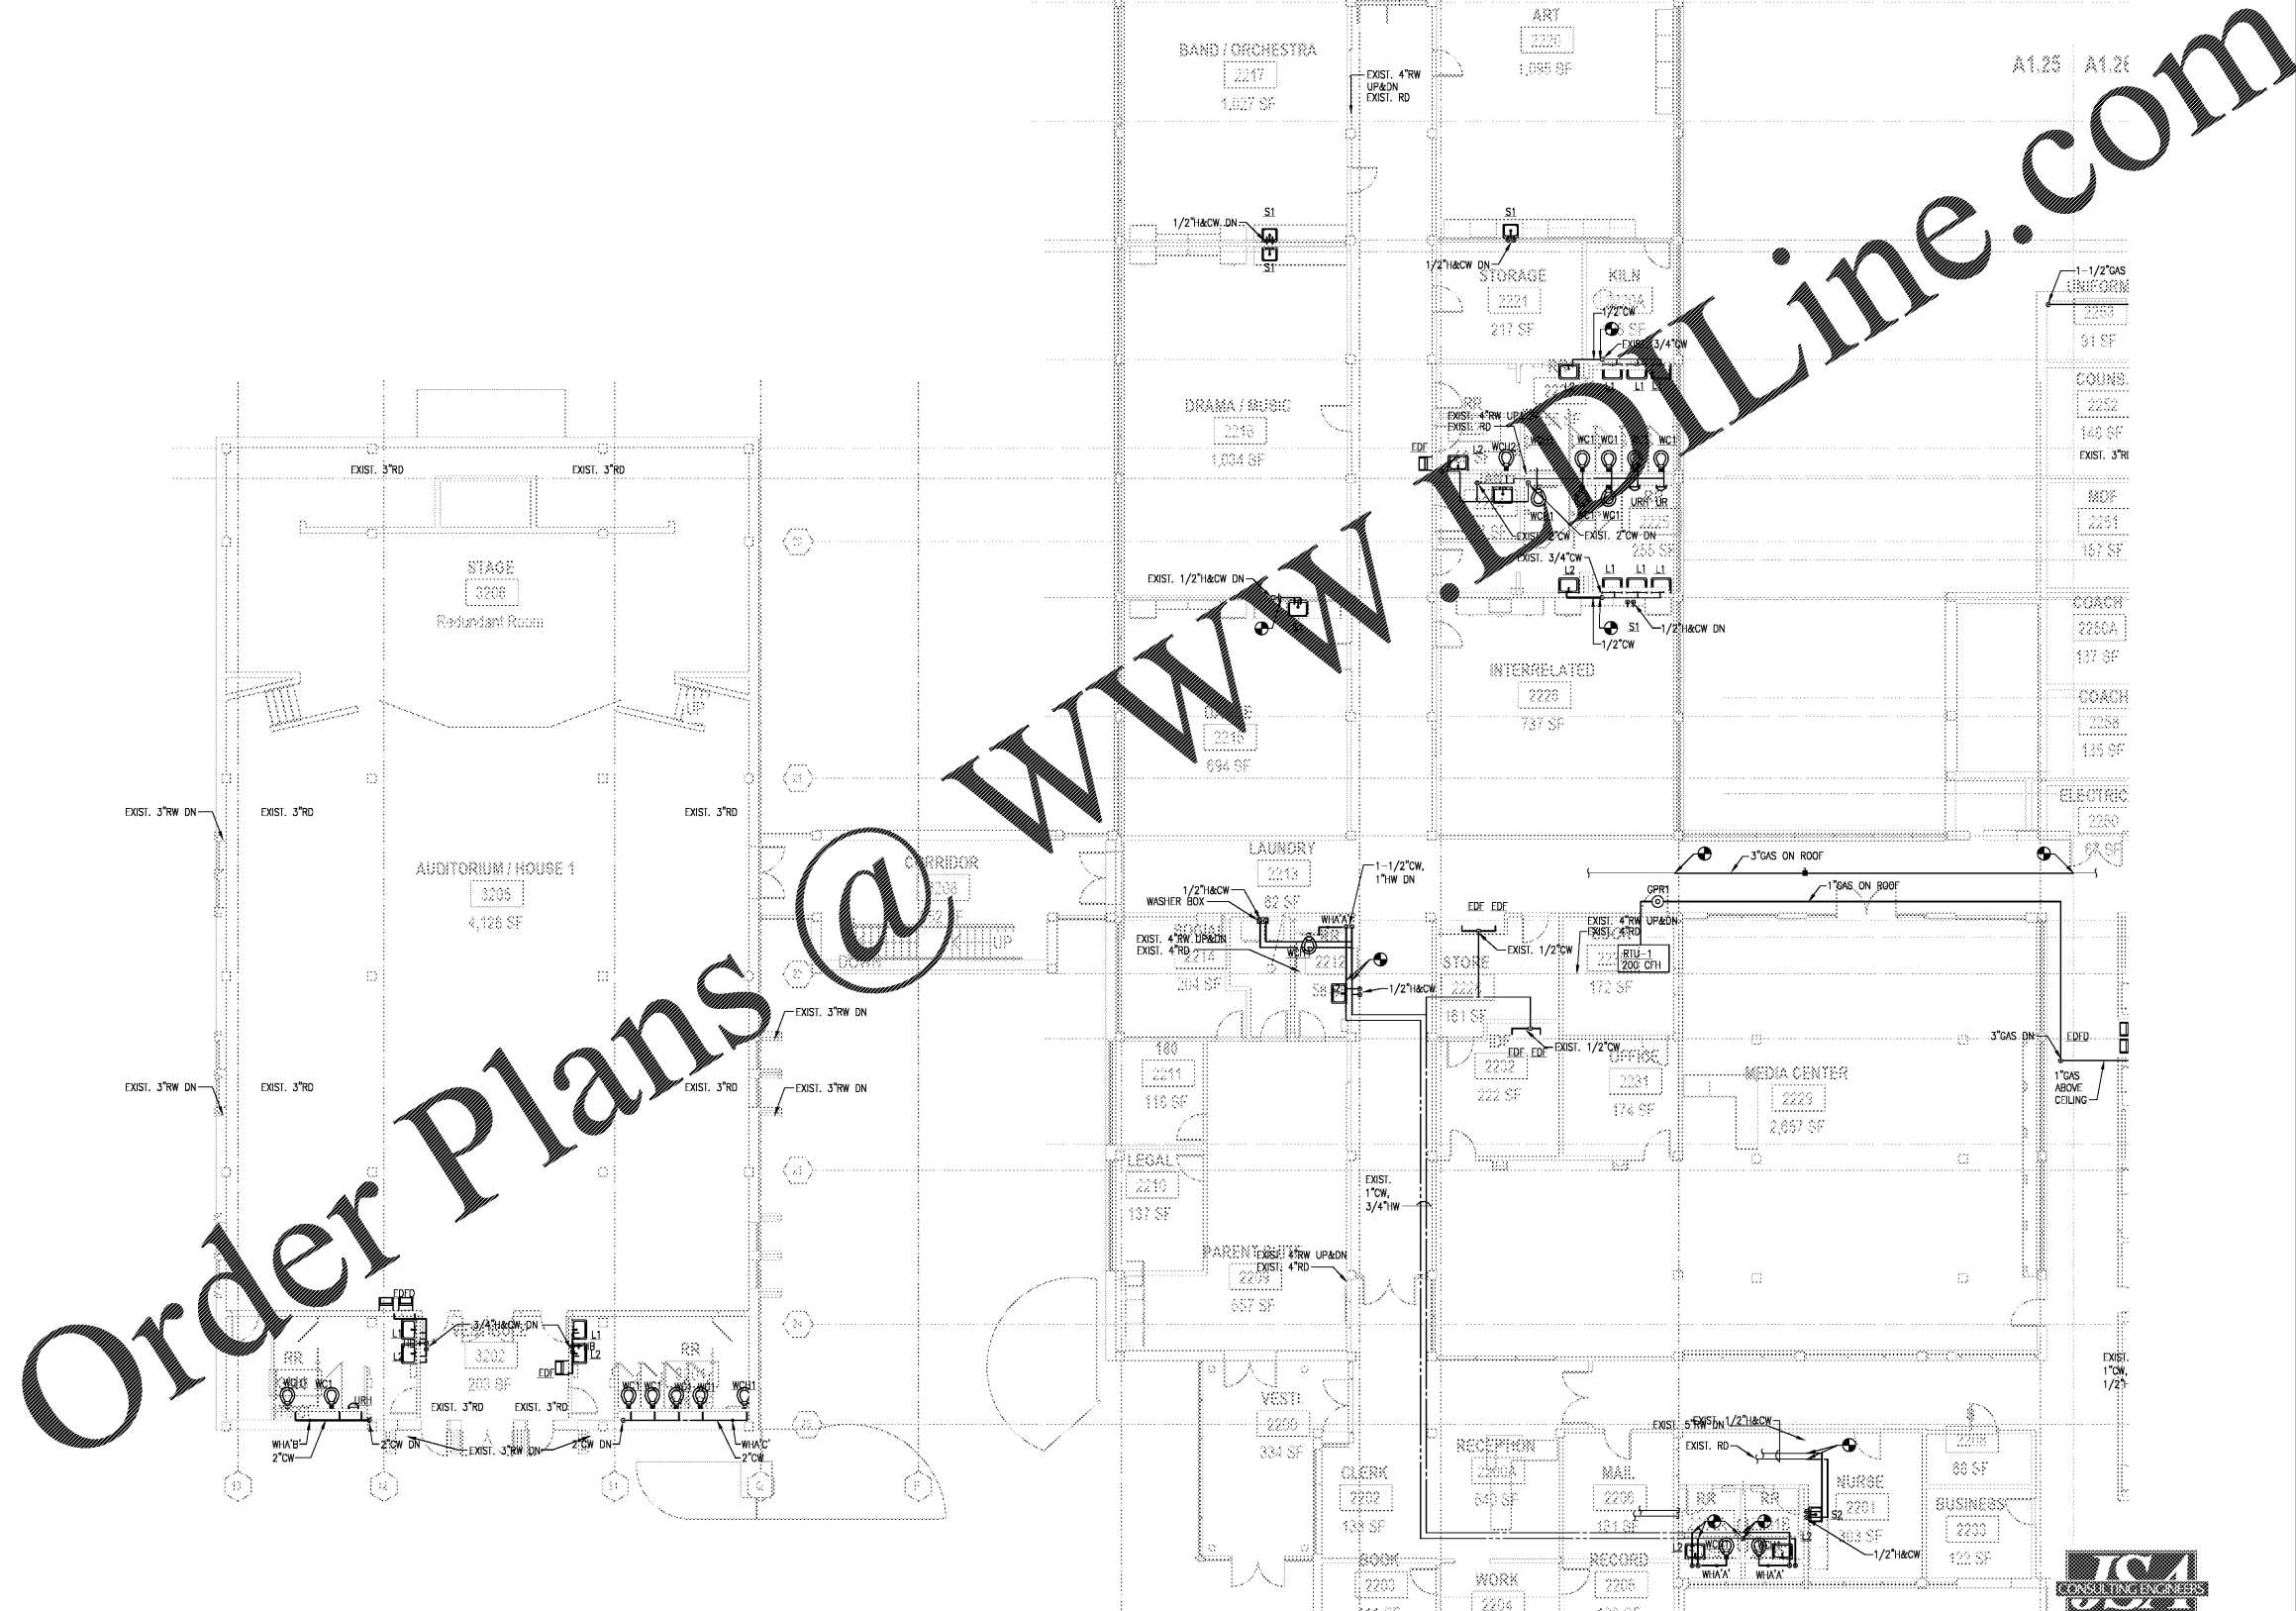

Order Plans @ www.IDLine.com

2ND FLOOR PLUMBING NEW WORK PLAN - SUPPLY - AREA A
SCALE: 1/8" = 1'-0"

