



COOPER CARRY
THE CENTER FOR CONNECTIVE ARCHITECTURE

191 Peachtree Street NE
Suite 2400
Atlanta, GA 30303-1770
(404) 237-2000
coopercarry.com

GENERAL NOTES

1. SEE SHEET M1-00 FOR HVAC GENERAL NOTES

KEY NOTES


○

©2018 COOPER CARRY

SCOPE DOCUMENTS
The Contract Documents Issued for [Conceptual Design, Schematic Design, Design Development, Partial Construction Documents or Other Issuance up to Issued for Construction] are intended to be at that level of development and as such, may be neither complete nor coordinated. The [Construction Manager, Contractor, Design/Builder] is responsible for complete and coordinated pricing [and execution] of the Work, and shall include items necessary for the proper execution and completion of the Work, as shown, specified, reasonably inferred or required for a complete Project. For Work of designated design, systems, assemblies, components and materials shall comply with national, state and local code requirements. The [Construction Manager, Contractor, Design/Builder] shall inform the Owner and Architect, in timely fashion, of any discovered omissions, inaccuracies or errors in the Contract Documents.

ISSUANCES

No.	Drawing Issue Description	Date

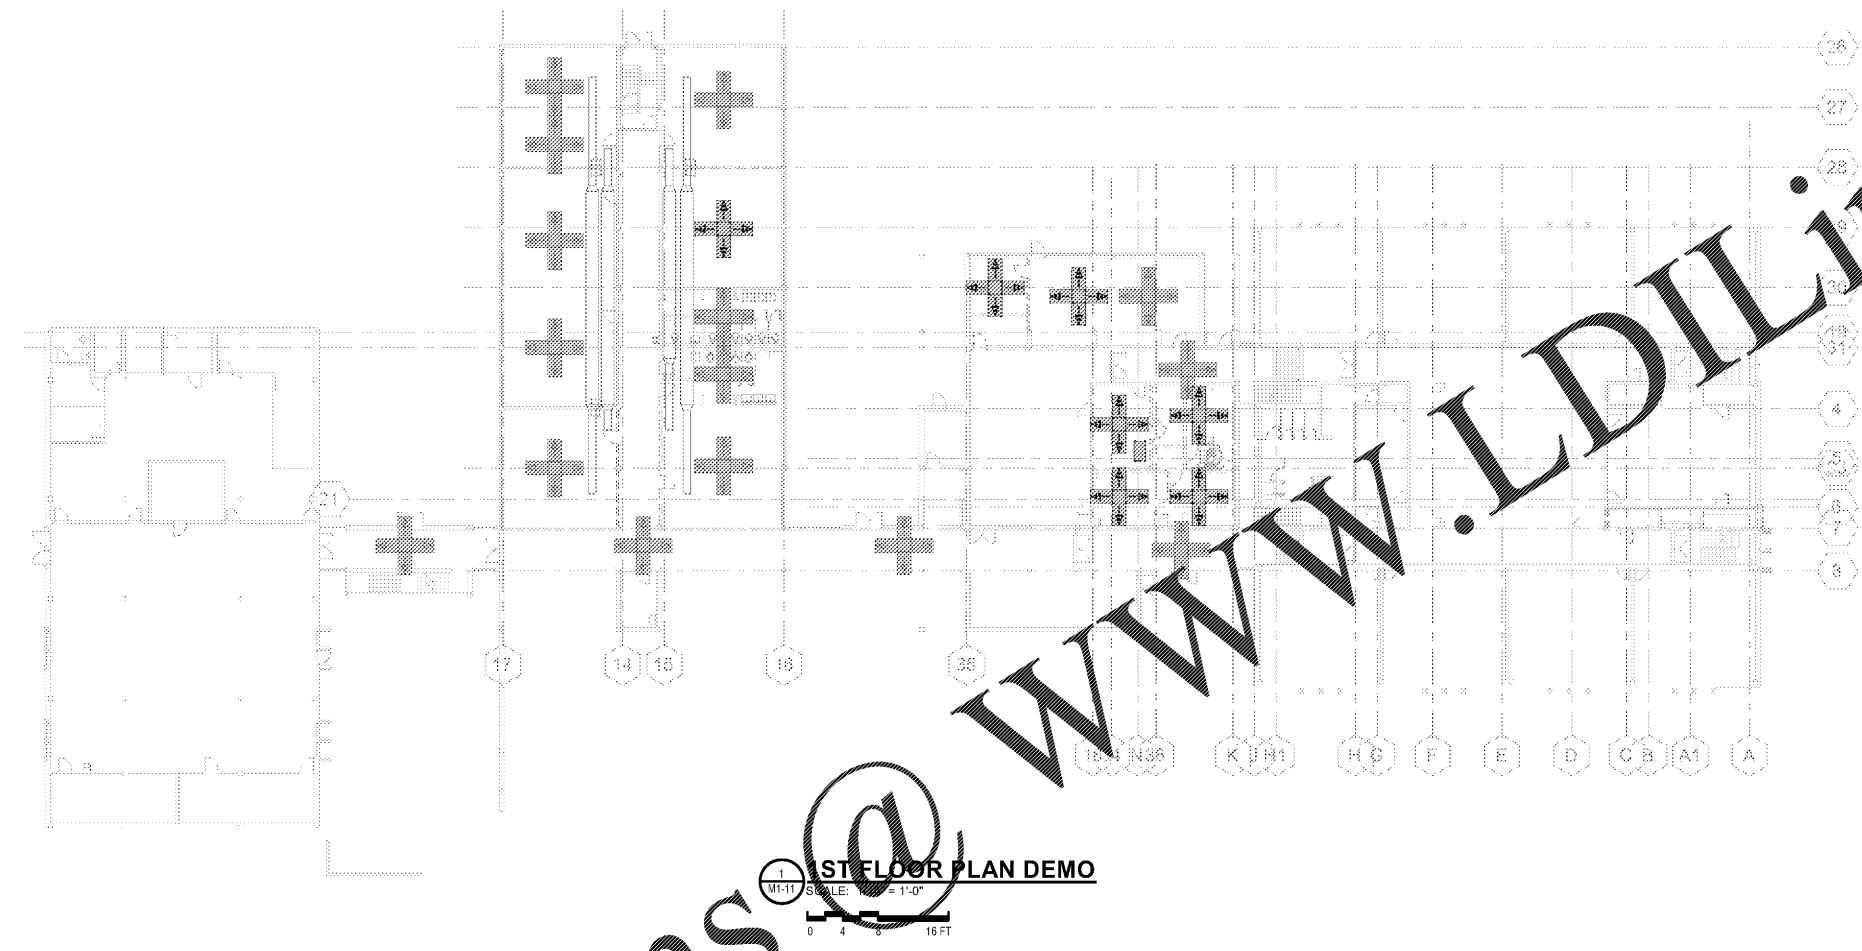

1 1ST FLOOR PLAN DEMO
SCALE: 1/8" = 1'-0"
0 4 8 16 FT

Order Plans @

WWW.LDILine.com

PROJECT NUMBER: CC-201715-JSA#19-543 PROJECT NAME: BARACK & MICHELLE OBAMA ACADEMY
SHEET NUMBER: M1-11 - 1ST FLOOR HVAC DEMO - OVERALL
C:\Users\gpark\Documents\19-543 BarMO Academy_gpark\jssace.com.rvt
3/16/2020 5:13:04 PM

FTE - 450
EXISTING IU - 38
PROPOSED IU - 33

BARACK & MICHELLE OBAMA ACADEMY



970 Martin St SE, Atlanta, GA 30315
ATLANTA PUBLIC SCHOOLS

1ST FLOOR HVAC DEMO - OVERALL

ICMA
CONSULTING ENGINEERS
USA
Johnson, Spellman & Associates, Inc.
350 Research Court, Suite 130
Peachtree Corners, GA 30092
770-447-3555 www.jsaice.com

THW CC #201715 - JSA #19J543
Principal Charge
SPB Project No. 031620
Project Manager Date

Drawn By
Checked By
Reviewed By
Date

M1-11

NOT ISSUED FOR CONSTRUCTION