



COOPER CARRY
THE CENTER FOR CONNECTIVE ARCHITECTURE

191 Peachtree Street NE
Suite 2400
Atlanta, GA 30303-1770
(404) 237-2000
coopercarry.com

GENERAL NOTES

1. SEE SHEET M1-00 FOR HVAC GENERAL NOTES

KEY NOTES

○ INSTALL NEW AHU/CU AS SHOWN. NEW UNIT SHALL PROVIDE MEDIUM PRESSURE AIR TO MULTIPLE VAV TERMINAL UNITS AS SHOWN ON SHEET M1-16.


02/18 COOPER CARRY

SCOPE DOCUMENTS

The Contract Documents Issued for [Conceptual Design, Schematic Design, Design Development, Partial Construction Documents or Other Issuance up to Issued for Construction] are intended to be at that level of development and as such, may be neither complete nor coordinated. The [Construction Manager, Contractor, Design/Builder] is responsible for complete and coordinated pricing [and execution] of the Work, and shall include items necessary for the proper execution and completion of the Work, as shown, specified, reasonably inferred or required for a complete Project. For Work of designed design, systems, assemblies, components and materials shall comply with national, state and local code requirements. The [Construction Manager, Contractor, Design/Builder] shall inform the Owner and Architect, in timely fashion, of any discovered omissions, inconsistencies or errors in the Contract Documents.

ISSUANCES

| No. | Drawing Issue Description | Date |
|-----|---------------------------|------|
| | | |

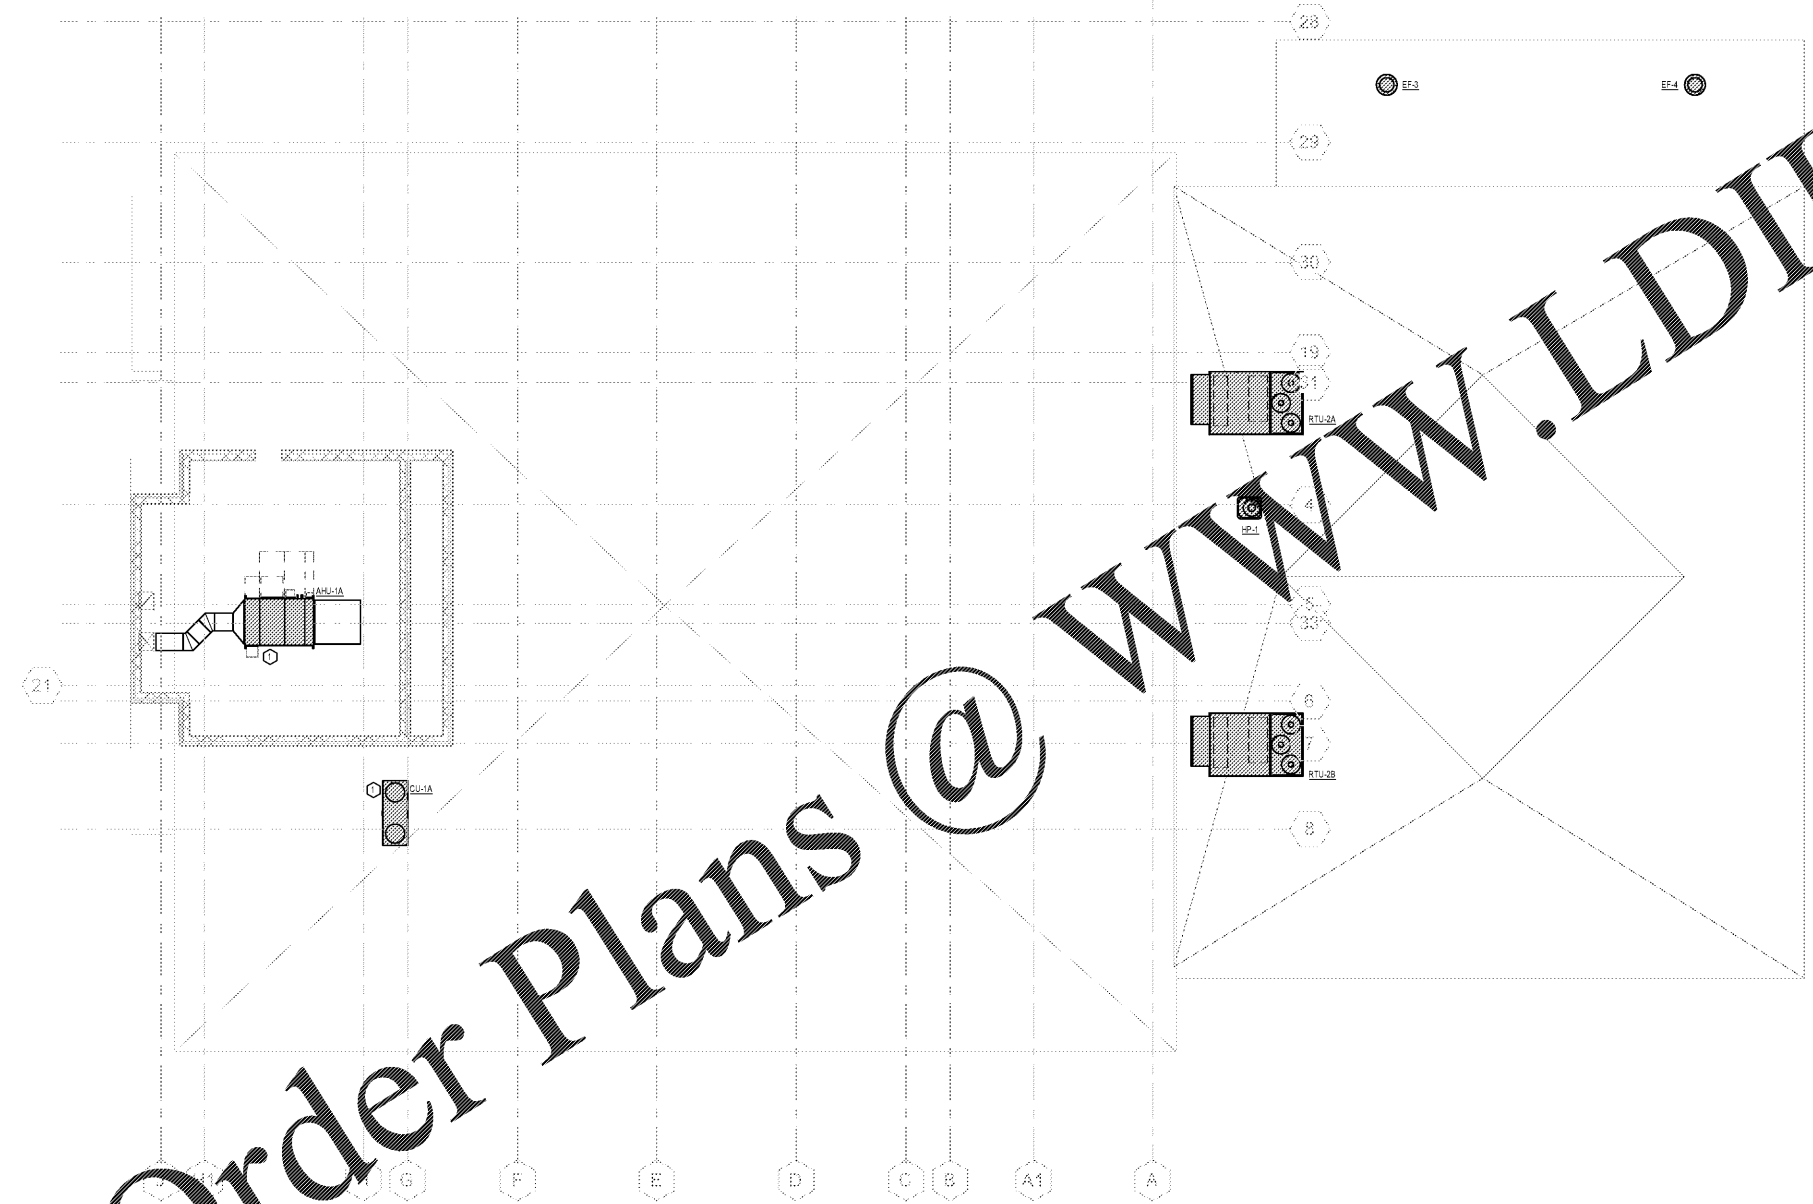

Order Plans @ www.LDILine.com

1 GYM ROOF
SCALE: 1/8" = 1'-0"
0 4 8 16 FT

FTE - 450
EXISTING IU - 38
PROPOSED IU - 33

BARACK & MICHELLE OBAMA ACADEMY



970 Martin St SE, Atlanta, GA 30315
ATLANTA PUBLIC SCHOOLS

ROOF HVAC PLAN - OVERALL



Johnson, Spellman & Associates, Inc.
350 Research Court, Suite 130
Peachtree Corners, GA 30092
770-447-3555 www.jsa-inc.com

| | |
|------------------|---------------------------|
| THW | CC #201715 - JSA # 19J543 |
| Principal Charge | Project No. |
| SPB | 031620 |
| Project Manager | Date |
| SPB | |
| Drawn By | |
| | |
| | |

M1-71

NOT ISSUED FOR CONSTRUCTION

PROJECT NUMBER: CC # 201715 - JSA # 19J543 PROJECT NAME: BARACK & MICHELLE OBAMA ACADEMY
SHEET NUMBER: M1-71 - ROOF HVAC PLAN - OVERALL
C:\Users\gmark\Documents\19J543 BarMO Academy_gmark@jsa.com.rvt
3/16/2020 5:15:17 PM