



COOPER CARRY
THE CENTER FOR CONNECTIVE ARCHITECTURE

191 Peachtree Street NE
Suite 2400
Atlanta, GA 30303-1770
(404) 237-2000
coopercarry.com




60119 COOPER CARRY

SCOPE DOCUMENTS

The Contract Documents issued for [Conceptual Design, Schematic Design, Design Development, Partial Construction Documents or Other Issuance up to Issued for Construction] are intended to be at that level of development and as such, may be neither complete nor coordinated. The [Construction Manager, Contractor, Design/Builder] is responsible for complete and coordinated pricing [and execution] of the Work, and shall include items necessary for the proper execution and completion of the Work, as shown, specified, reasonably inferred or required for a complete Project. For Work of integrated design, systems, assemblies, components and materials shall comply with national, state and local code requirements. The [Construction Manager, Contractor, Design/Builder] shall inform the Owner and Architect, in timely fashion, of any discovered omissions, inconsistencies or errors in the Contract Documents.

ISSUANCES

No.	Drawing Issue Description	Date
1	DESIGN DEVELOPMENT	3/18/20

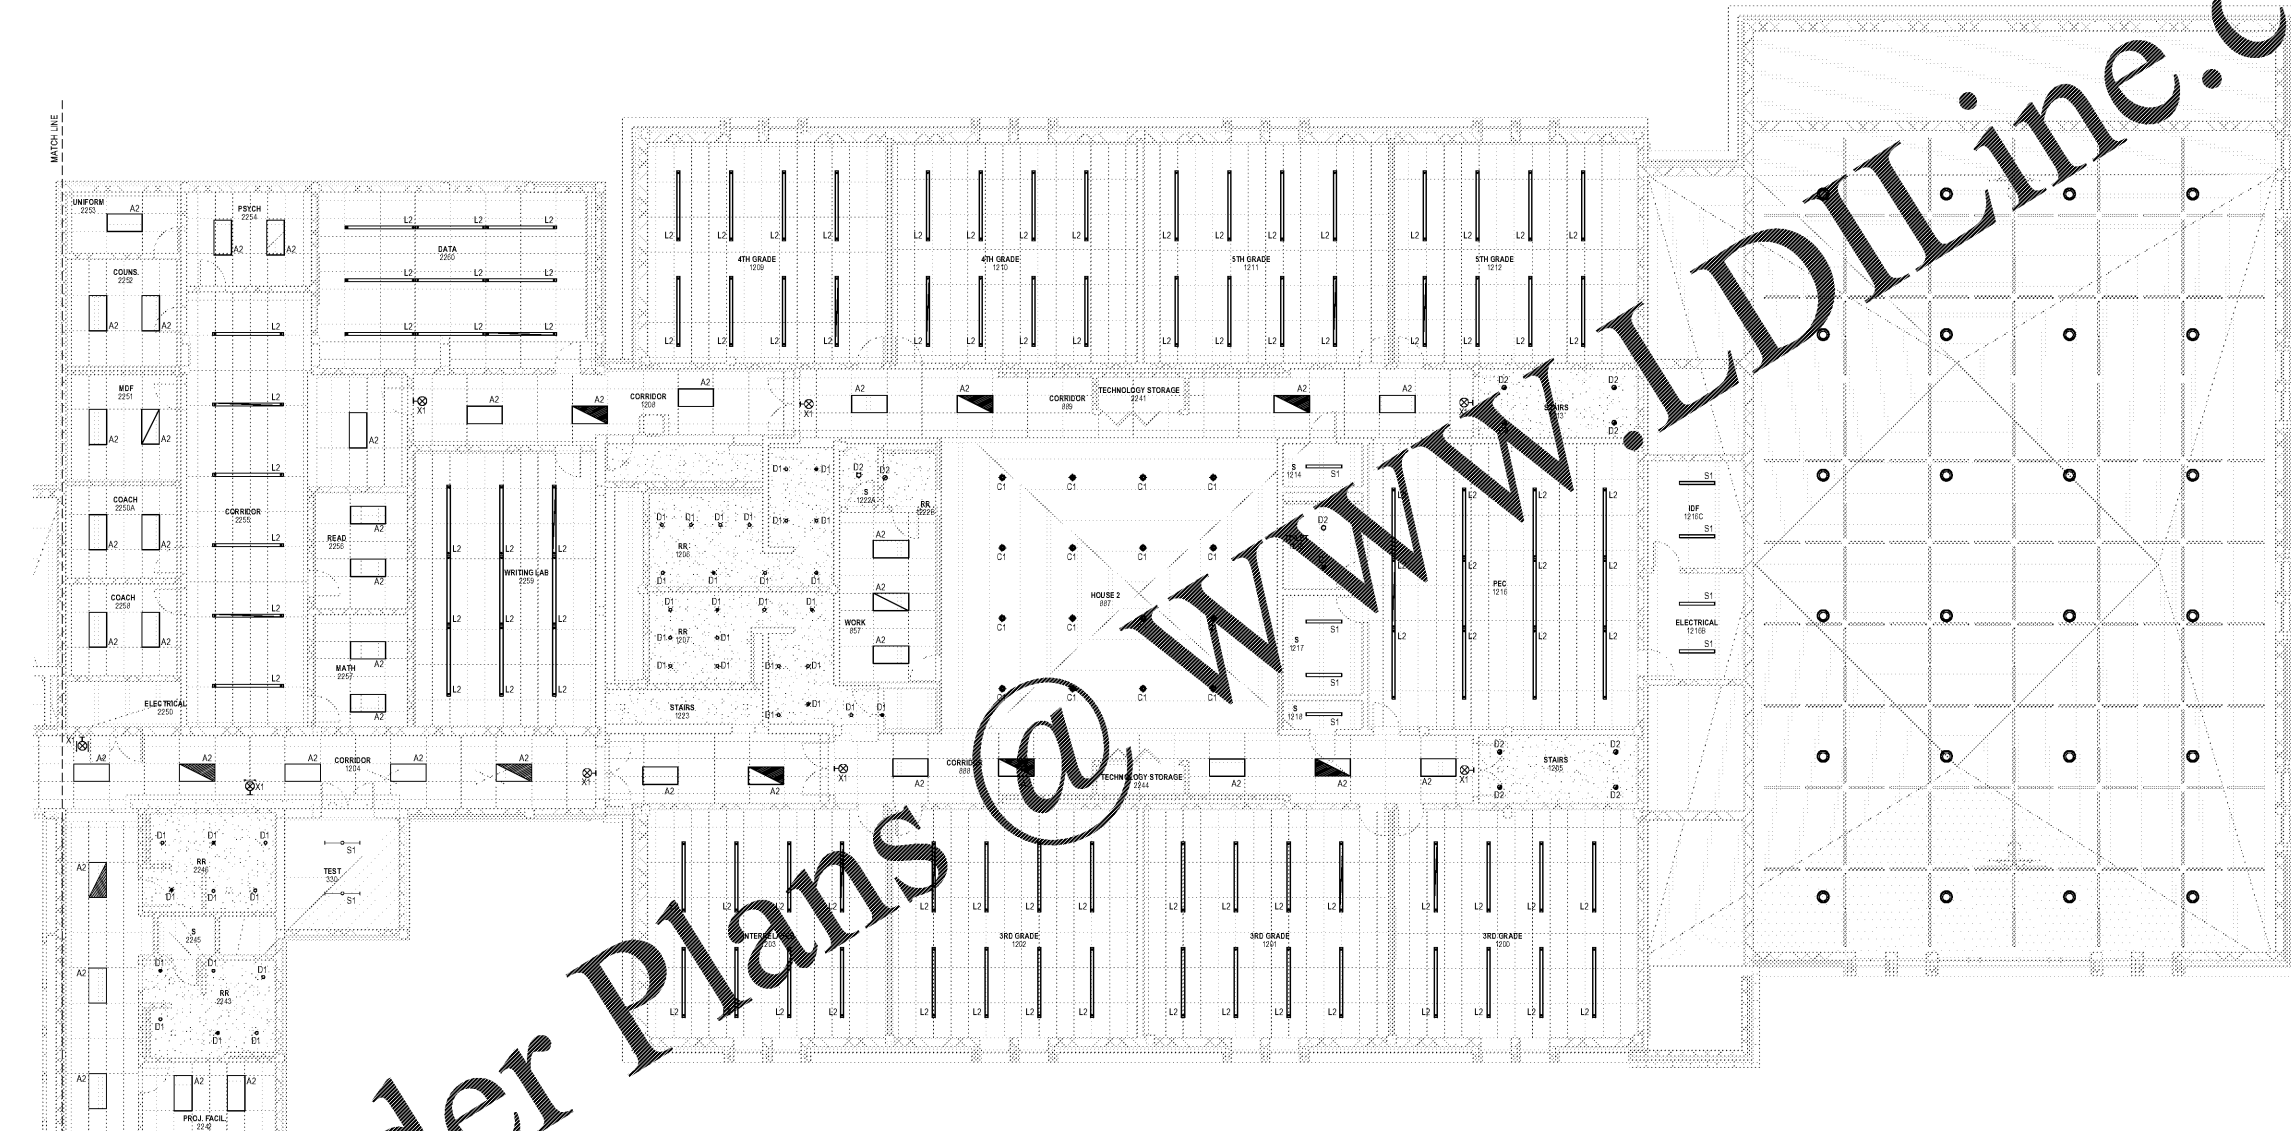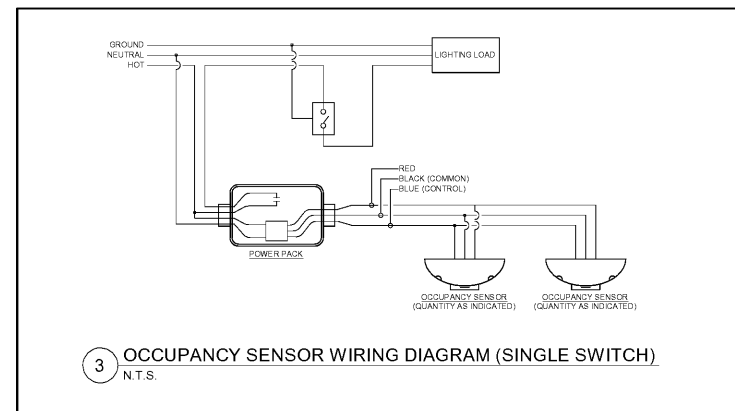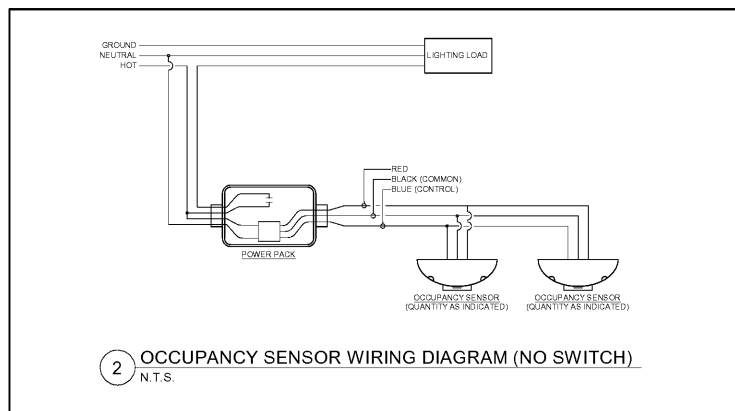

1 ELECTRICAL PARTIAL LIGHTING PLAN - LEVEL 2 - AREA B
1/8" = 1'-0"

Order Plans @ www.LDILine.com

PROJECT NUMBER: 20190109 PROJECT NAME: BARACK & MICHELLE OBAMA ACADEMY
SHEET NUMBER: E3.22 ELECTRICAL PARTIAL LIGHTING PLAN UPPER LEVEL AREA B
C:\Egnyte\Shared\Drawings\9000's\9040 - BMO School\Electrical\9040 - BMO Academy - Electrical (R19).rvt
3/16/2020 4:21:31 PM

FTE - 450
EXISTING IU - 38
PROPOSED IU - 33

**BARACK & MICHELLE OBAMA
ACADEMY**



970 Martin St SE, Atlanta, GA 30315
ATLANTA PUBLIC SCHOOL

ELECTRICAL PARTIAL LIGHTING PLAN
UPPER LEVEL AREA B

ROBERT JUST Principal/Designer	20190109
S. TARKHAN Project Manager	03/02/20
B. FERREN Project Architect	DATE
E. SAADAT Staff Architect	
B. FERREN, J. J. KLEIN Interior Designer	

E3.22