


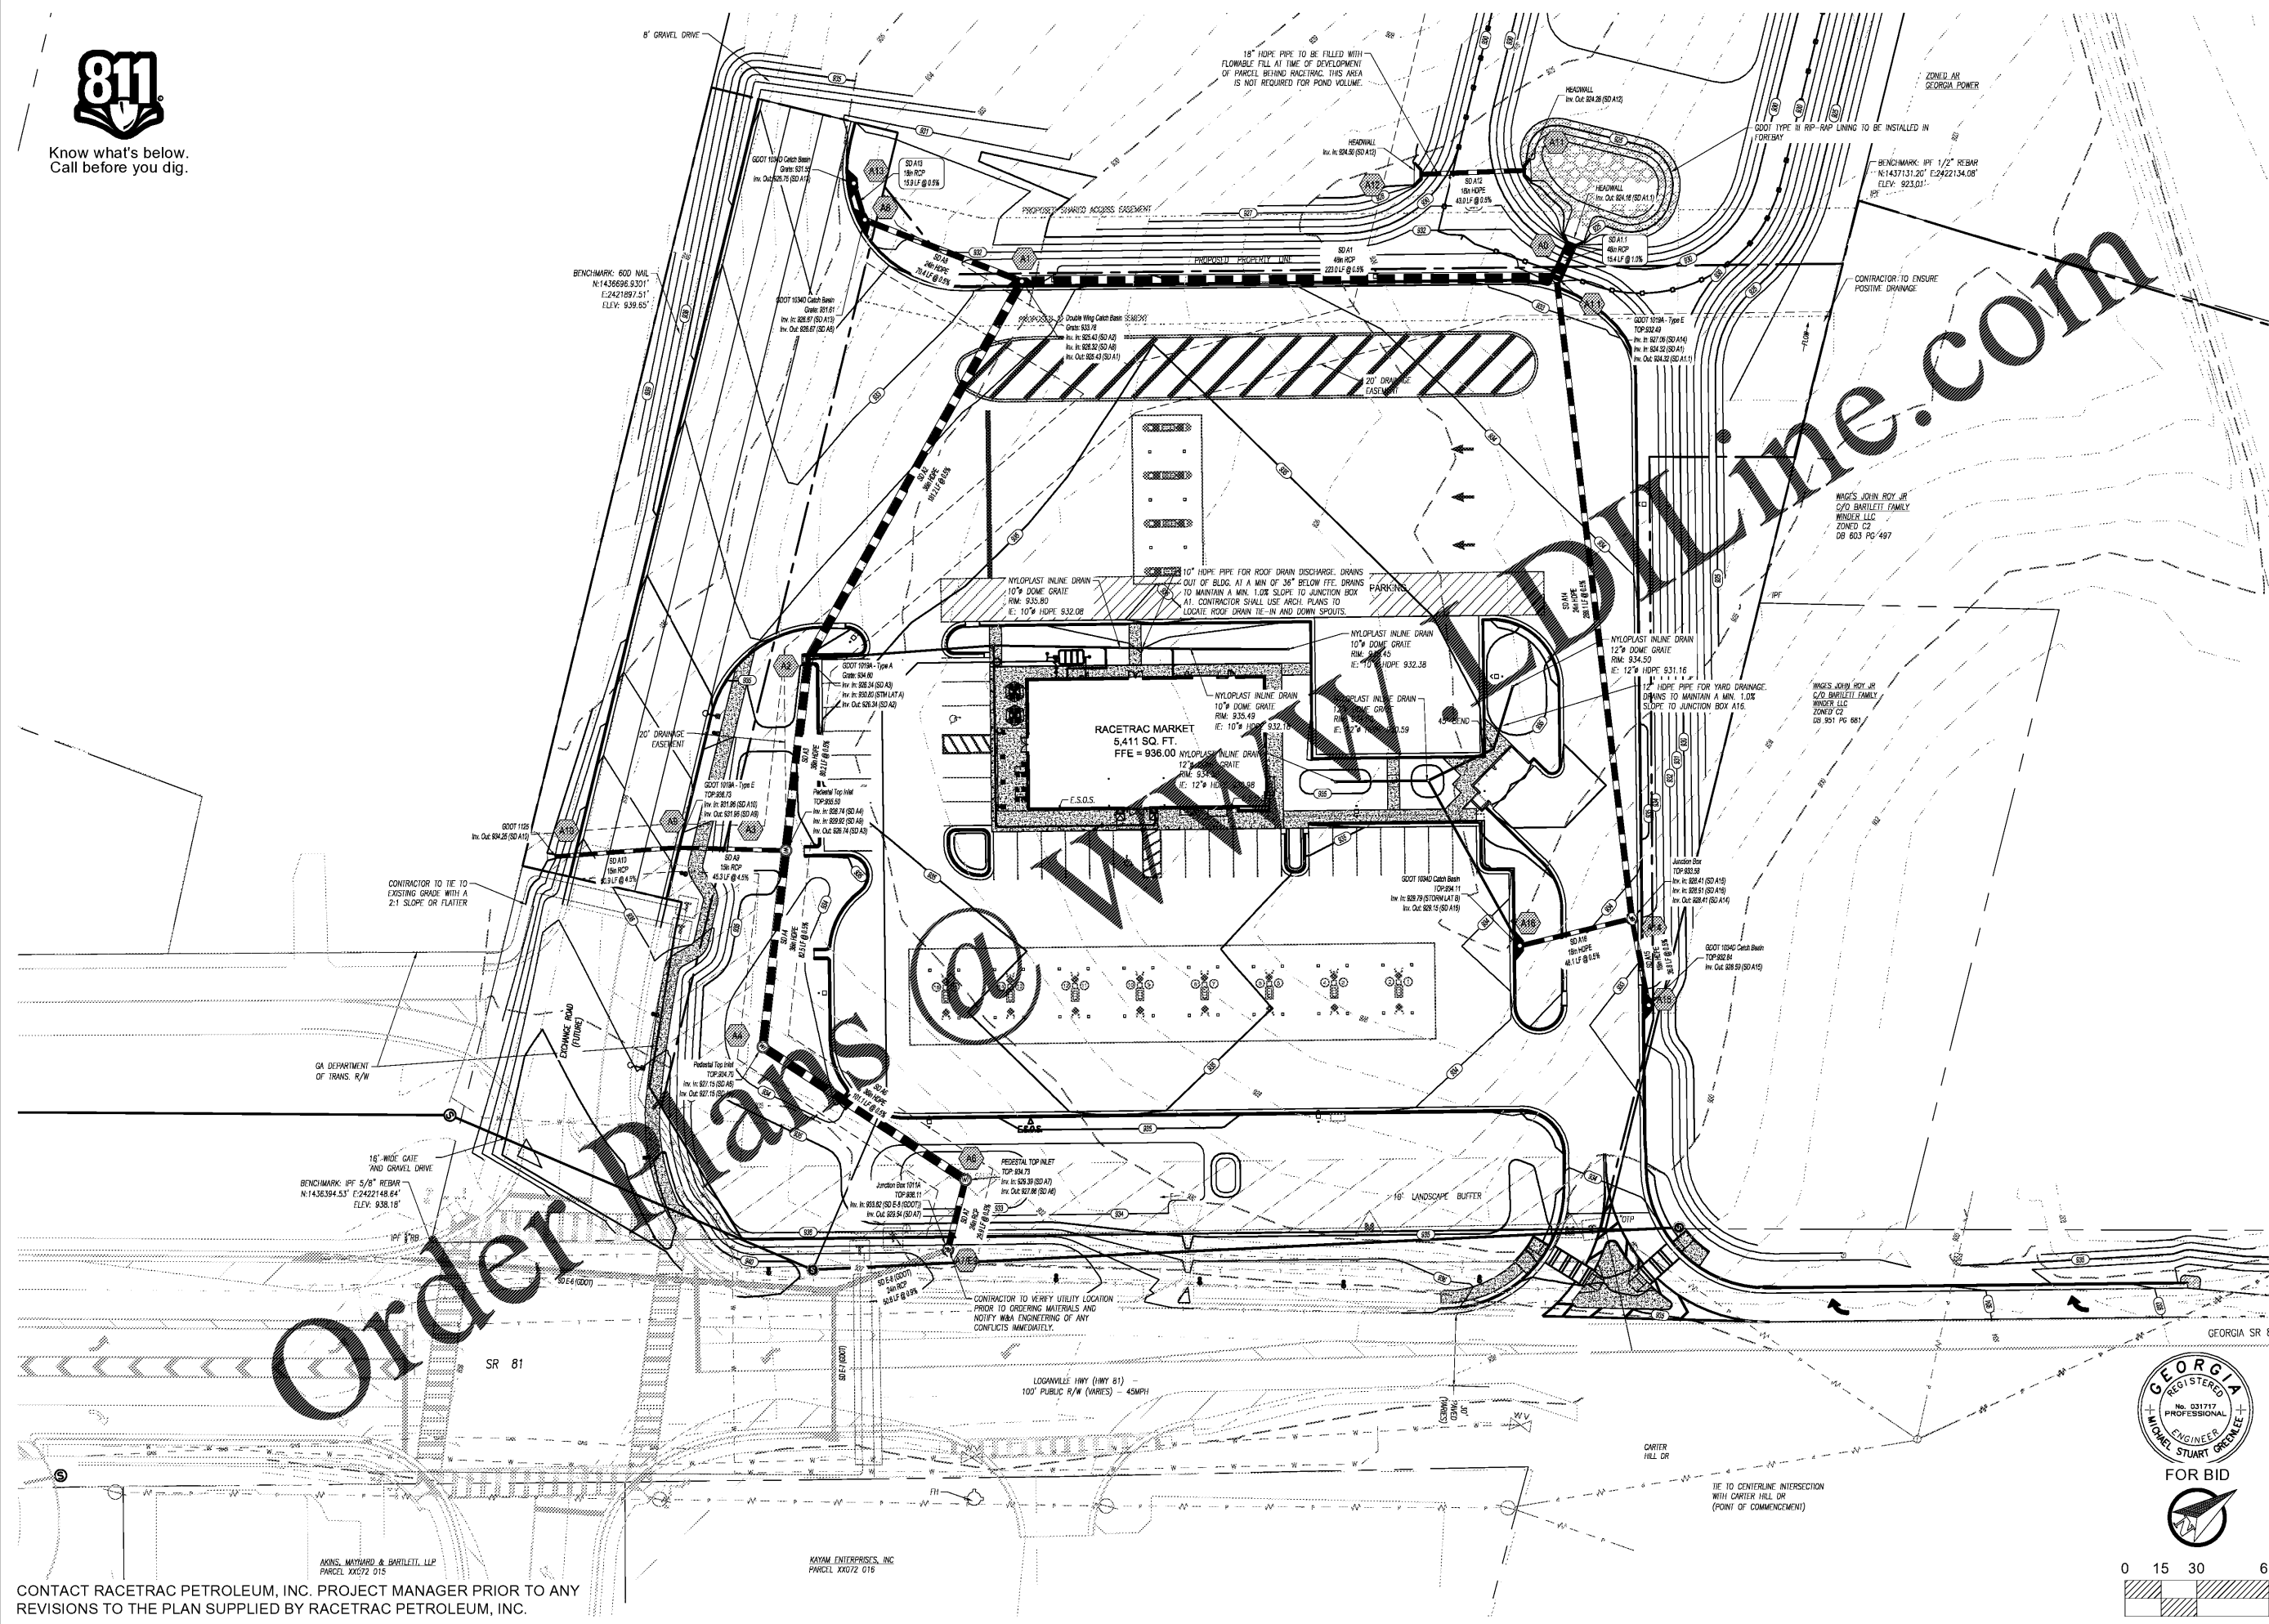

Know what's below.
Call before you dig.

 


Order Plans

W&A ONLINE.com



FOR BID



CONTACT RACETRAC PETROLEUM, INC. PROJECT MANAGER PRIOR TO ANY REVISIONS TO THE PLAN SUPPLIED BY RACETRAC PETROLEUM, INC.

AKINS, MAYNARD & BAZILETTI, LLP
PARCEL XX072 015

KAYAM ENTERPRISES, INC
PARCEL XX072 016

02.24.2020	7	REVISED PER DEVELOPER CHANGES	NO.
10.07.2019	6	REVISED PER DEVELOPER CHANGES	NO.
01.14.2019	5	REVISED PER GDOT & RACETRAC COMMENTS	NO.
12.03.2018	4	REVISED PER GDOT & RACETRAC COMMENTS	NO.
10.05.2018	3	REVISED PER BARROW COUNTY, GASWCC & RACETRAC COMMENTS	NO.
08.01.2018	2	REVISED PER BARROW COUNTY, GASWCC & RACETRAC COMMENTS	NO.
05.17.2018	1	REVISED PER BARROW COUNTY, GASWCC & RACETRAC COMMENTS	NO.

DATE	NO.	DESCRIPTION
02.24.2020	7	REVISED PER DEVELOPER CHANGES
10.07.2019	6	REVISED PER DEVELOPER CHANGES
01.14.2019	5	REVISED PER GDOT & RACETRAC COMMENTS
12.03.2018	4	REVISED PER GDOT & RACETRAC COMMENTS
10.05.2018	3	REVISED PER BARROW COUNTY, GASWCC & RACETRAC COMMENTS
08.01.2018	2	REVISED PER BARROW COUNTY, GASWCC & RACETRAC COMMENTS
05.17.2018	1	REVISED PER BARROW COUNTY, GASWCC & RACETRAC COMMENTS

 W&A Engineering CIVIL ENGINEERING - LANDSCAPE ARCHITECTURE ARCHITECTURE - SOIL AND ENVIRONMENTAL INVESTIGATION TRAFFIC ENGINEERING - TECHNICAL SURVEYING	Racetrac RACETRAC PETROLEUM, INC. 200 GALLERIA PARKWAY SE SUITE 900 ATLANTA, GA 30339 (770) 431-7600
--	---

DRAINAGE PLAN RACETRAC 316@81 839 Loganville Highway Bethlehem, Georgia Barrow County	DRAWN-BY: AGRUNER DATE: 02.28.2018 SCALE: 1" = 30' DRAWING NAME: Consol-17293.dwg SHEET NO: C7 VERSION:
---	--