


2 FLOOR PLAN MENS RESTROOM
1/2" = 1'-0"

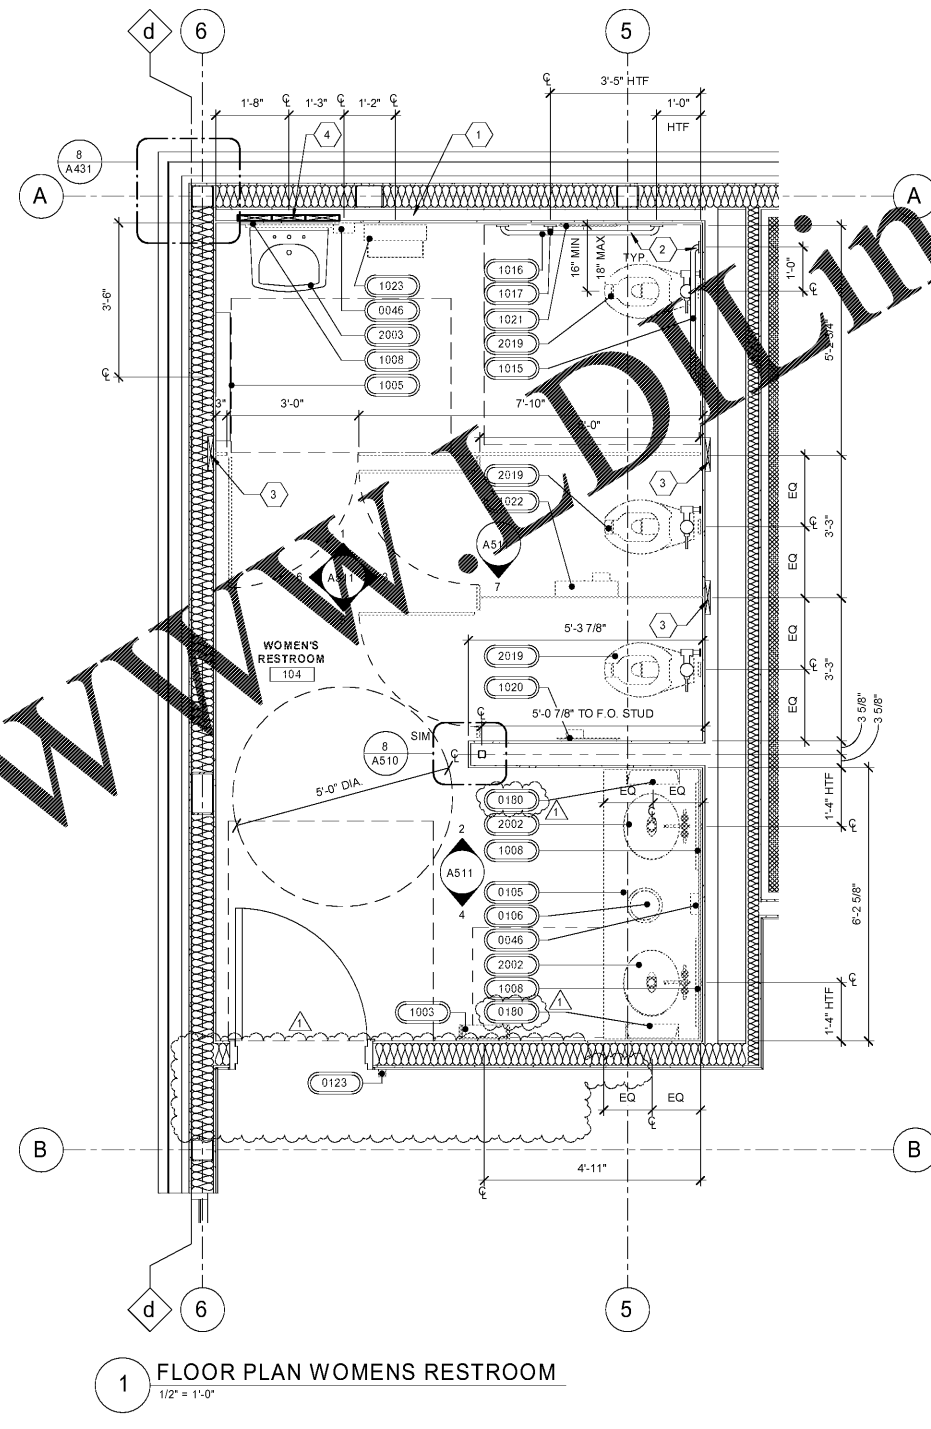

1 FLOOR PLAN WOMENS RESTROOM
1/2" = 1'-0"

Order Plans @ WWW.IDLINE.COM

GENERAL NOTES

1. ALL DIMENSIONS ARE TAKEN TO FACE OF FINISH UNLESS NOTED OTHERWISE.
2. WHEN INSTALLED AT THE LOCATIONS AND MOUNTING HEIGHT INDICATED, THE SPECIFIED FIXTURES PROVIDE FOR CLEAR SPACES, CLEARANCES AND MOUNTING HEIGHTS SHALL BE IN COMPLIANCE WITH APPLICABLE ACCESSIBILITY CODES.
3. INSTALL ACCESSORIES AND LIGHT FIXTURES WITH SCREWS OR BOLTS EXTENDING AT LEAST 1" INTO SOLID BLOCKING.
4. GREEN BOARD CEILING TYPICAL.
5. FOR TOILET ACCESSORIES, SEE EQUIPMENT SCHEDULE 1000 SERIES. FOR PLUMBING FIXTURES, SEE EQUIPMENT SCHEDULE 2000 SERIES.
6. INSTALL TILE TO HAVE A MAX. GROUT JOINT OF 1/8". SEE FINISH SCHEDULE A500 FOR COLORS.
7. PROVIDE BLOCKING BEHIND ALL ACCESSORIES.
8. TOILET STALL DOOR FRAME ASSEMBLY SHALL BE SECURED TO PARTITION WALL STRUCTURE. DOOR FRAME SHALL BE MOUNTED DIRECTLY TO 3-5/8" METAL STUD FRAMING FOR STRUCTURAL SUPPORT.
9. REFER TO ELEVATION A510 FOR BABY CHANGING STATION INSTALLATION INSTRUCTIONS.
10. INSULATE PIPES AND FITTINGS AND EXPOSED HOT WATER PIPES WITH PREPARED INSULATION WITH WHITE PVC FINISH. REFER TO SPECIFICATIONS IN A510 SERIES FOR EXTERIOR WALL INSULATION.

SHEET KEYNOTES

- 1 FUR OUT WALL WITH 3 5/8" METAL STUDS FLUSH WITH 6" PERIMETER STUDS TO ACCOMMODATE RESTROOM ACCESSORIES AND FIXTURES.
- 2 PROVIDE 2X10 BLOCKING FOR GRAB BARS. INSTALL PER MANUFACTURERS RECOMMENDATIONS. SEE A511 FOR HEIGHT.
- 3 PROVIDE 2X10 BLOCKING FOR PARTITION. INSTALL PER MANUFACTURERS RECOMMENDATIONS.
- 4 PROVIDE 2X10 BLOCKING FOR ADA SINK. INSTALL PER MANUFACTURERS RECOMMENDATIONS.

ENLARGED RESTROOM PLAN LEGEND

HTF HOLD TO FINISH

RaceTrac.
COPYRIGHT NOTICE
THESE PLANS ARE SUBJECT TO FEDERAL COPYRIGHT LAWS; ANY USE OF SAME WITHOUT THE EXPRESSED WRITTEN PERMISSION OF RACETRAC PETROLEUM, INC. IS PROHIBITED. 2016 RACETRAC PETROLEUM, INC.

DESIGN PROFESSIONALS

GPD GROUP
Professional Corporation
520 S. MAIN STREET, STE 2531
AKRON, OH 44311

ISSUE/REVISION RECORD

DATE	DESCRIPTION
01/25/19	PERMIT SET
03/16/20	REFRESH TO 2020.0113

RaceTrac.
RACETRAC PETROLEUM, INC.
200 GALLERIA PARKWAY SOUTHEAST
SUITE 900
ATLANTA, GEORGIA 30339
(770) 431-7600

PROJECT NAME
HWY 316 @ 81

BETHLEHEM
GA 30620
839 LOGANVILLE HWY

RACETRAC STORE NUMBER
#1304

PROTOTYPE SERIES 5.5K 2.0
2018 LH MO 0405

PLAN MODIFICATION NOTICE
SPB NO. 0405 DATE 12/18/18

STANDARD PLAN BULLETINS (SPB) MODIFY THE PROTOTYPE SERIES SET NOTED ABOVE. THE LISTED SPB REPRESENTS THE LATEST MODIFICATION INCORPORATED TO THIS PROTOTYPE SERIES SET AT ORIGINAL RELEASE. THE ISSUE/REVISION RECORD COLUMN ABOVE LISTS ANY REVISIONS OR SPB INCORPORATED IN THIS SET AFTER THE ORIGINAL RELEASE. CONTACT RACETRAC ENGINEERING AND CONSTRUCTION FOR ANY SUBSEQUENT BULLETINS NOT INCORPORATED HEREIN.

PROFESSIONAL SEAL

PROJECT NUMBER
2018157.19

SHEET TITLE
RESTROOM
ENLARGED PLAN

SHEET NUMBER
A123