


Order Plans @ www.LDILine.com

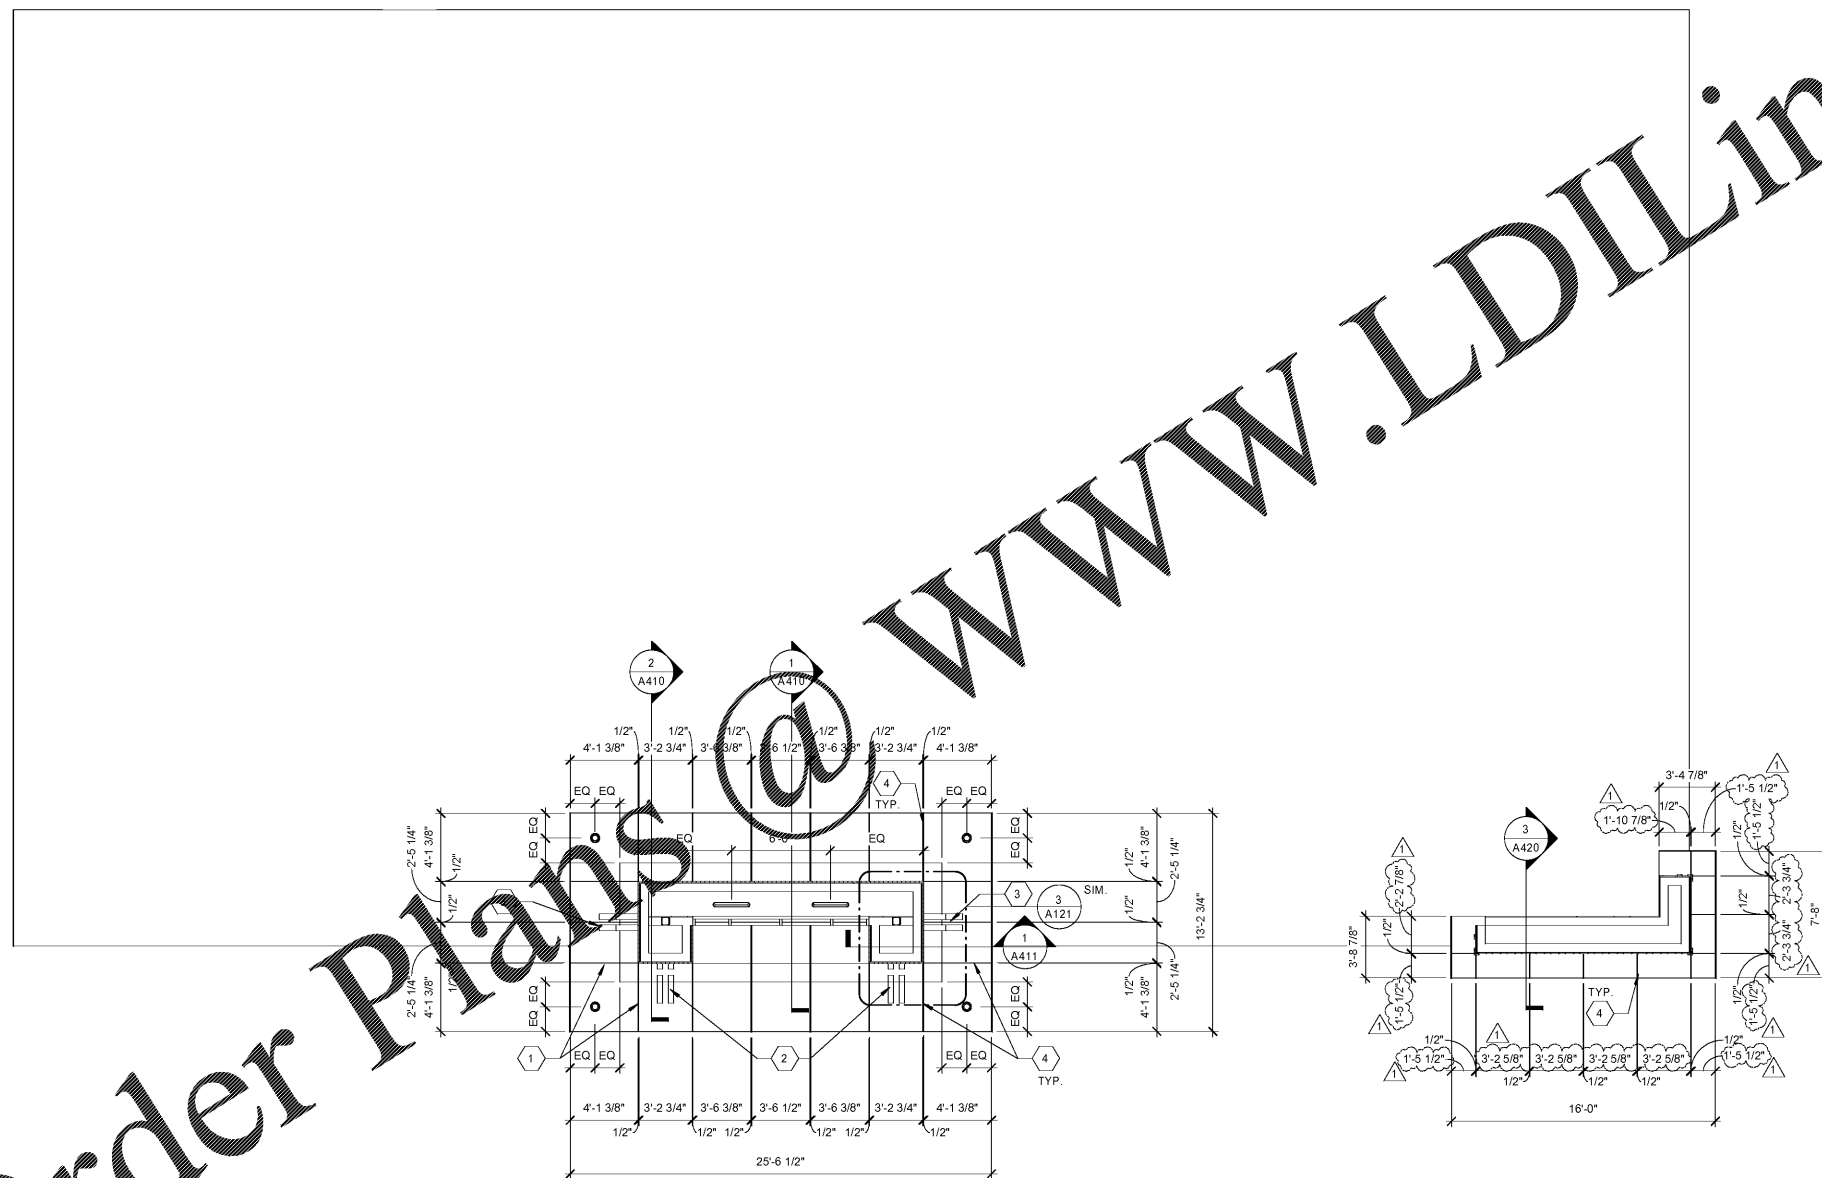

GENERAL NOTES

1. ALL DIMENSIONS ARE TO FACE OF FINISH UNLESS NOTED OTHERWISE.
2. REFER TO SHEET A500 FOR INTERIOR FINISH LEGEND.
3. REFER TO ELECTRICAL SHEETS FOR LIGHTING FIXTURE SCHEDULE.
4. REFER TO MECHANICAL SHEETS FOR DIFFUSER SCHEDULE.
5. REFER TO WALL SECTIONS FOR SOFFIT CONSTRUCTION. ALL SOFFITS SHALL BE CONSTRUCTED OF ARMSTRONG DRYWALL CEILING GRIDS UNLESS OTHERWISE INDICATED.

SHEET KEYNOTES

1. ALIGN JOINT WITH PIER TYPICAL OF ALL ACM JOINTS AT PIERS
2. BRACKET TYPE B
3. BRACKET TYPE E
4. ACM PANEL REVEAL LINE

REFLECTED CEILING PLAN LEGEND

- EXTERIOR LIGHT FIXTURE
- SURFACE MOUNTED LIGHT FIXTURE
- DIRECTIONAL LIGHT FIXTURE
- LIGHT FIXTURE
- 2x4 LIGHT FIXTURE
- 2x4 LIGHT FIXTURE
- 4\"/>
- 6\"/>
- EXIT SIGN
- EXTERIOR WALL MOUNTED CEILING FAN
- EXTERIOR GRADE RECESSED SPEAKER
- SLOT DIFFUSER
- 2x2 CEILING DIFFUSER
- 2x2 RETURN AIR GRILLE
- 2x4 RETURN AIR GRILLE
- RESTROOM DIFFUSER
- RESTROOM EXHAUST
- ACOUSTICAL CEILING TILE
- GYPSUM WALL BOARD CEILING
- EXTERIOR SOFFIT MATERIAL - EIFS (EF-1)
- EXTERIOR SOFFIT MATERIAL COLOR TO MATCH SW #6113 INTERACTIVE CREAM
- WOOD LOOK CEILING MANUFACTURED SOFFIT

RaceTrac
COPYRIGHT NOTICE
 THESE PLANS ARE SUBJECT TO FEDERAL COPYRIGHT LAWS; ANY USE OF SAME WITHOUT THE EXPRESSED WRITTEN PERMISSION OF RACETRAC PETROLEUM, INC. IS PROHIBITED. 2016 RACETRAC PETROLEUM, INC.

DESIGN PROFESSIONALS

GPD GROUP
 Professional Corporation
 520 S. MAIN STREET, STE 2531
 AKRON, OH 44311

ISSUE/REVISION RECORD

DATE	DESCRIPTION
01/25/19	PERMIT SET
03/16/20	REFRESH TO 2020.0113

RaceTrac
RACETRAC PETROLEUM, INC.
 200 GALLERIA PARKWAY SOUTHEAST
 SUITE 900
 ATLANTA, GEORGIA 30339
 (770) 431-7600

PROJECT NAME
HWY 316 @ 81

BETHLEHEM
GA 30620
839 LOGANVILLE HWY

RACETRAC STORE NUMBER
#1304

PROTOTYPE SERIES 5.5K 2.0
2018 LH MO 0405

PLAN MODIFICATION NOTICE
SPB NO. 0405 DATE 12/18/18

STANDARD PLAN BULLETINS (SPB) MODIFY THE PROTOTYPE SERIES SET NOTED ABOVE. THE LISTED SPB REPRESENTS THE LATEST MODIFICATION INCORPORATED TO THIS PROTOTYPE SERIES SET AT ORIGINAL RELEASE. THE ISSUE/REVISION RECORD COLUMN ABOVE LISTS ANY REVISIONS OR SPB INCORPORATED IN THIS SET AFTER THE ORIGINAL RELEASE. CONTACT RACETRAC ENGINEERING AND CONSTRUCTION FOR ANY SUBSEQUENT BULLETINS NOT INCORPORATED HEREIN.

PROFESSIONAL SEAL

PROJECT NUMBER
 2018157.19

SHEET TITLE
TOWER REFLECTED CEILING PLAN AND DETAILS

SHEET NUMBER
A151