

ISSUE/REVISION RECORD

DATE	DESCRIPTION
01/25/19	PERMIT SET
03/16/20	REFRESH TO 2020.0113

RaceTrac.

RACETRAC PETROLEUM, INC.
200 GALLERIA PARKWAY SOUTHEAST
SUITE 900
ATLANTA, GEORGIA 30339
(770) 431-7600

PROJECT NAME

HWY 316 @ 81

**BETHLEHEM
GA 30620**

839 LOGANVILLE HWY

RACETRAC STORE NUMBER

#1304

PROTOTYPE SERIES 5.5K 2.0

2018 LH MO 0405

PLAN MODIFICATION NOTICE

SPB NO. 0405 DATE 12/18/18

STANDARD PLAN BULLETINS (SPB) MODIFY THE
PROTOTYPE SERIES SET NOTED ABOVE. THE
LISTED SPB REPRESENTS THE LATEST
MODIFICATION INCORPORATED TO THIS
PROTOTYPE SERIES SET AT ORIGINAL RELEASE.
THE ISSUE/REVISION RECORD COLUMN ABOVE
LISTS ANY REVISIONS OR SPB INCORPORATED IN
THIS SET AFTER THE ORIGINAL RELEASE.
CONTACT RACETRAC ENGINEERING AND
CONSTRUCTION FOR ANY SUBSEQUENT
BULLETINS NOT INCORPORATED HEREIN.

PROFESSIONAL SEAL

PROJECT NUMBER
2018157.19

SHEET TITLE
**PLUMBING
ROUGH-IN PLAN**

SHEET NUMBER

P100

LEGEND

FIRE - FIRE SPRINKLER RISER
C.W. - COLD WATER
D.W. - DOMESTIC WATER SERVICE
F.C.O. - CLEAN OUT
F.D. - FLOOR DRAIN
F.S. - FLOOR SINK
H.D. - HUB DRAIN
H.S. - HAND SINK
M.S. - MOP SINK

DATUM POINT REFERENCE

X. DIMENSIONS (HORIZONTAL) ARE TAKEN FROM THE CENTER OF COLUMN INDICATED BY THE DATUM POINT.
Y. DIMENSIONS (VERTICAL) ARE TAKEN FROM THE CENTER OF COLUMN INDICATED BY THE DATUM POINT.

LEGEND


DESCRIPTION/EQUIPMENT#

PIPE SIZE

Y (VERTICAL) DIMENSION FROM DATUM POINT.

X (HORIZONTAL) DIMENSION FROM DATUM POINT.

1. WALL MOUNTED DEVICES ARE DIMENSIONED TO WALL.
2. CEILING AND FLOOR MOUNTED DEVICES AND/OR PENETRATIONS ARE DIMENSIONED TO THE CENTER OF THE DEVICE/PENETRATION.

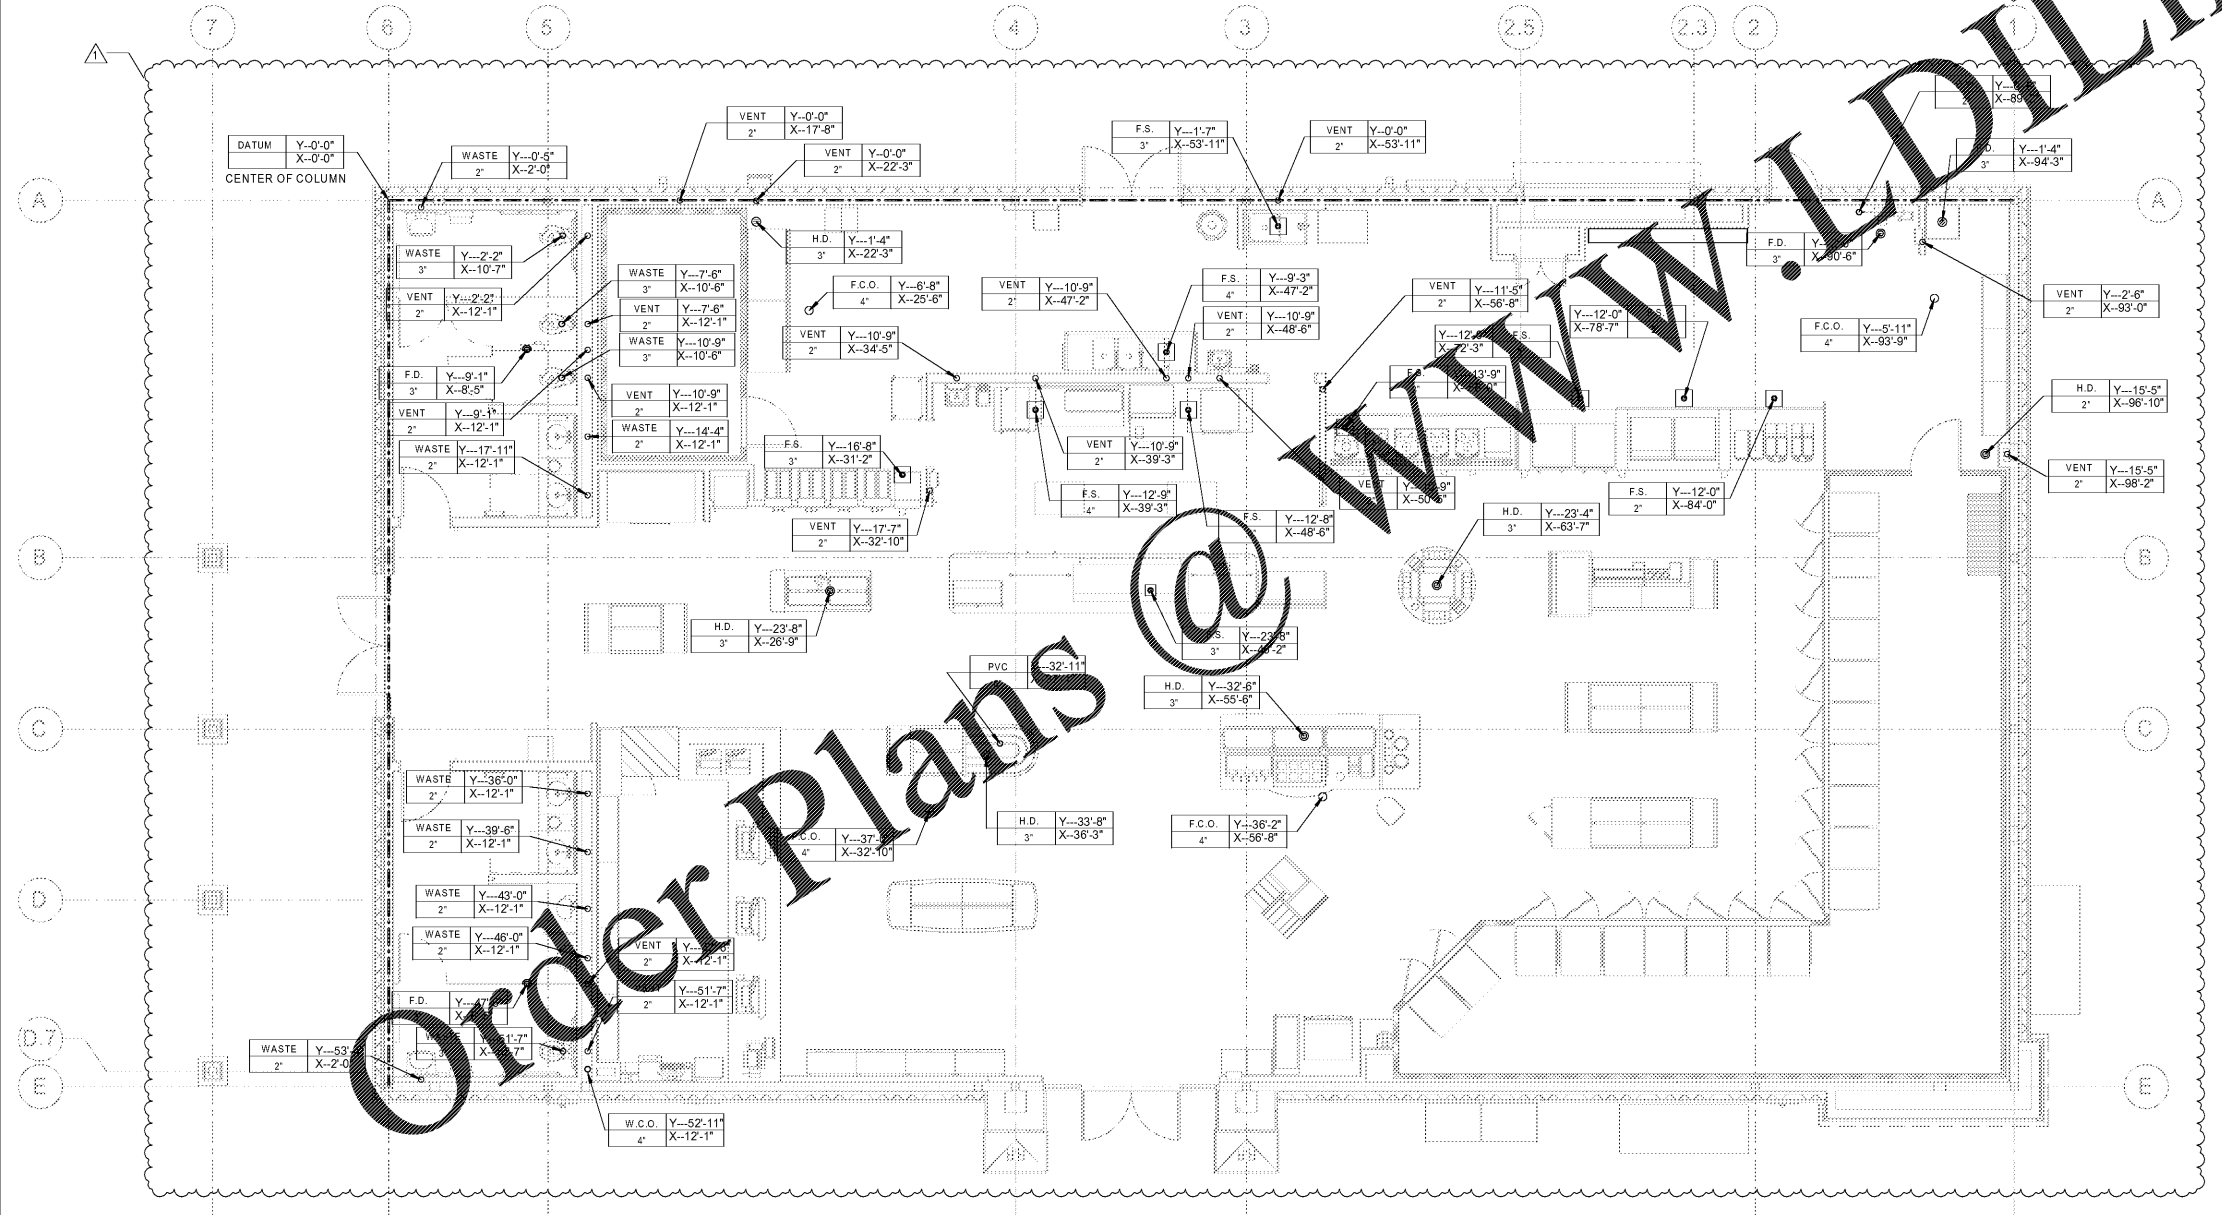

1 PLUMBING ROUGH-IN
3/16" = 1'-0"