



A
B
C
D
E
F
G
H
I
A
K
L
M
N

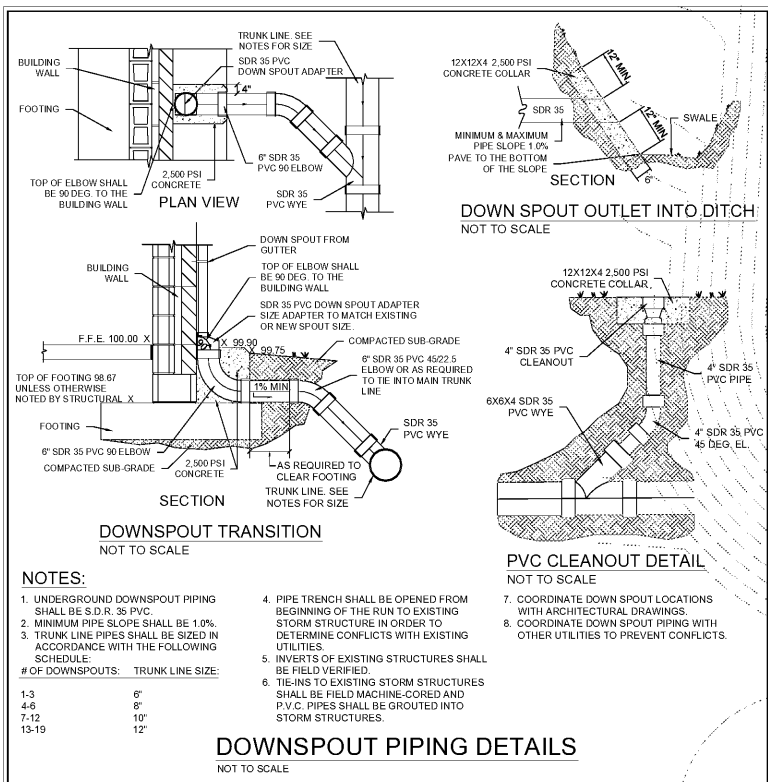

CAUTION:
 THE UTILITIES SHOWN ARE SHOWN FOR THE CONTRACTOR'S CONVENIENCE ONLY. OTHER UTILITIES MAY BE PRESENT BUT NOT SHOWN ON THESE DRAWINGS. THE ARCHITECT & ENGINEER ASSUME NO RESPONSIBILITY FOR THE UTILITY LOCATIONS SHOWN, AND IT SHALL BE THE CONTRACTOR'S RESPONSIBILITY TO DETERMINE THE EXACT LOCATIONS OF ALL UTILITIES WITHIN THE LIMITS OF THE WORK. ALL DAMAGE MADE TO THE EXISTING UTILITIES BY THE CONTRACTOR SHALL BE REPAIRED TO A "LIKE NEW" CONDITION. THE CONTRACTOR SHALL BEAR THE SOLE RESPONSIBILITY FOR ANY LOSSES THAT OCCUR FROM DAMAGES TO THE EXISTING UTILITIES.

Know what's below.
 Call before you dig.
Dial 811.
GEORGIA
 Safe digging is a SHARED responsibility, and in Georgia it's the law.
 811 or 1-800-282-7411
 www.Georgia811.com

Order Plans @ www.LDILine.com

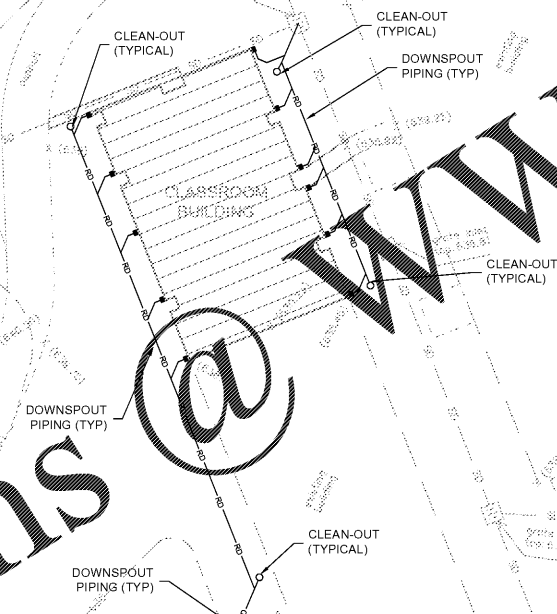

SCALE: 1" = 30'

SA&E PROJECT NUMBER	01-632-056	
BID PACKAGE	BP-1	
ISSUED FOR CONSTRUCTION	FEB. 4, 2020	
REVISIONS		
R #	Doc #	Date
1	AD01	02/13/2020

Southern AE
 7951 Troon Circle
 Austell, Ga 30168
 (770) 419-7777
 I.L.C.
 architects & engineers

FACILITY CODE NUMBER:
 (6) CLASSROOM ADDITIONS TO:
CREEKSIDE MIDDLE SCHOOL
 CATAULA, GA
HARRIS COUNTY BOARD OF EDUCATION
 HAMILTON, GA

DOWNSPOUT PIPING PLAN

DRAWING NUMBER
C103

STATE OF GEORGIA REGISTERED ARCHITECT
 GEORGIA REGISTERED ARCHITECT PATRIK D. HALLAMAN