


Order Plans

@

WWW.DIline.com

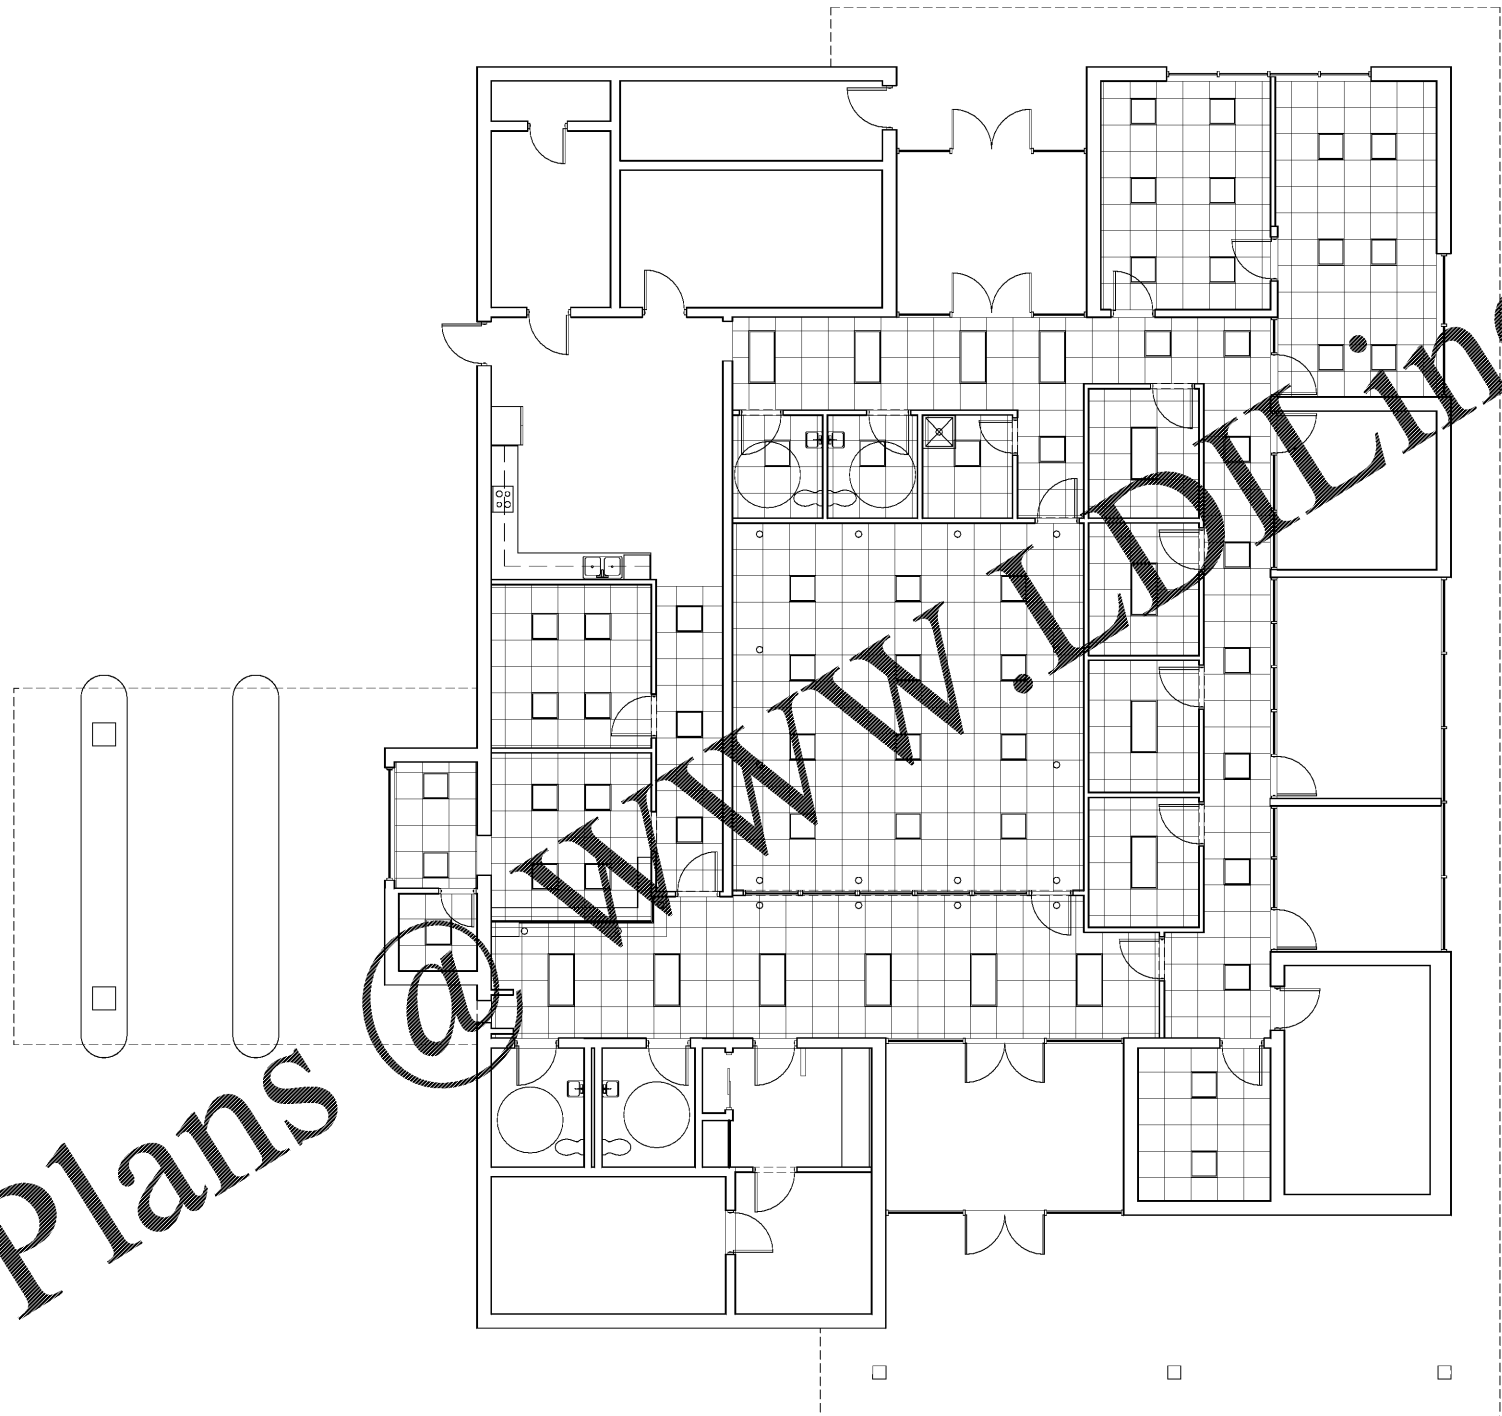

LEGEND

- 12" x 24" LED SURFACE MOUNTED FIXTURE
- 24" x 48" LED SURFACE MOUNTED FIXTURE
- 6" DIAMETER RECESSED CAN LIGHTING

GENERAL NOTES

ALL MECHANICAL, ELECTRICAL, & PLUMBING TO BE DESIGN BUILD
 ALL DATA CONNECTION LOCATIONS & DATA WIRING FOUND ON ELECTRICAL PLAN
 ALL WALLS ARE FULL HEIGHT TO CEILING


1 REFLECTED CEILING PLAN
 3/16" = 1'-0"

JUL 29 2019 11:38 AM C:\PROJECTS\Hogansville City Hall\Bldg\SheetA-104\REFLECTED CEILING PLAN.dwg

REVISIONS					
Number	Date:	Remarks:	Number	Date:	Remarks:
X	00-00-00	N/A			

CONSULTANTS

CARTER WATKINS ASSOCIATES ARCHITECTS, INC.
 POST OFFICE BOX 1064
 137 EAST WASHINGTON STREET
 MONROE, GEORGIA 30655
 FAX: 770-267-1064
 email@carterwatkins.com www.carterwatkins.com

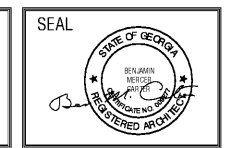

HOGANSVILLE CITY HALL

SHEET TITLE:
 REFLECTED CEILING PLAN
 PRINTED:

NUMBER:
A-104

DATE: 07/29/19

PRINTED

This Document is the property of Carter Watkins Associates. Reproduction of any kind is prohibited under Federal Copyright Laws.