


Order Plans @ WWW.LDLINE.COM

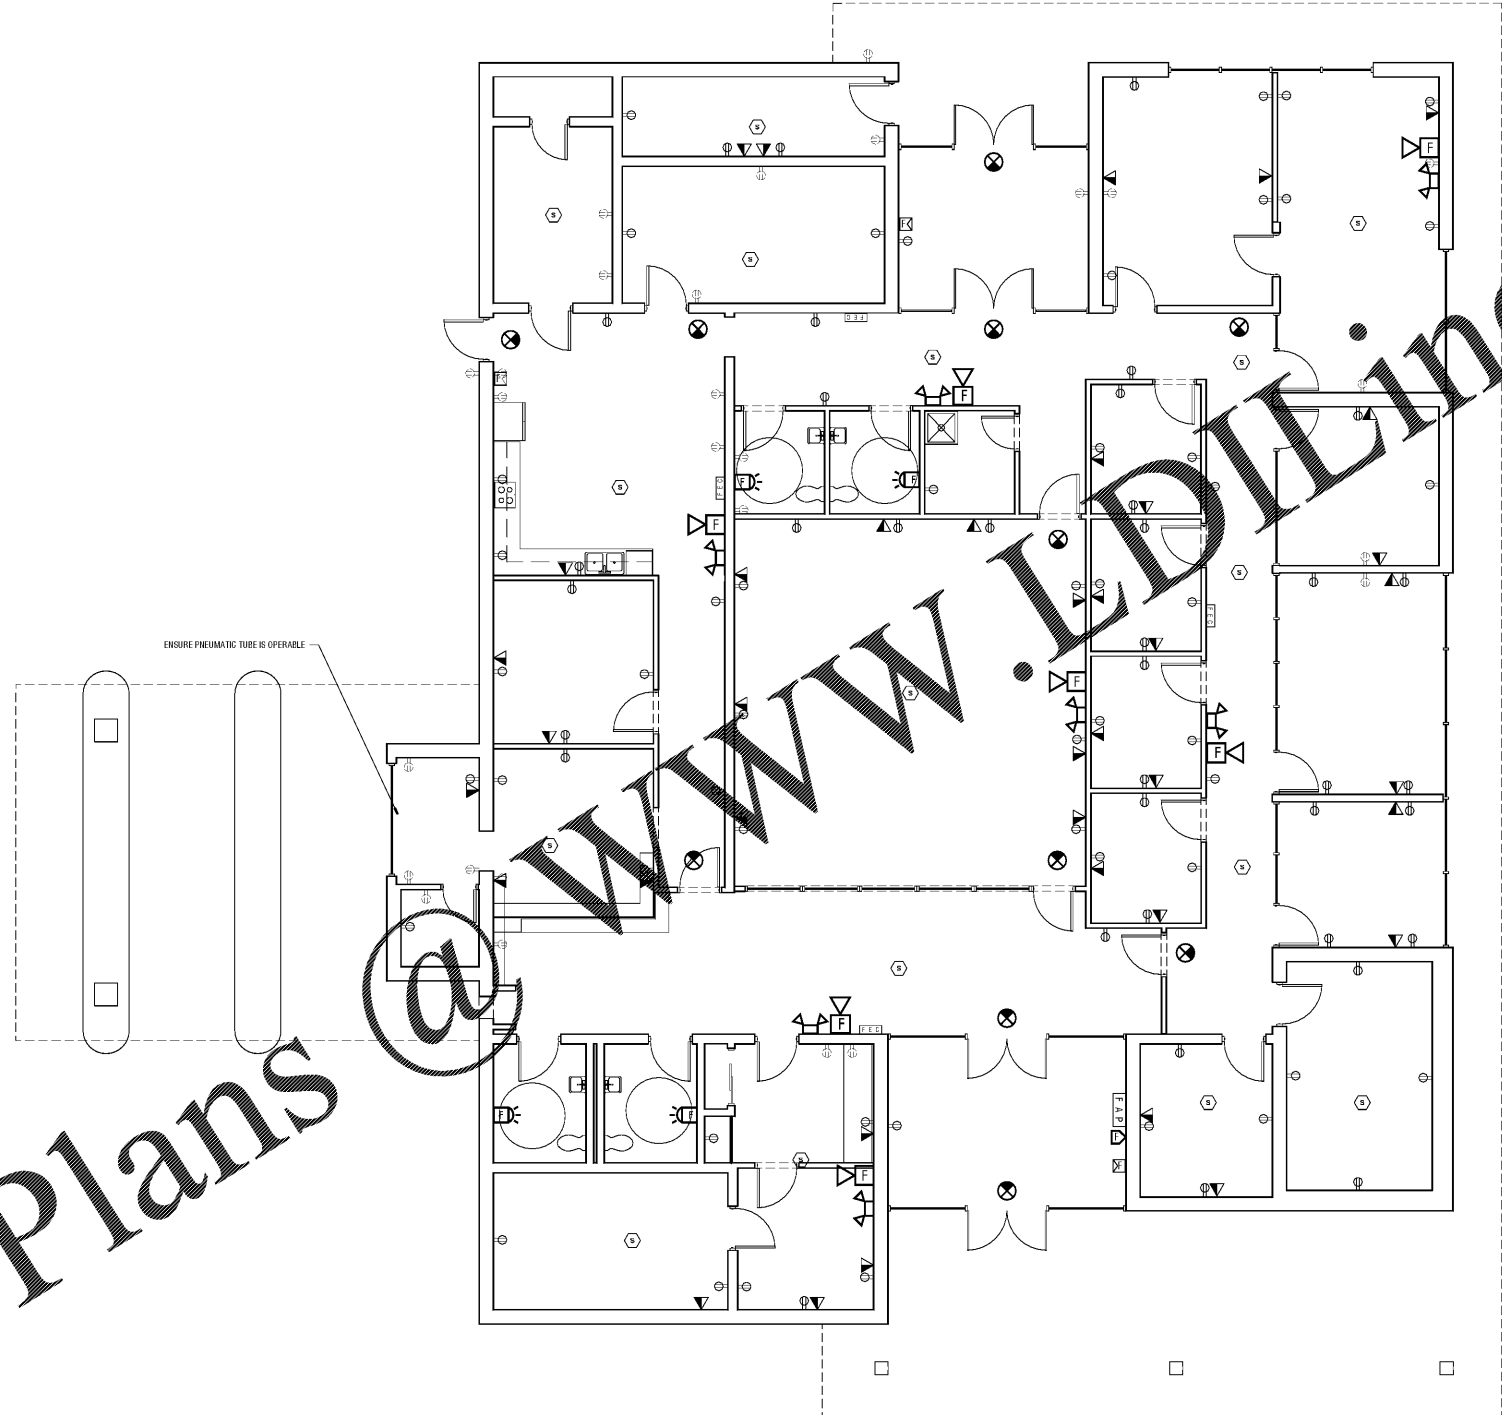

- LEGEND**
- SMOKE DETECTOR
 - RECEPTACLE
 - 220 RECEPTACLE
 - EMERGENCY EXIT LIGHT
 - DATA CONNECTION + PHONE JACK COMBO
 - FIRE ALARM PULL STATION
 - COMBINATION ALARM HORN/STROBE, 6'-8" AFF
 - STROBE ALARM, 6'-8" AFF
 - FIREMAN'S TELEPHONE
 - FIRE ALARM PANEL
 - FIRE EXTINGUISHER
 - SINGLE FACE EXIT LIGHT (CEILING OR PENDANT MOUNTED)
 - BATTERY OPERATED EMERGENCY LIGHT W/TWO HEADS
 - EXISTING RECEPTACLE

GENERAL NOTES

ALL MECHANICAL, ELECTRICAL, & PLUMBING TO BE DESIGN BUILD

ALL DATA CONNECTION LOCATIONS & DATA WIRING FOUND ON ELECTRICAL PLAN


1 ELECTRICAL & DATA CONNECTIONS PLAN
3/16" = 1"0"

JUL 29 2019 11:58 AM C:\PROJECTS\Hogansville City Hall\Bldg\Sheet\108\ELECTRICAL PLAN (CONT.).dwg

REVISIONS					
Number	Date:	Remarks:	Number	Date:	Remarks:
X	00-00-00	N/A			

CONSULTANTS

CARTER WATKINS ASSOCIATES ARCHITECTS, INC.
 POST OFFICE BOX 1064
 137 EAST WASHINGTON STREET
 MONROE, GEORGIA 30655
 FAX: 770-267-1064
 email@carterwatkins.com www.carterwatkins.com

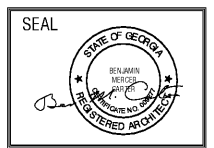

HOGANSVILLE CITY HALL

SHEET TITLE:
ELECTRICAL PLAN (CONT.)

PRINTED:

NUMBER:
E-102

DATE: 07/29/19 PRINTED