



Order Plans @ [www.IDIOnline.com](http://www.IDIOnline.com)

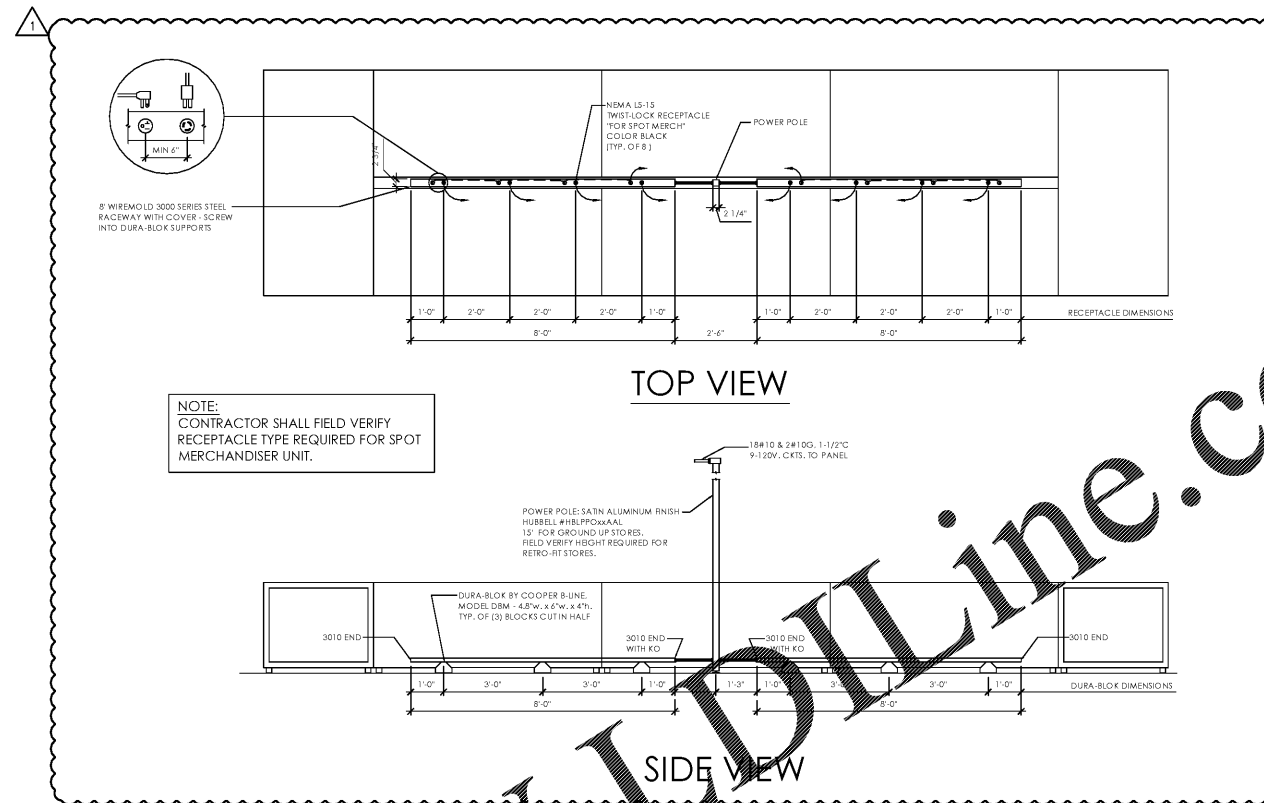

**Spot Merchandiser Raceway Detail**

SCALE: N.T.S.

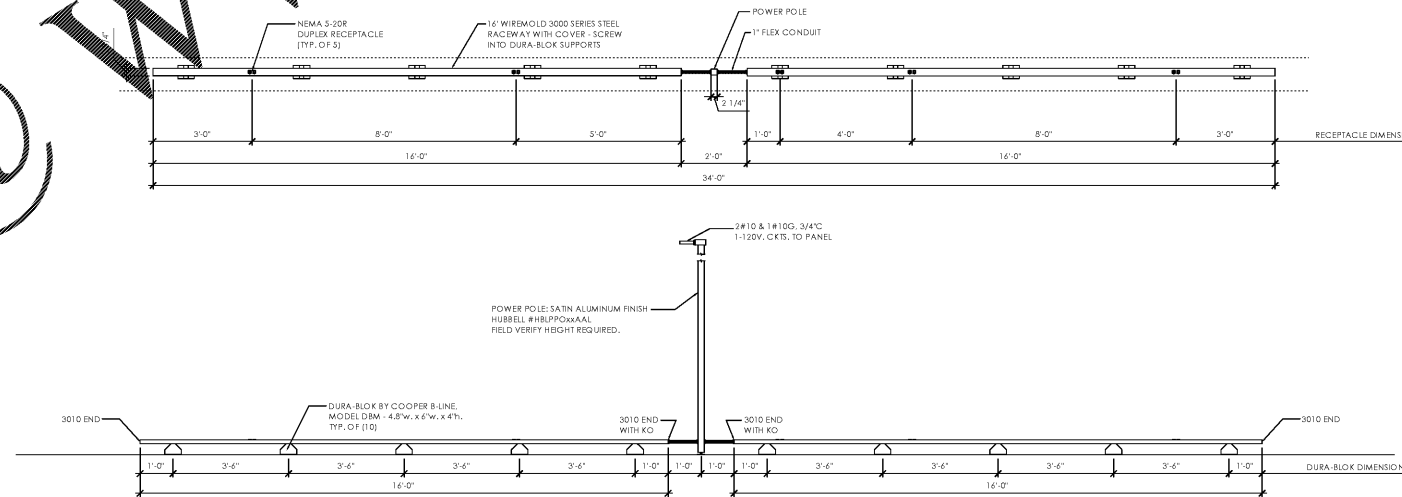

**Gondola Lighting Raceway Detail**

SCALE: N.T.S.



American Institute of Architects

310 MILLS AVE. GREENVILLE, SC 29605  
864.242.9881  
plans@narramore.net

© 2019 NARRAMORE ASSOCIATES, INC.  
COPYRIGHT PROTECTED BY FEDERAL LAW



1597 DRY POND RD.  
JEFFERSON, GA 30549  
706.387.7722  
FAX: 706.387.7701

**ALDI FOOD STORE # 54**  
2618 Pleasant Hill Road  
Duluth, GA 30096

**REVISIONS**  
△ 03/03/20

**PROJECT DATA**  
V1.07 84x170 LW Expansion  
**PROJECT NUMBER**  
19422  
**ISSUE DATE**  
12-10-19

ALDI FOOD STORE #54  
Duluth, GA

**E-502**



ATLANTA • CHARLOTTE • GREENVILLE • RICHMOND  
877.4.DEVITA • corp@devita.com  
Devita & Associates, Inc. Project : 19102-12  
Drawn By: SMD Checked By: TFW

ELECTRICAL DETAILS